


RAY GOOD
CUSTOM HOME DESIGNS

GENERAL NOTES


- 1) DO NOT SCALE DRAWINGS
 - 2) CONTRACTOR SHOULD VERIFY ALL CONDITIONS & DIMENSIONS AT SITE BEFORE BEGINNING CONSTRUCTION.
 - 3) ANY DISCREPANCIES SHOULD BE REPORTED TO RG CUSTOM HOME DESIGNS FOR JUSTIFICATION AND/OR CORRECTIONS BEFORE PROCEEDING WITH WORK.
 - 4) CONTRACTOR SHALL ASSUME ALL RESPONSIBILITY FOR ERRORS THAT ARE NOT REPORTED.
 - 5) ALL WORK SHOULD BE PERFORMED IN ACCORDANCE WITH ALL APPLICABLE INTERNATIONAL BUILDING CODES.
- © RG CUSTOM HOME DESIGNS, INC. 2008

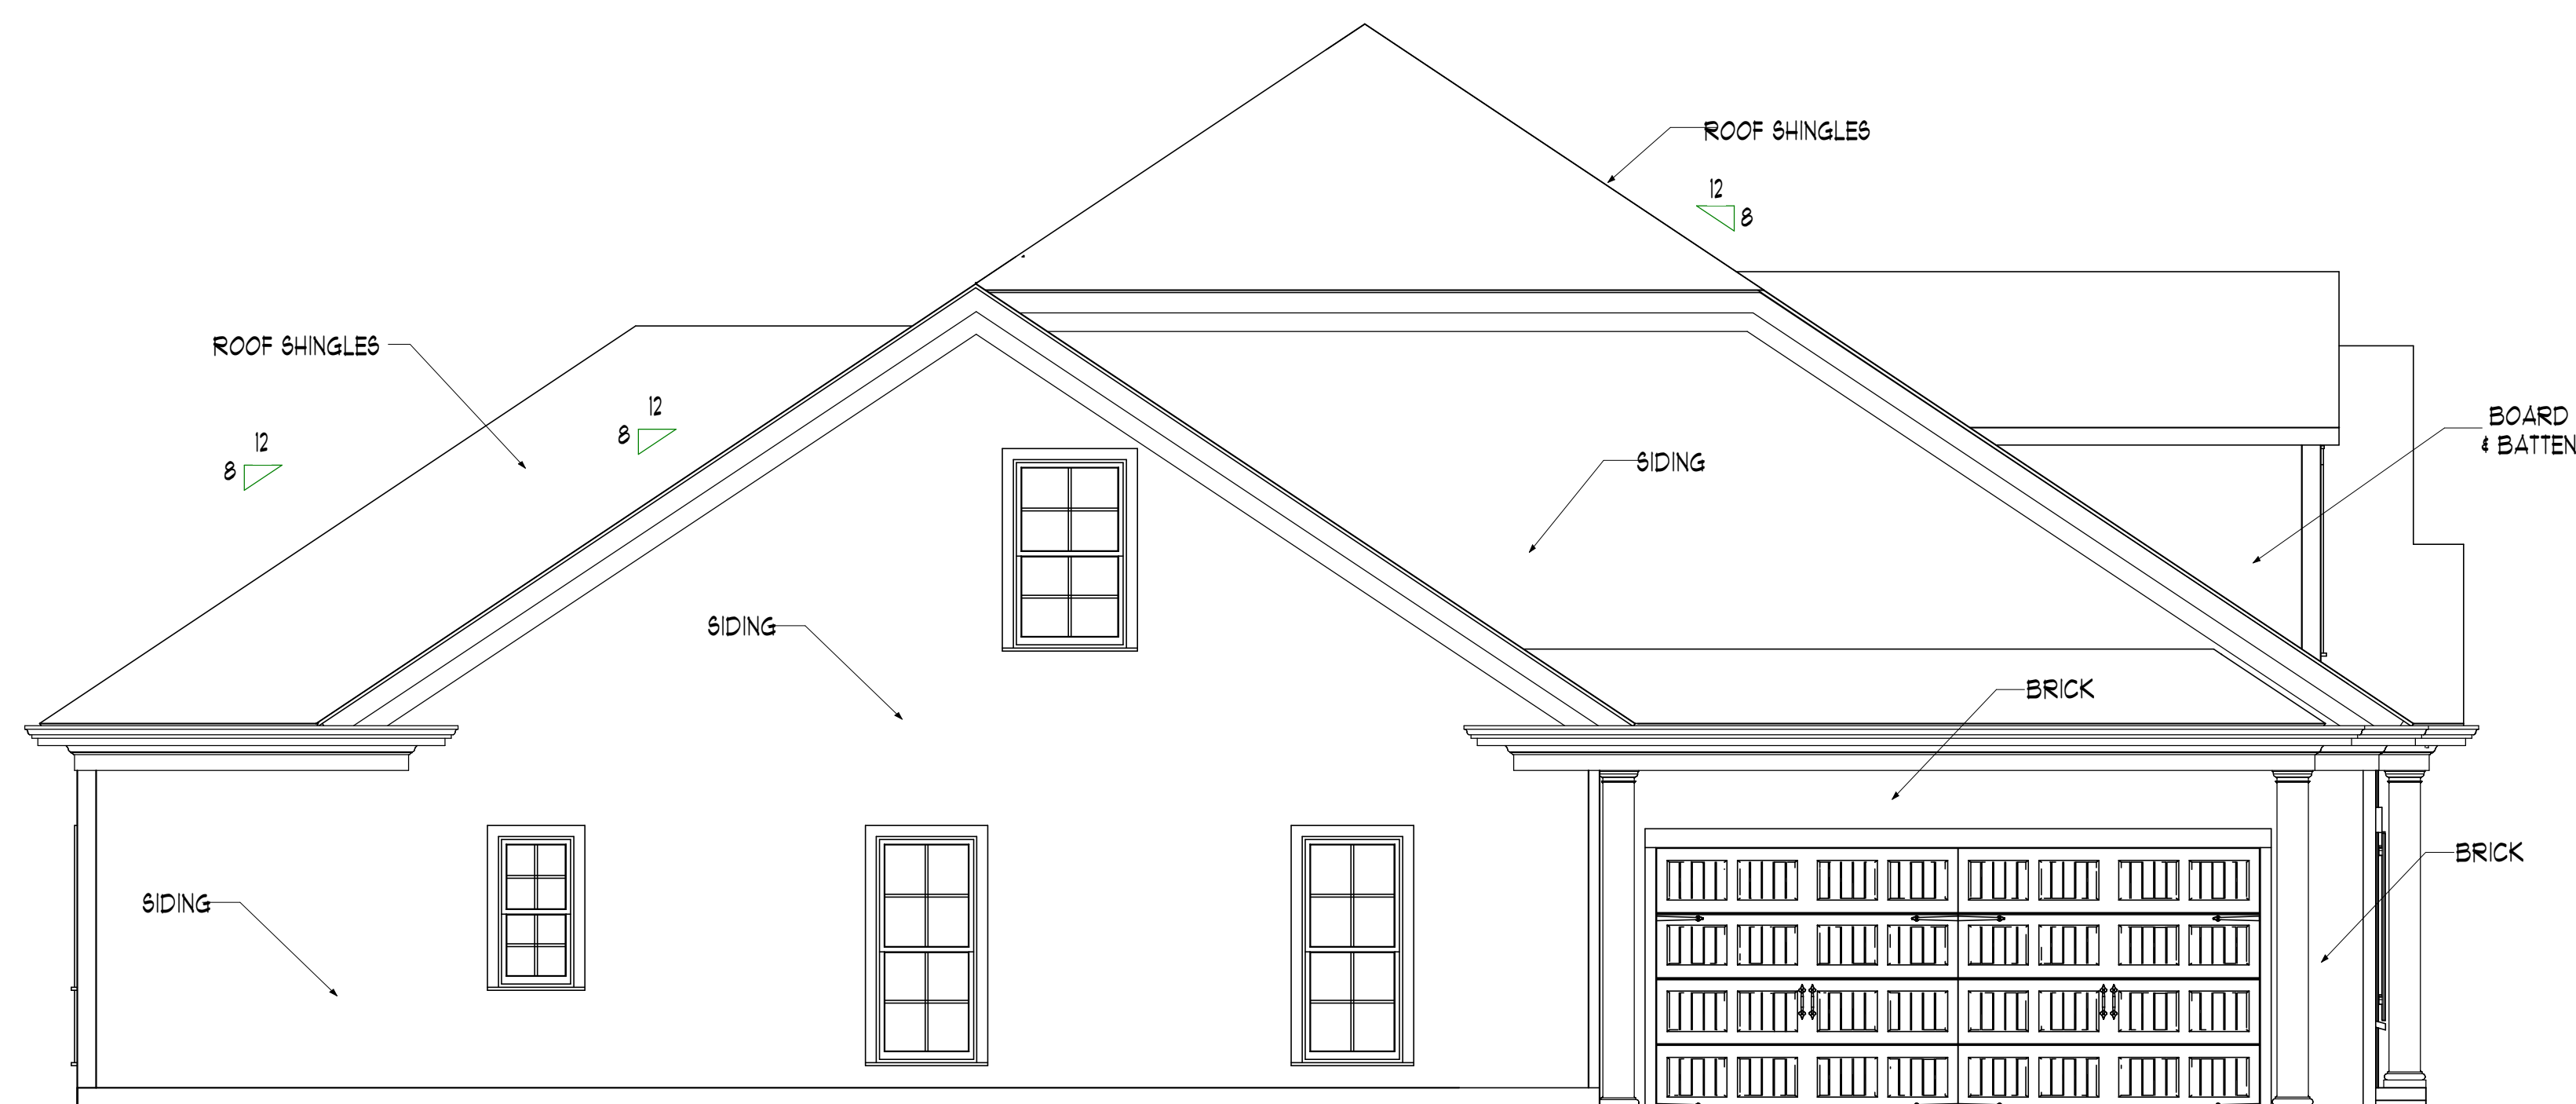


LEFT ELEVATION
SCALE 1/4" = 1'-0"



FRONT ELEVATION
SCALE 1/4" = 1'-0"

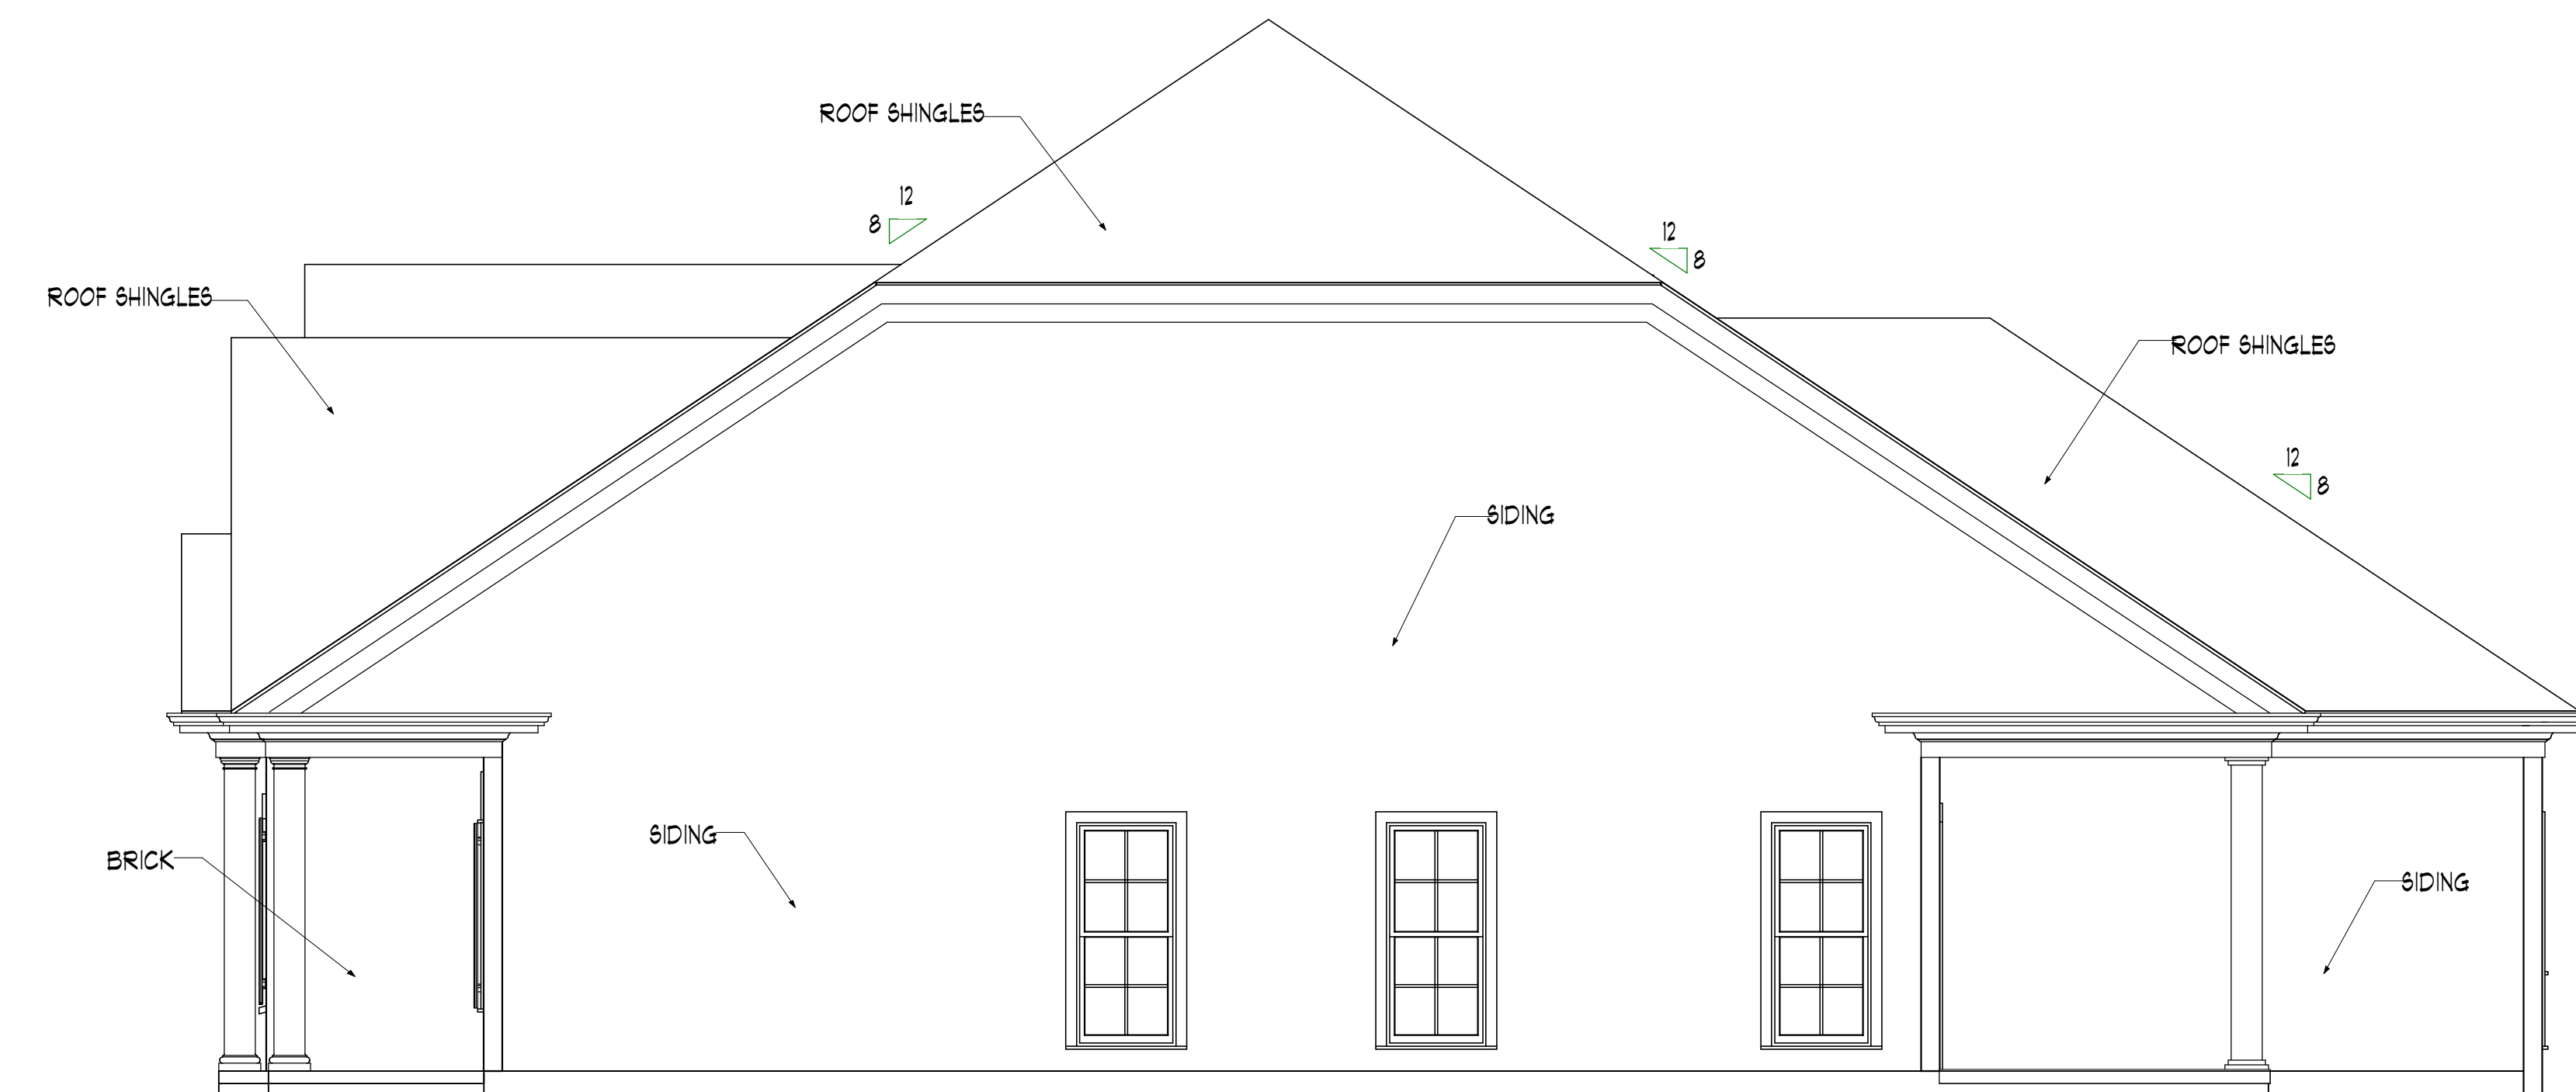

RIGHT ELEVATION
SCALE 1/4" = 1'-0"

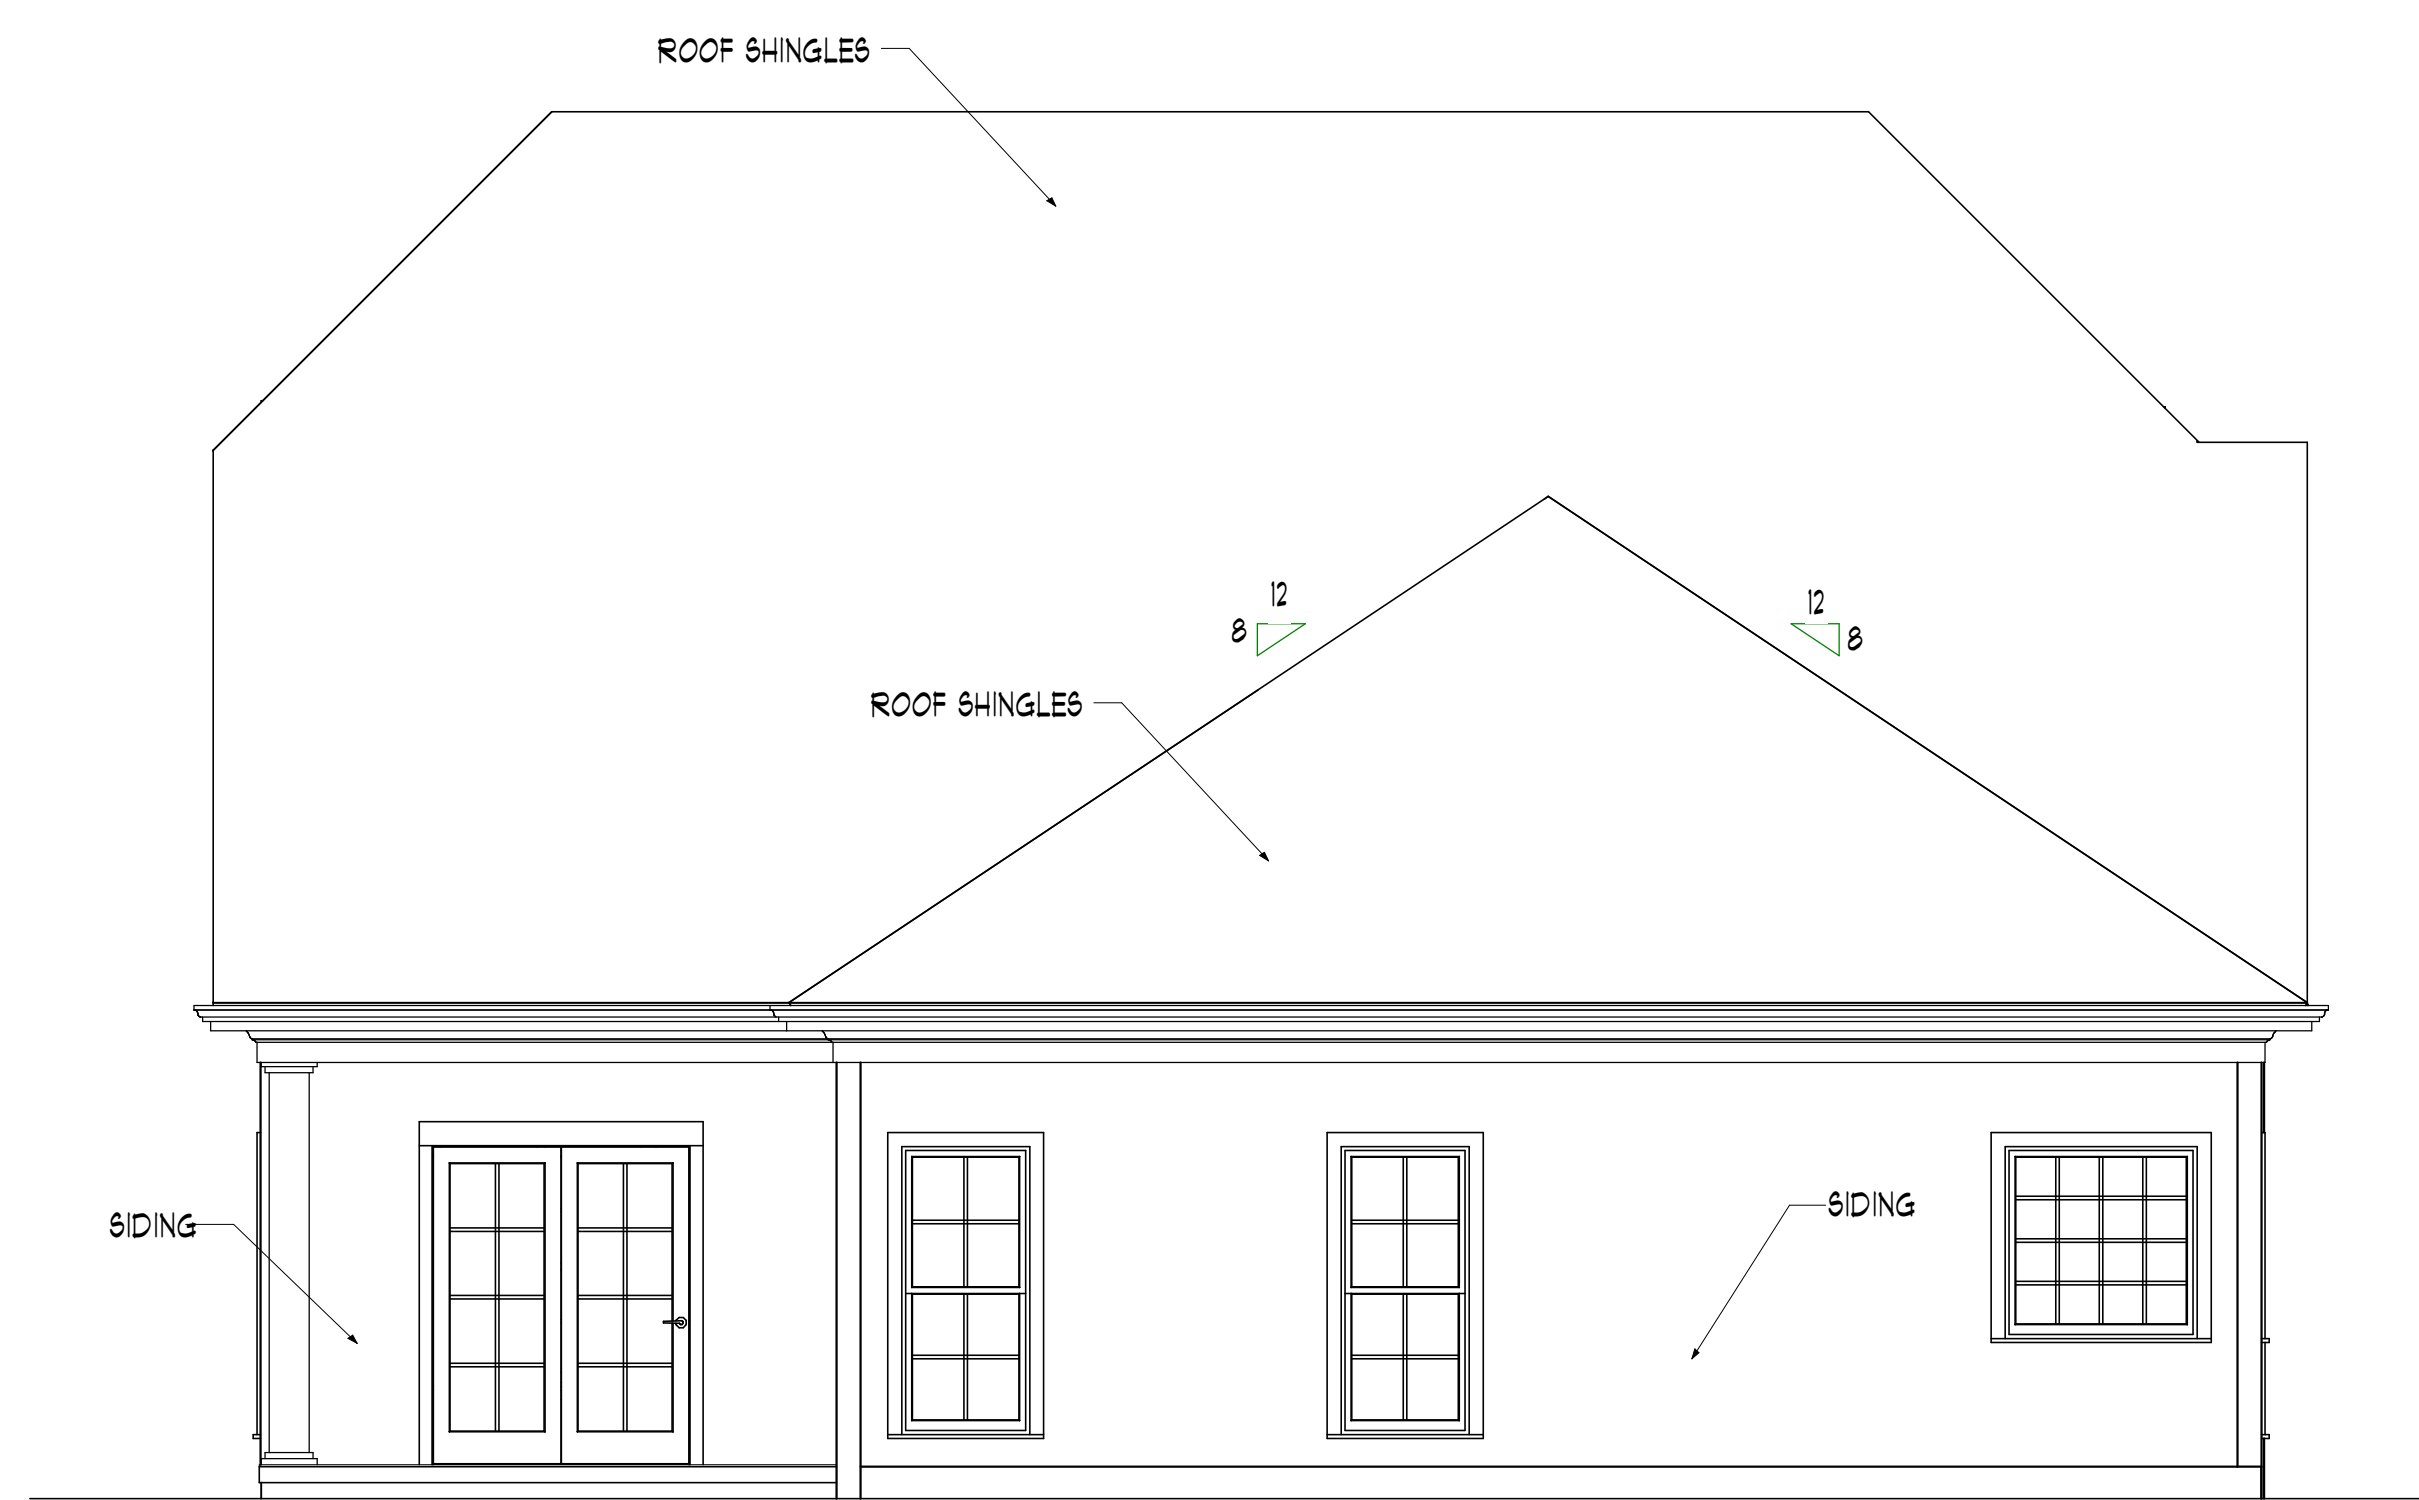

REAR ELEVATION
SCALE 1/4" = 1'-0"

WEAVER
HOMEBUILDERS

CLIENT NAME

"Designers of
the 2008 Dream Home"

www.RGoodDesigns.com

427 North Belair Rd.
Evans, G.A. 30809
Cell: 706-267-8555
Office: 706-364-8554
Fax: 706-955-7945

Date Printed: 2/26/2014

Scale:
As Noted


Drawn By:
Gregory Brown
Checked By:
Ray Good

Project Number

1675 A

A-1

Sheet # 1 OF 4

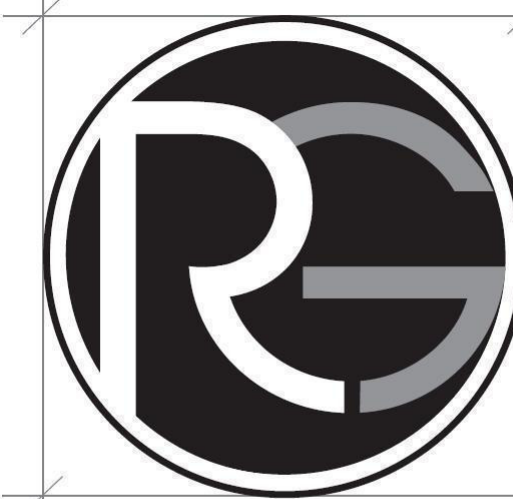

RAY GOOD
CUSTOM HOME DESIGNS

GENERAL NOTES

- 1) DO NOT SCALE DRAWINGS
 - 2) CONTRACTOR SHOULD VERIFY ALL CONDITIONS & DIMENSIONS AT SITE BEFORE BEGINNING CONSTRUCTION.
 - 3) ANY DISCREPANCIES SHOULD BE REPORTED TO RG CUSTOM HOME DESIGNS FOR JUSTIFICATION AND/OR CORRECTIONS BEFORE PROCEEDING WITH WORK.
 - 4) CONTRACTOR SHALL ASSUME ALL RESPONSIBILITY FOR ERRORS THAT ARE NOT REPORTED.
 - 5) ALL WORK SHOULD BE PERFORMED IN ACCORDANCE WITH ALL APPLICABLE INTERNATIONAL BUILDING CODES.
- © RG CUSTOM HOME DESIGNS, INC. 2008

WEAVER
HOMEBUILDERS

CLIENT NAME

"Designers of
the 2008 Dream Home"

www.RGoodDesigns.com

427 North Belair Rd.
Evans, G.A. 30809
Cell: 706-267-8555
Office: 706-364-8554
Fax: 706-955-7945

Date Printed: 2/26/2014



Scale:
As Noted


Drawn By:
Gregory Brown
Checked By:
Ray Good

Project Number


1675 A
A-2

Sheet # 2 OF 4

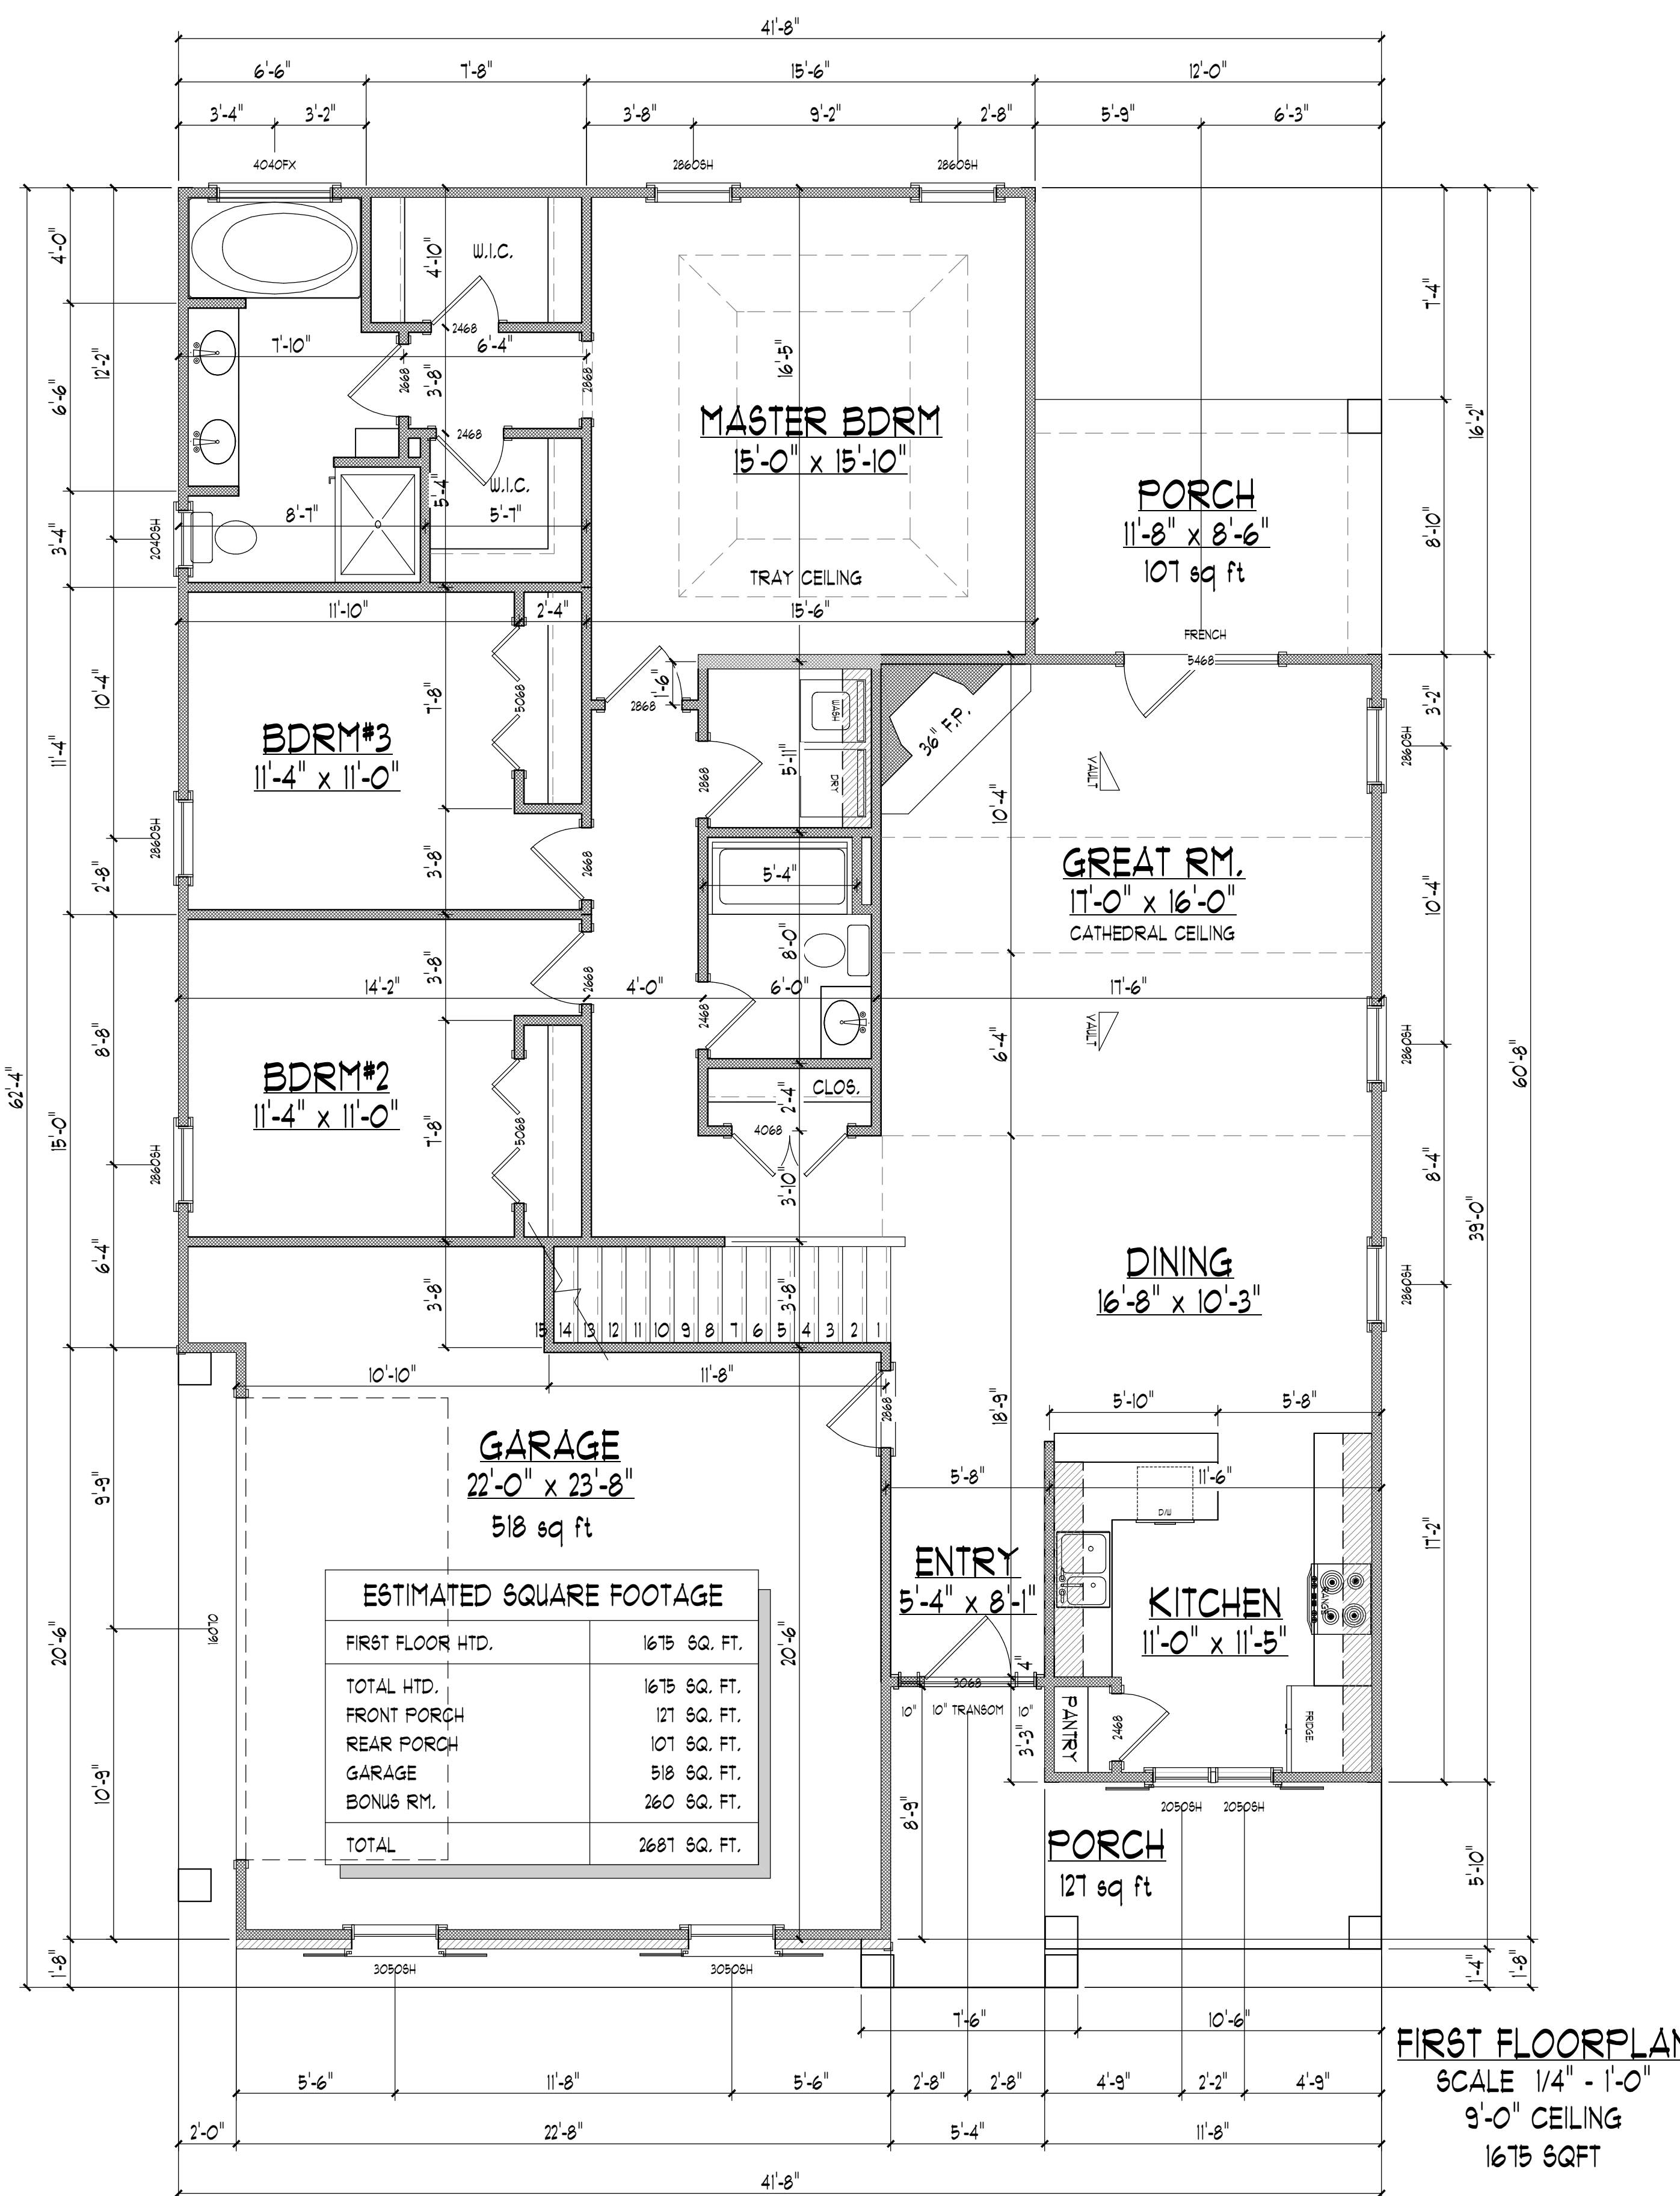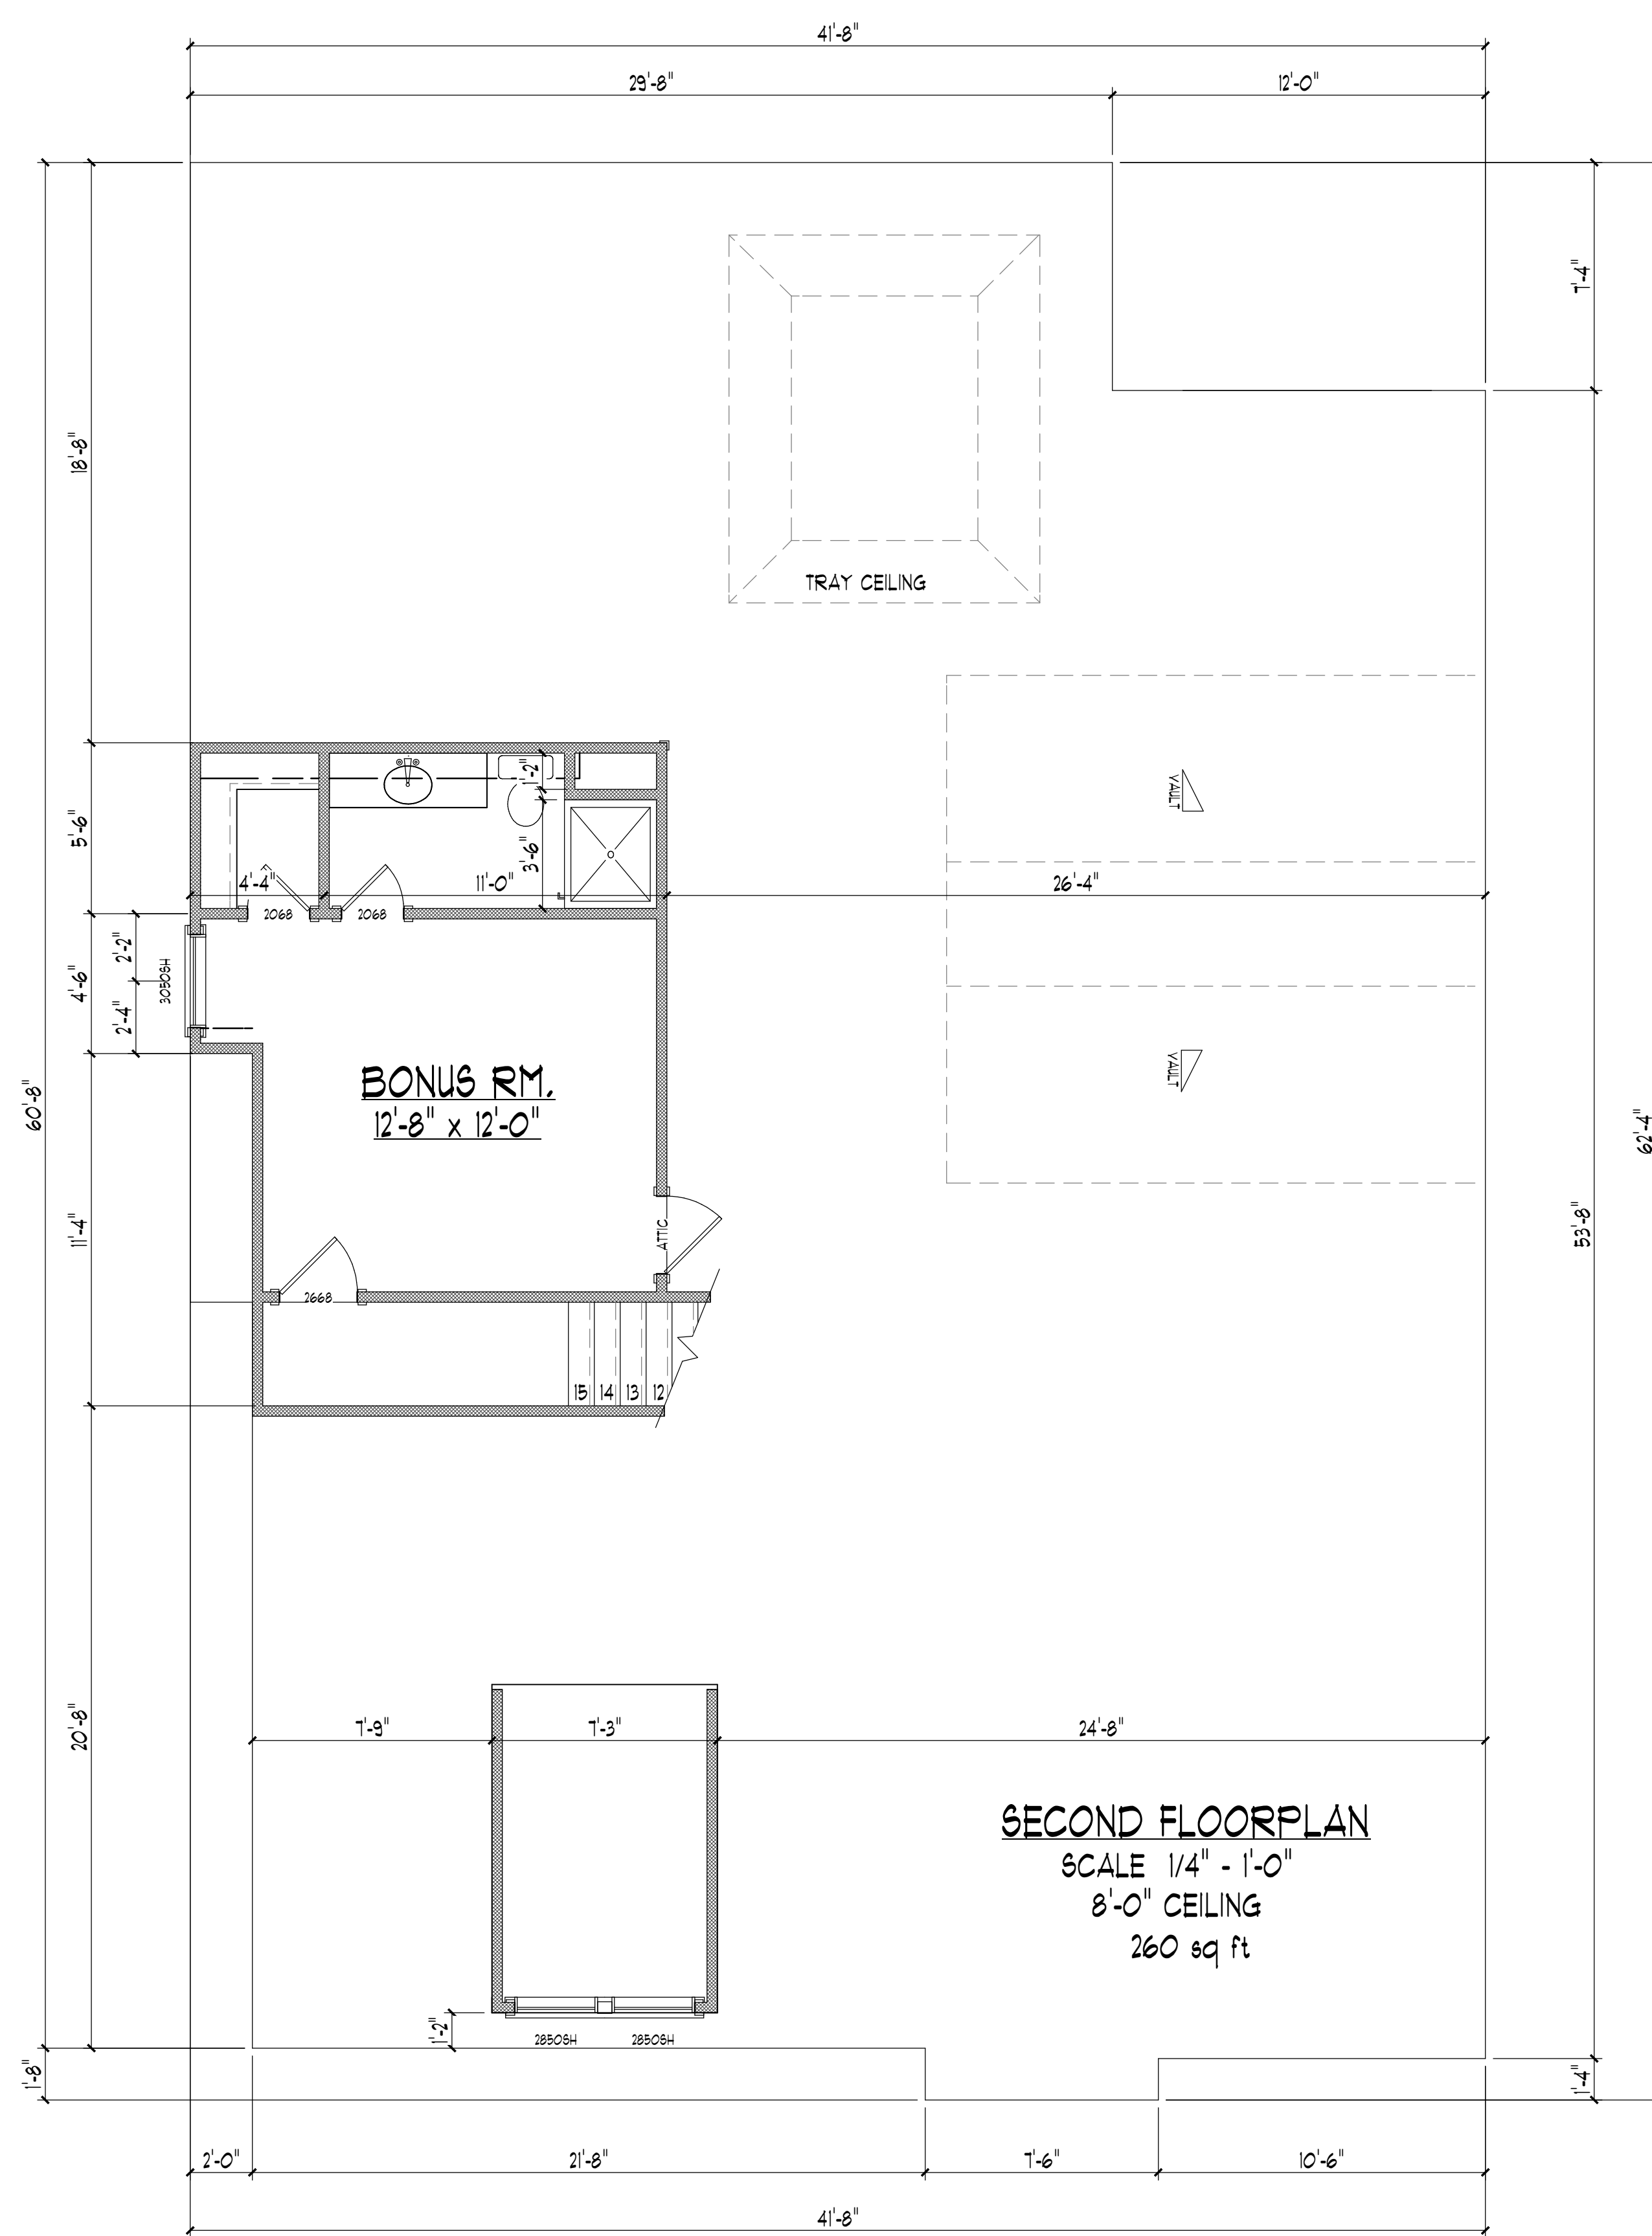

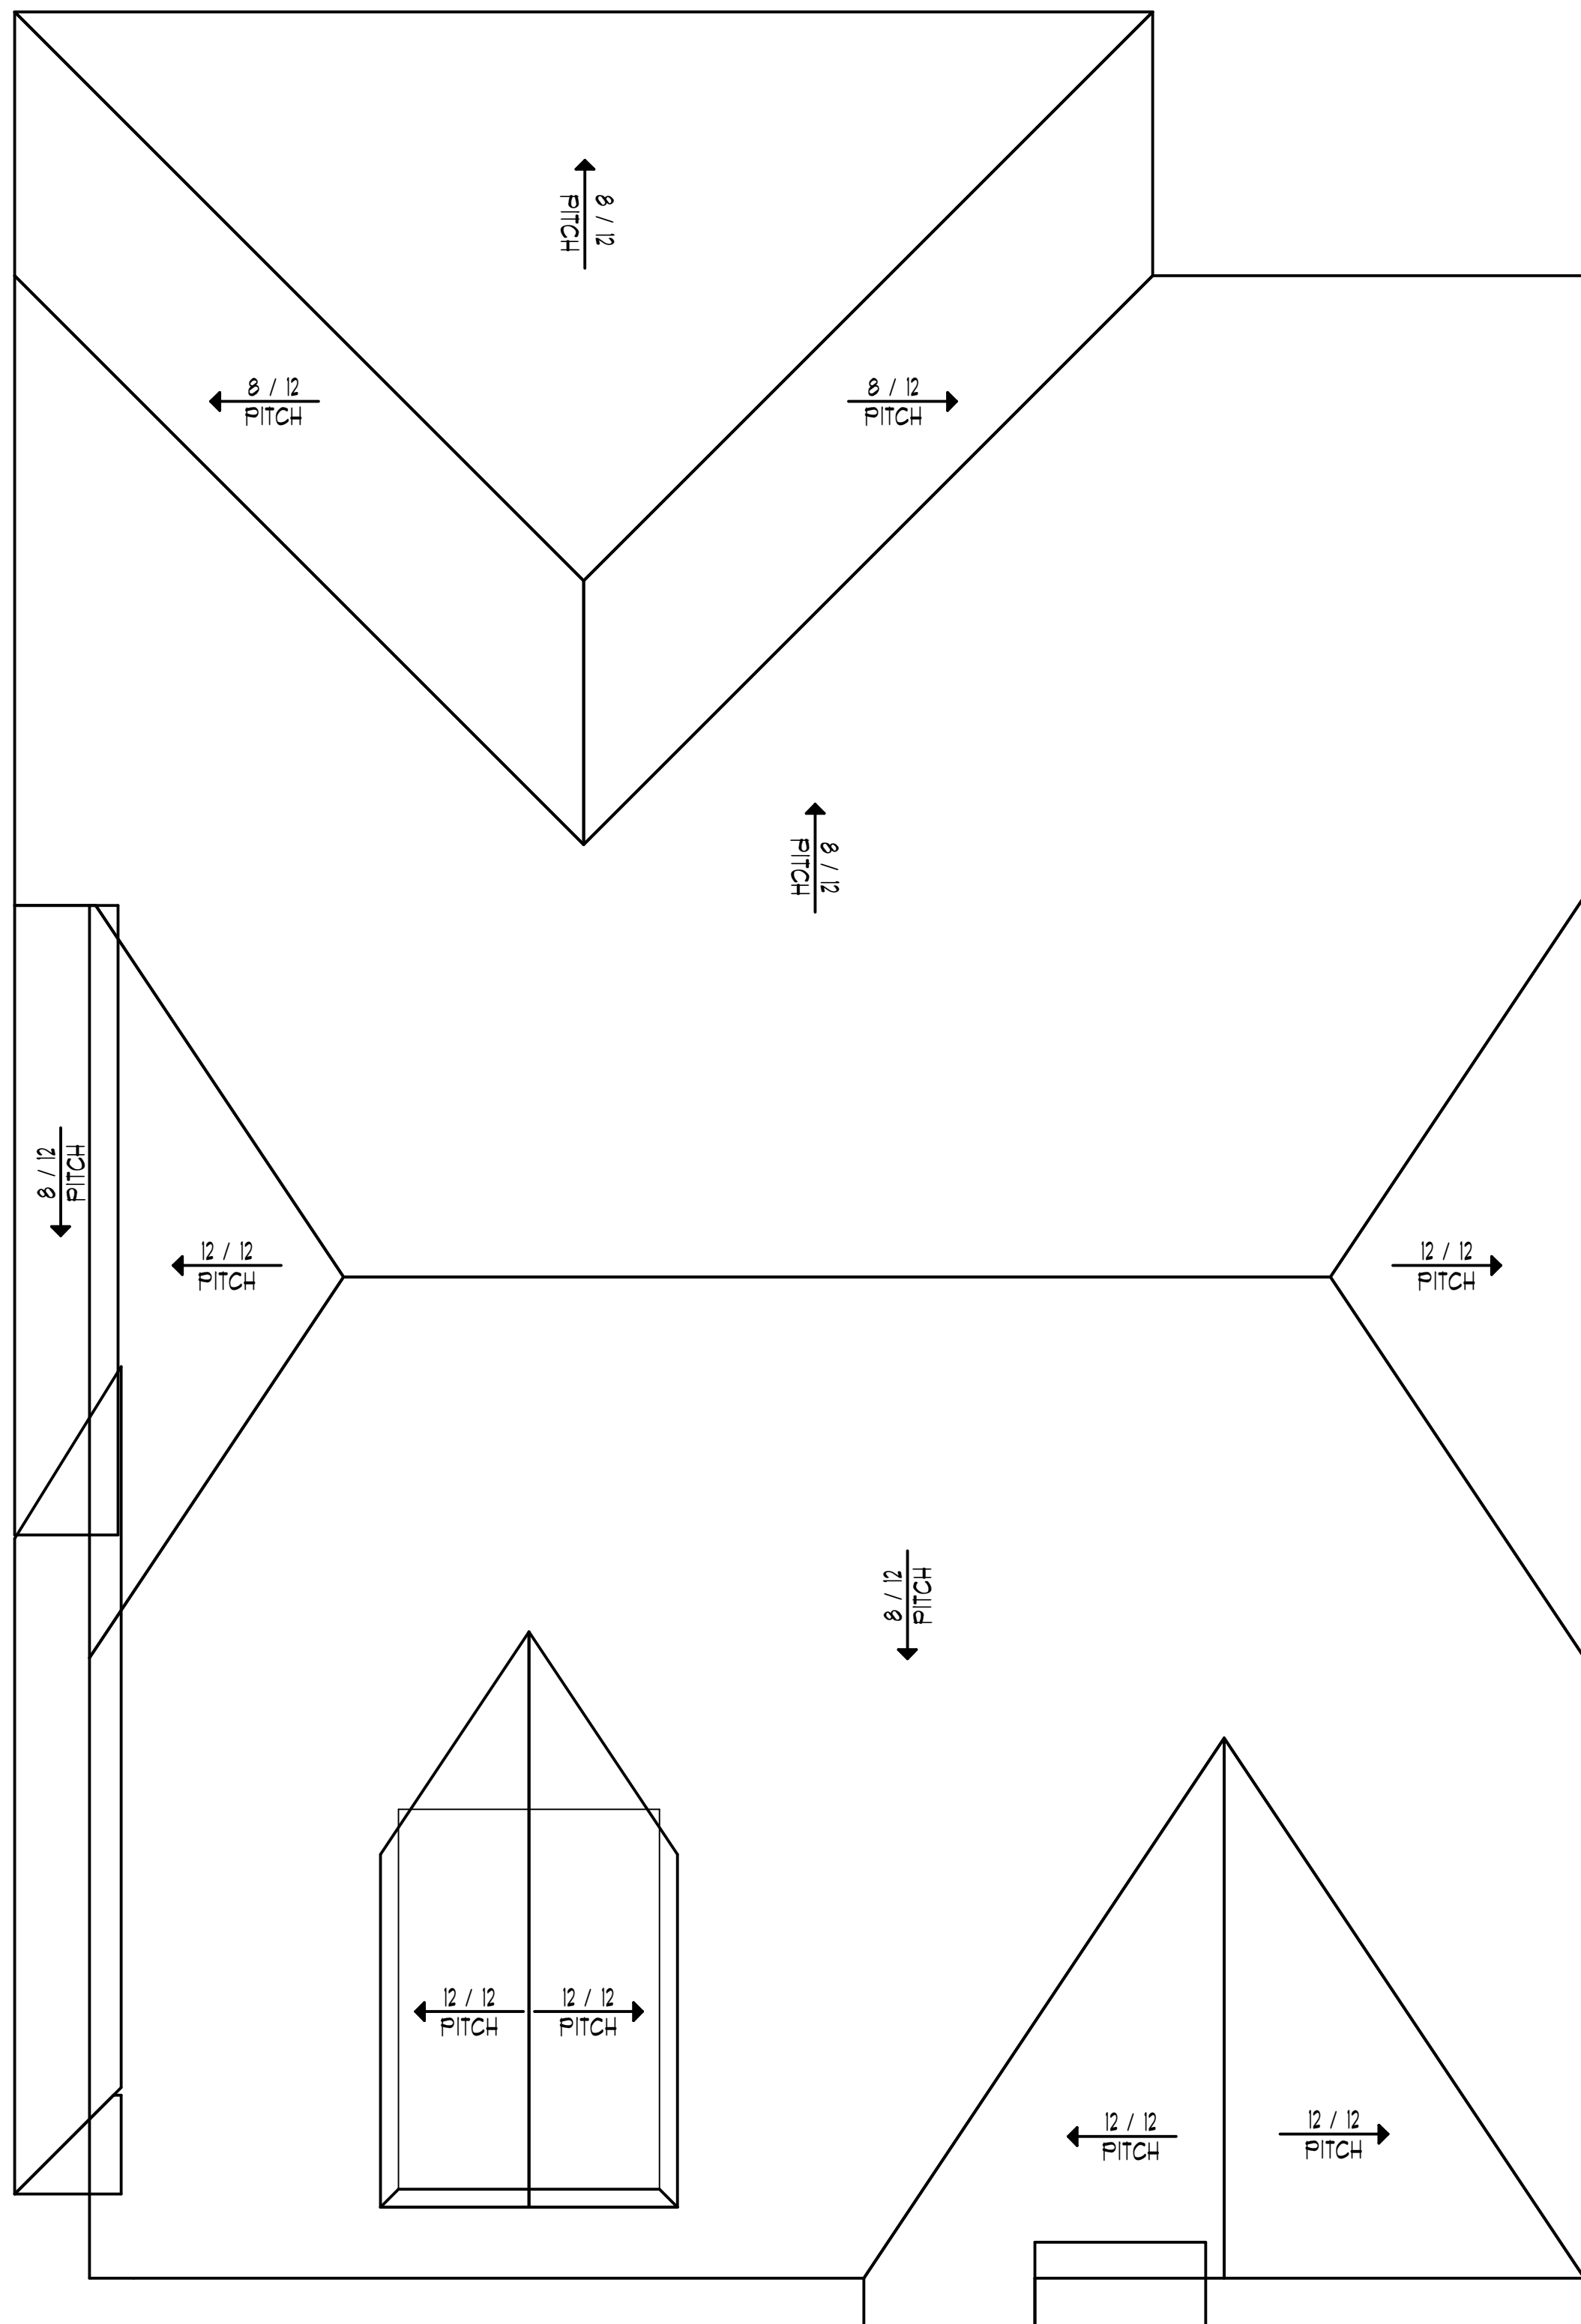

ROOF PLAN
SCALE 1/4" = 1'-0"

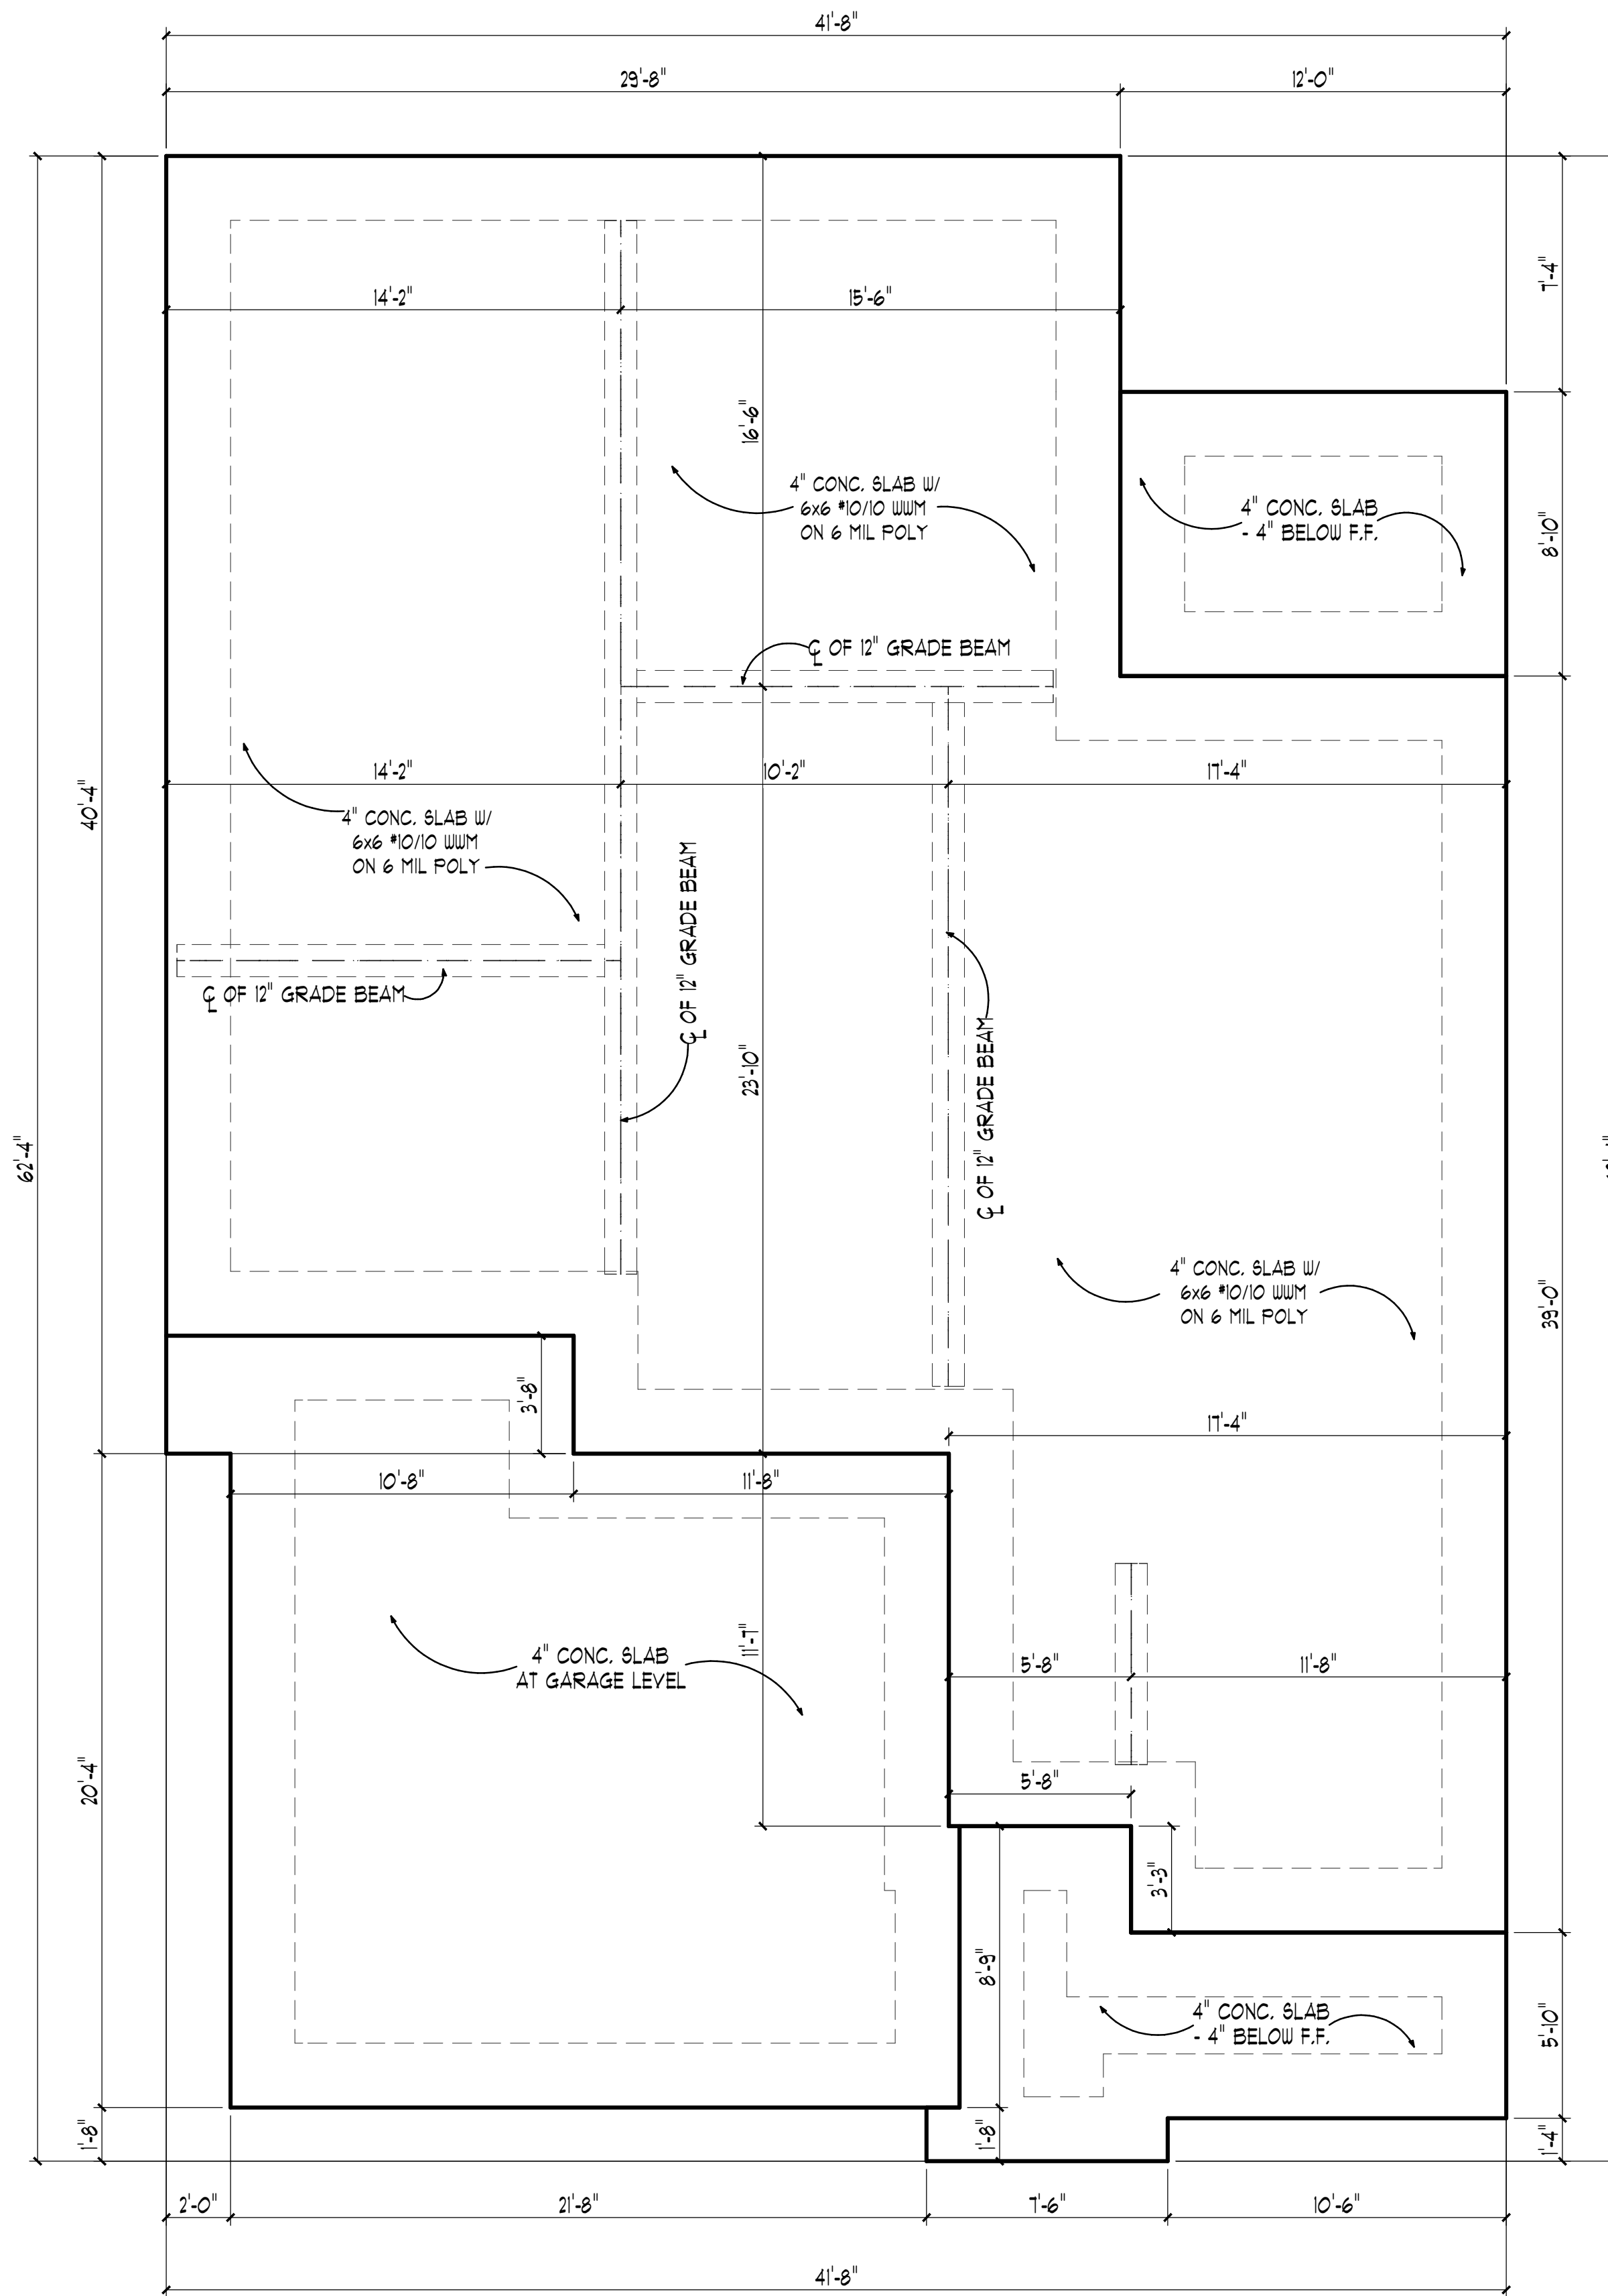

FOUNDATION PLAN
SCALE 1/4" = 1'-0"



RAY GOOD
CUSTOM HOME DESIGNS

GENERAL NOTES

- 1) DO NOT SCALE DRAWINGS
- 2) CONTRACTOR SHOULD VERIFY ALL CONDITIONS & DIMENSIONS AT SITE BEFORE BEGINNING CONSTRUCTION.
- 3) ANY DISCREPANCIES SHOULD BE REPORTED TO RG CUSTOM HOME DESIGNS FOR JUSTIFICATION AND/OR CORRECTIONS BEFORE PROCEEDING WITH WORK.
- 4) CONTRACTOR SHALL ASSUME ALL RESPONSIBILITY FOR ERRORS THAT ARE NOT REPORTED.
- 5) ALL WORK SHOULD BE PERFORMED IN ACCORDANCE WITH ALL APPLICABLE INTERNATIONAL BUILDING CODES.

© RG CUSTOM HOME DESIGNS, INC. 2008

WEAVER
HOMEBUILDERS

CLIENT NAME

"Designers of
the 2008 Dream Home"
www.RGoodDesigns.com

427 North Belair Rd.
Evans, G.A. 30809
Cell: 706-267-8555
Office: 706-364-8554
Fax: 706-955-7945

Date Printed: 2/26/2014




Scale:
As Noted

Drawn By:
Gregory Brown
Checked By:
Ray Good

Project Number


1675 A
A-3

Sheet # 3 OF 4

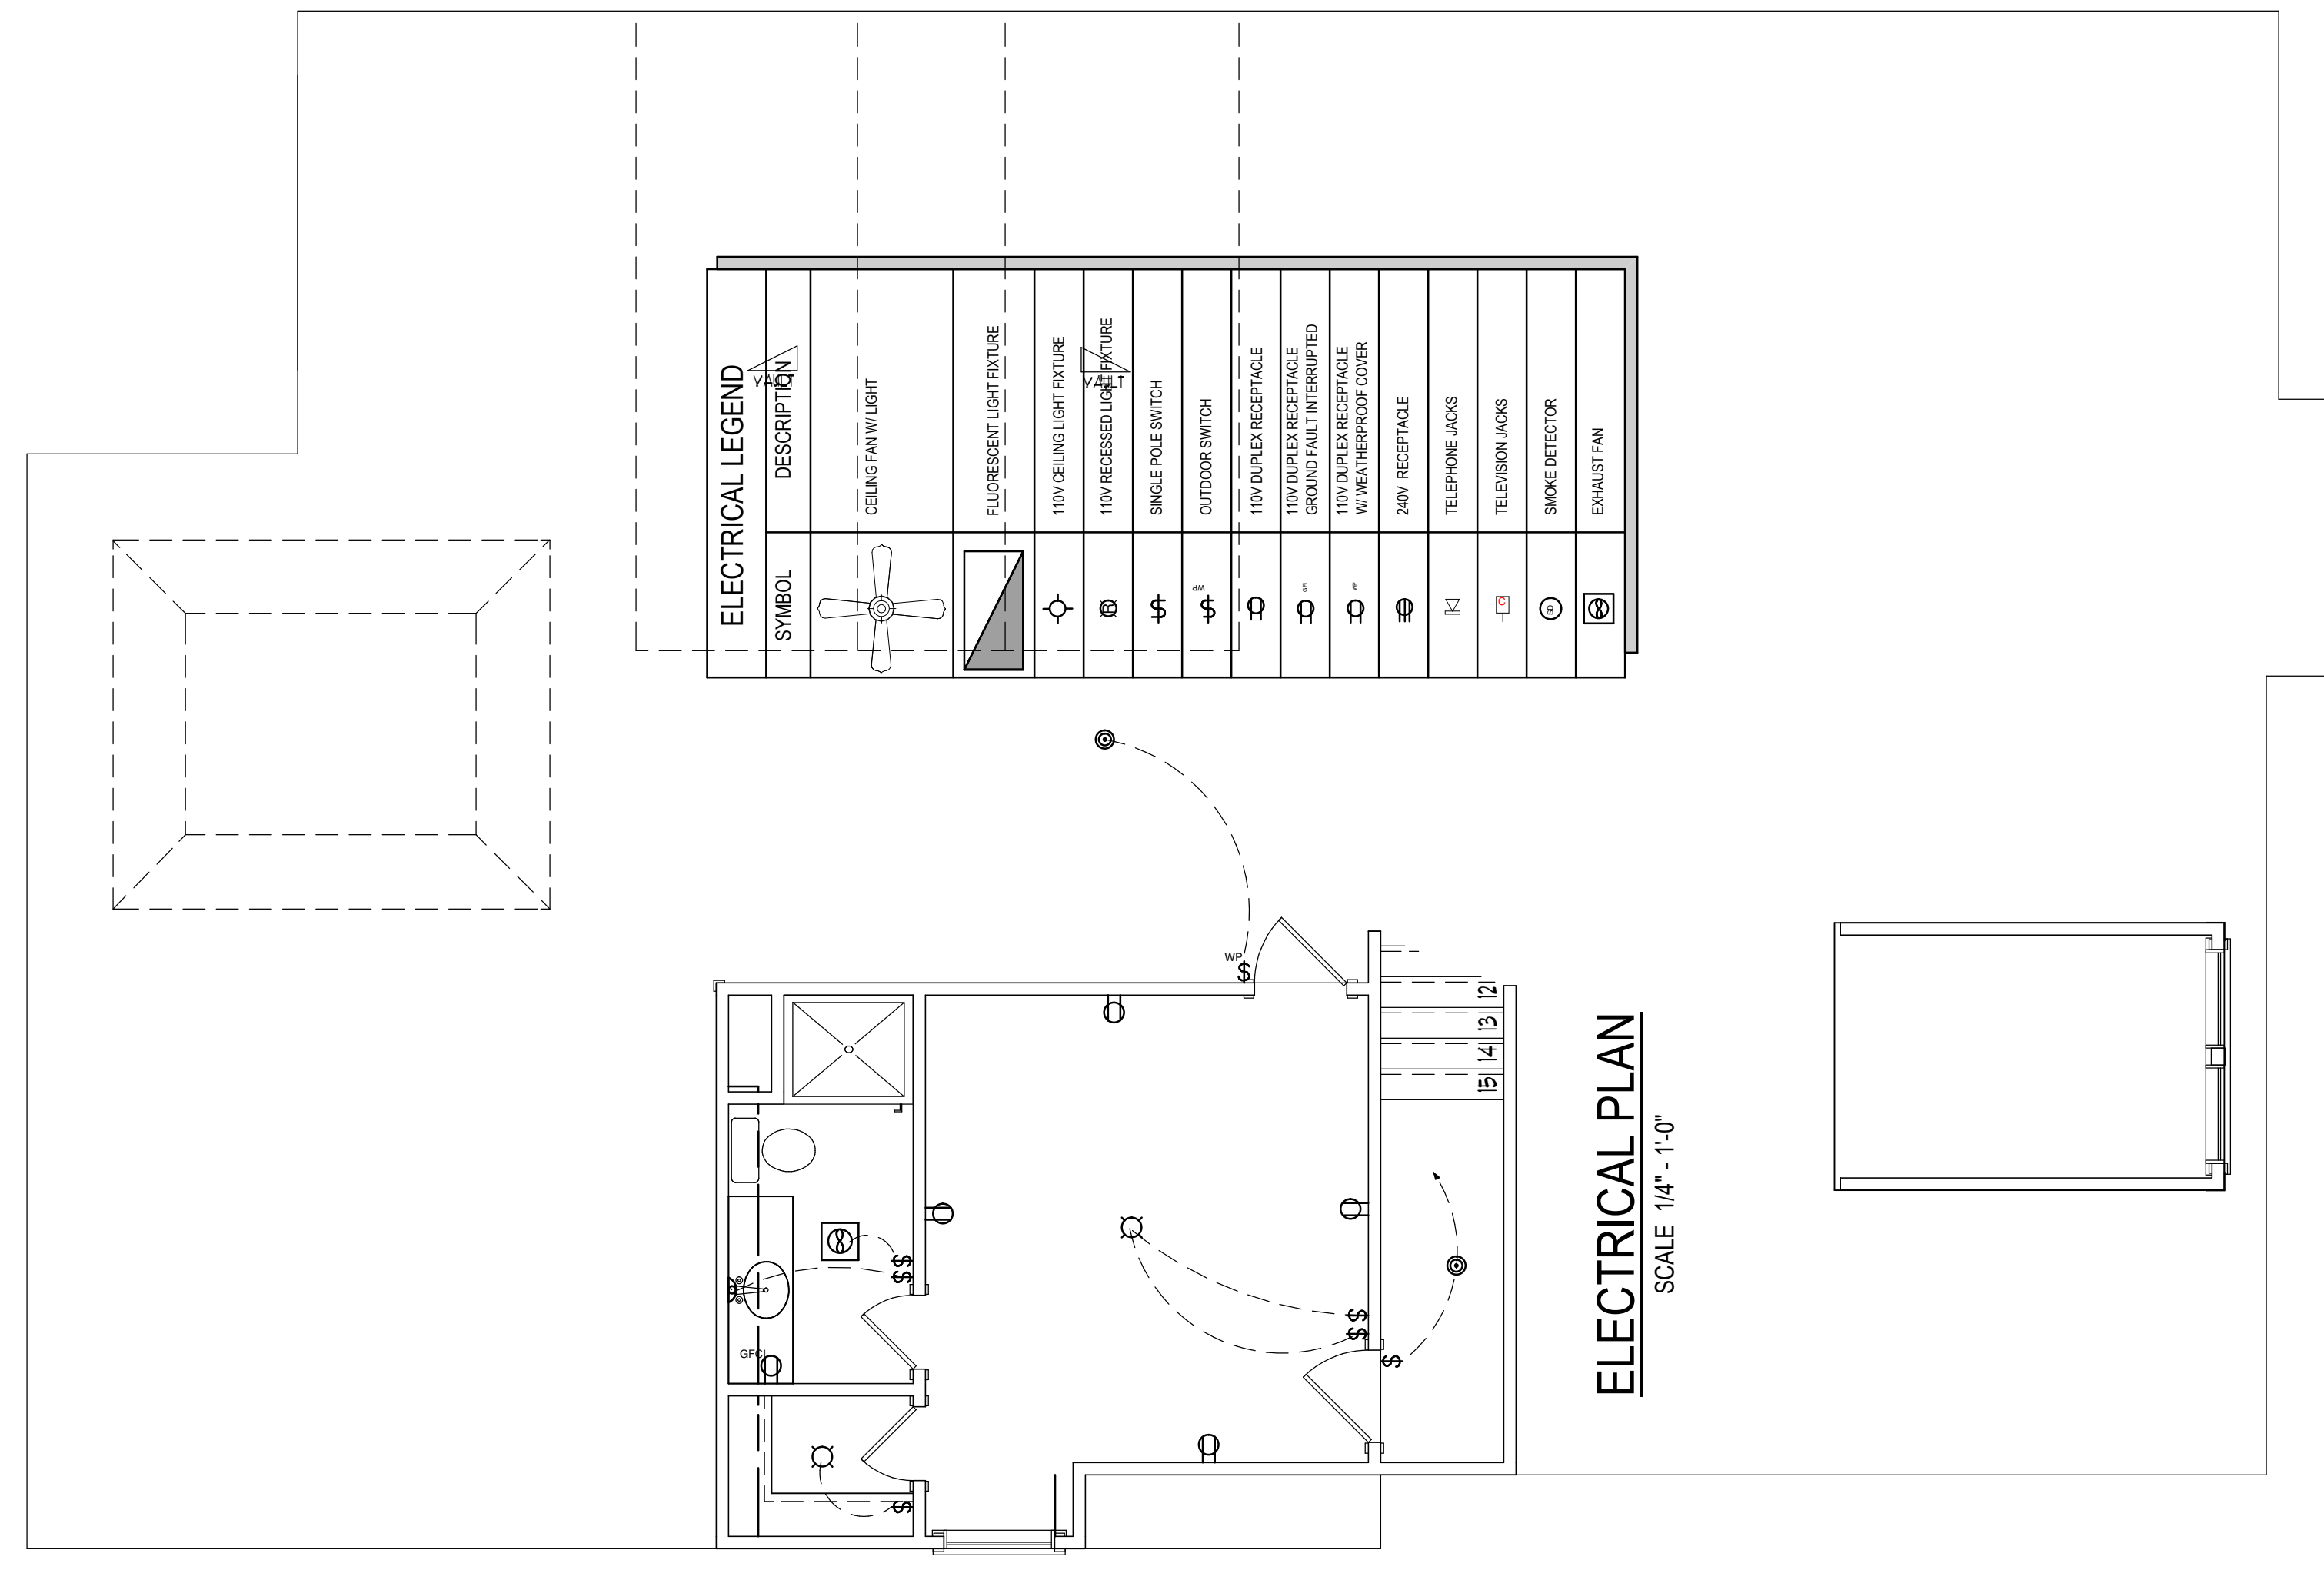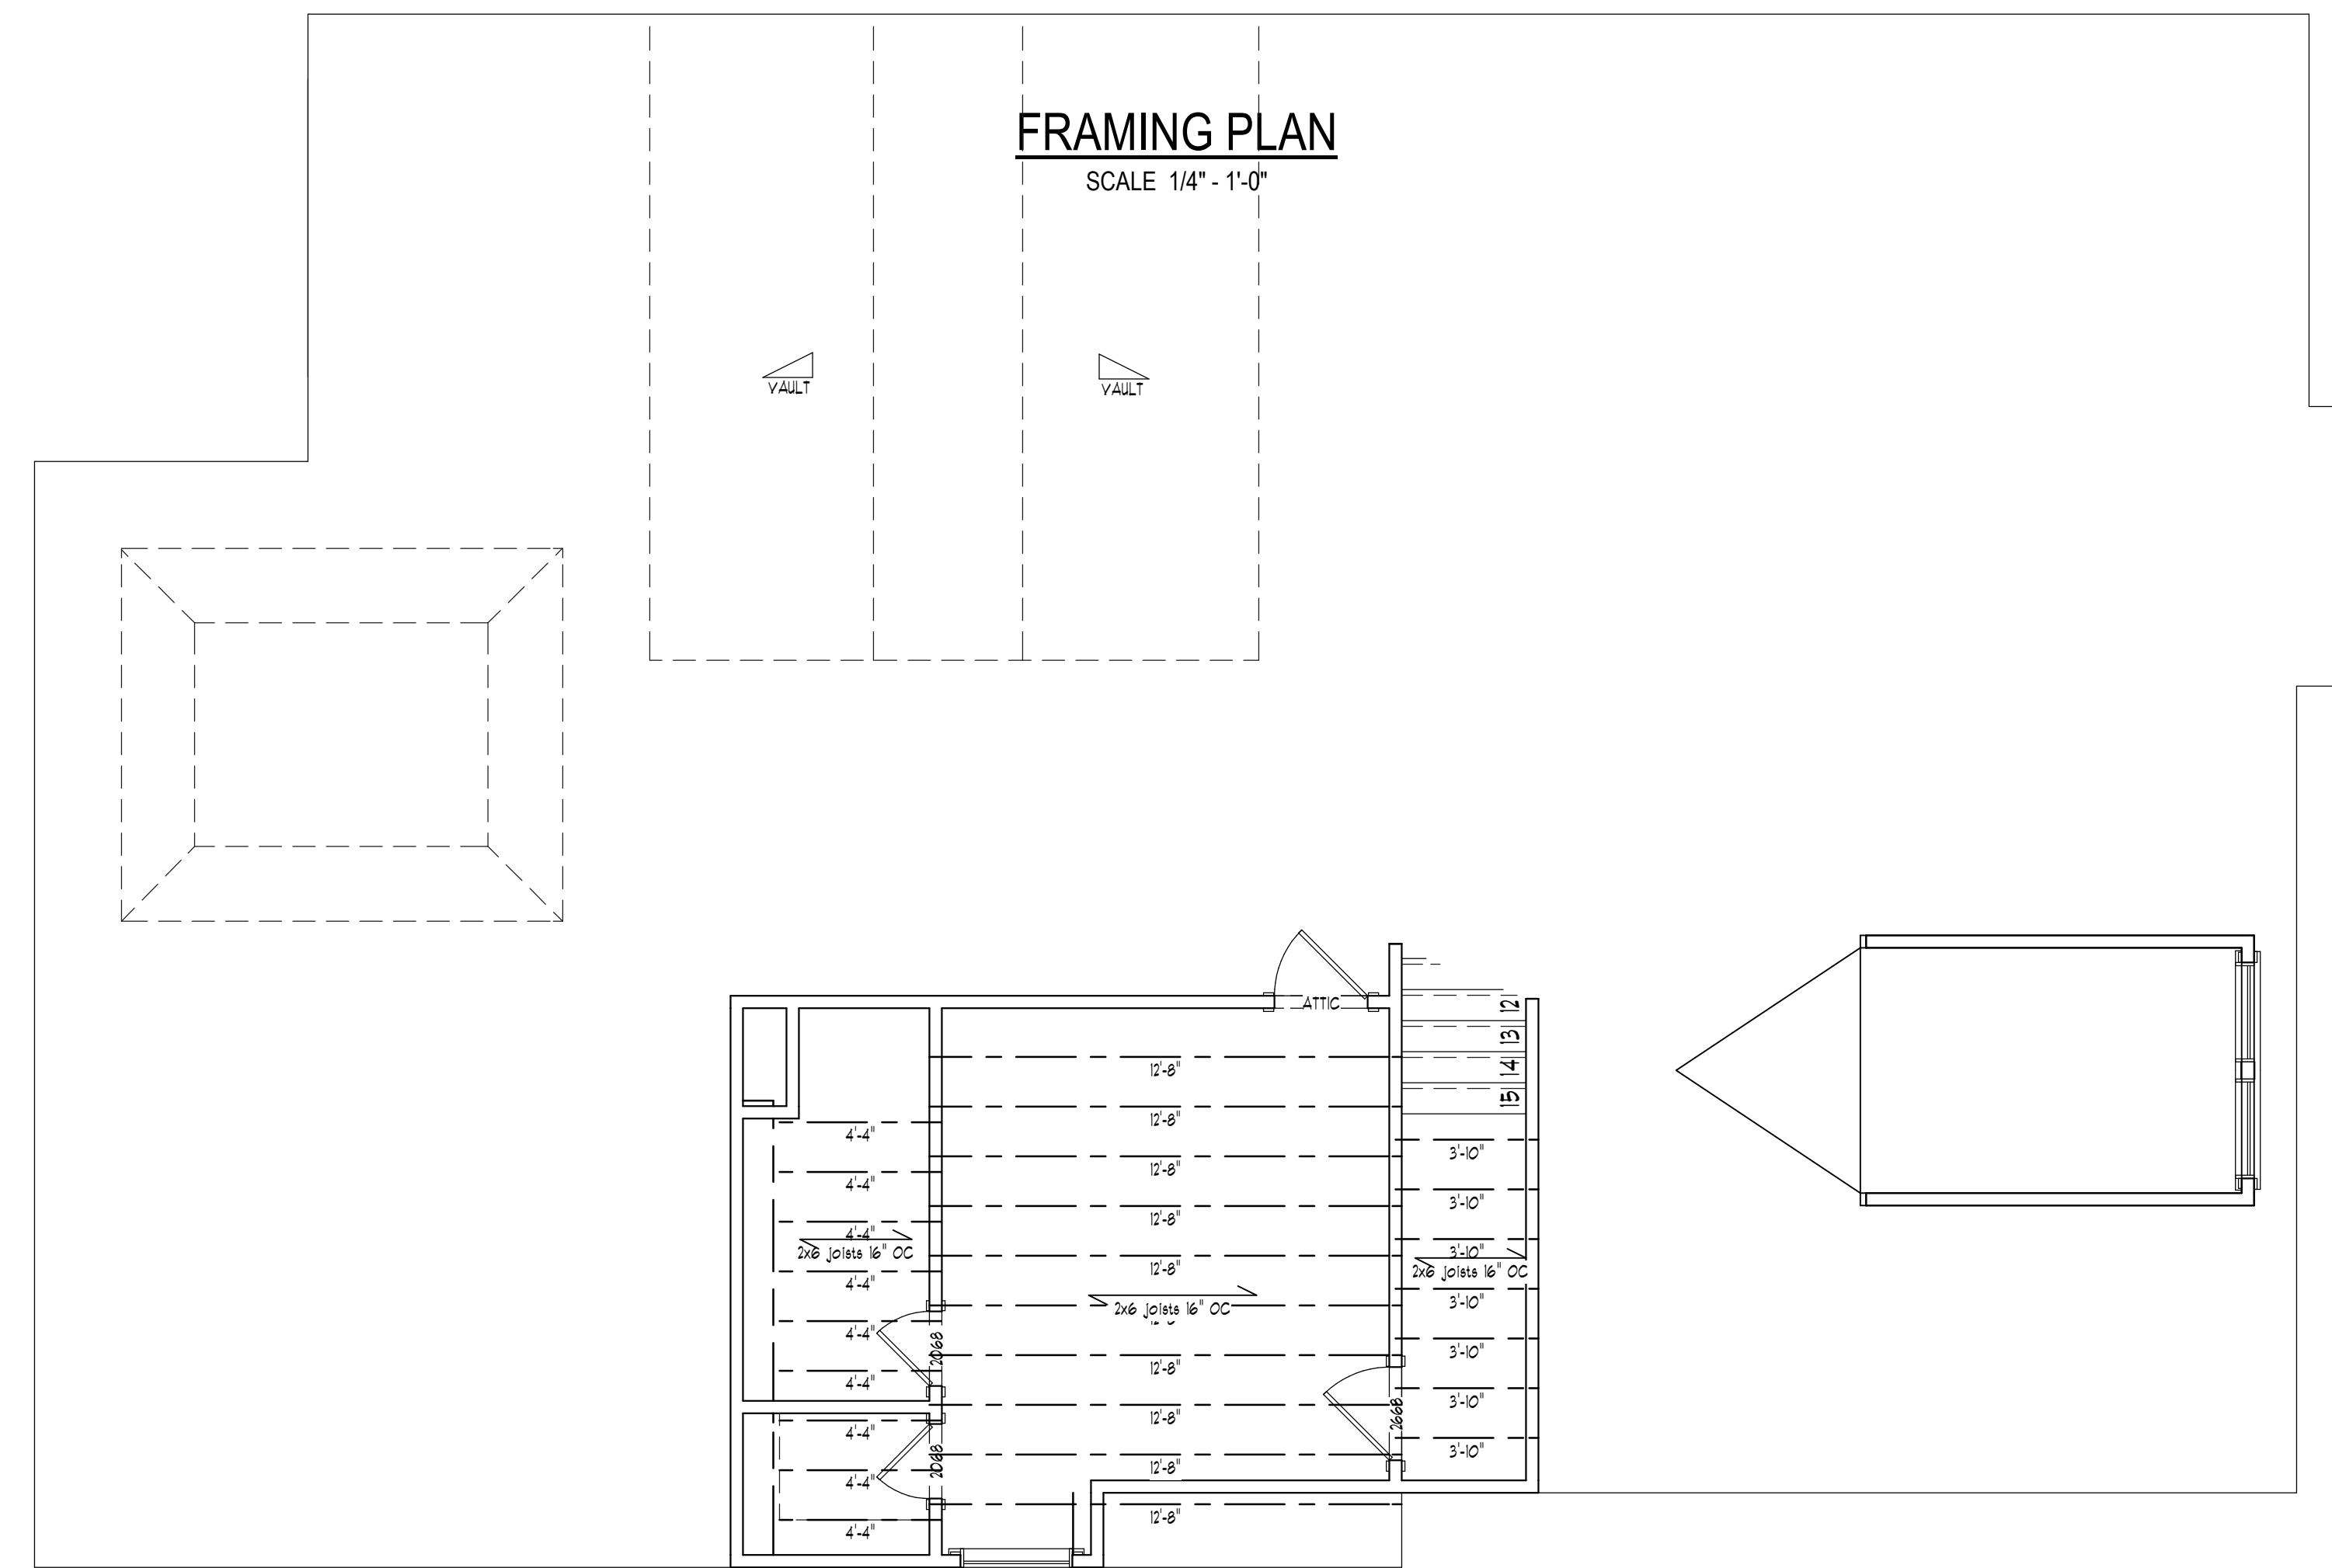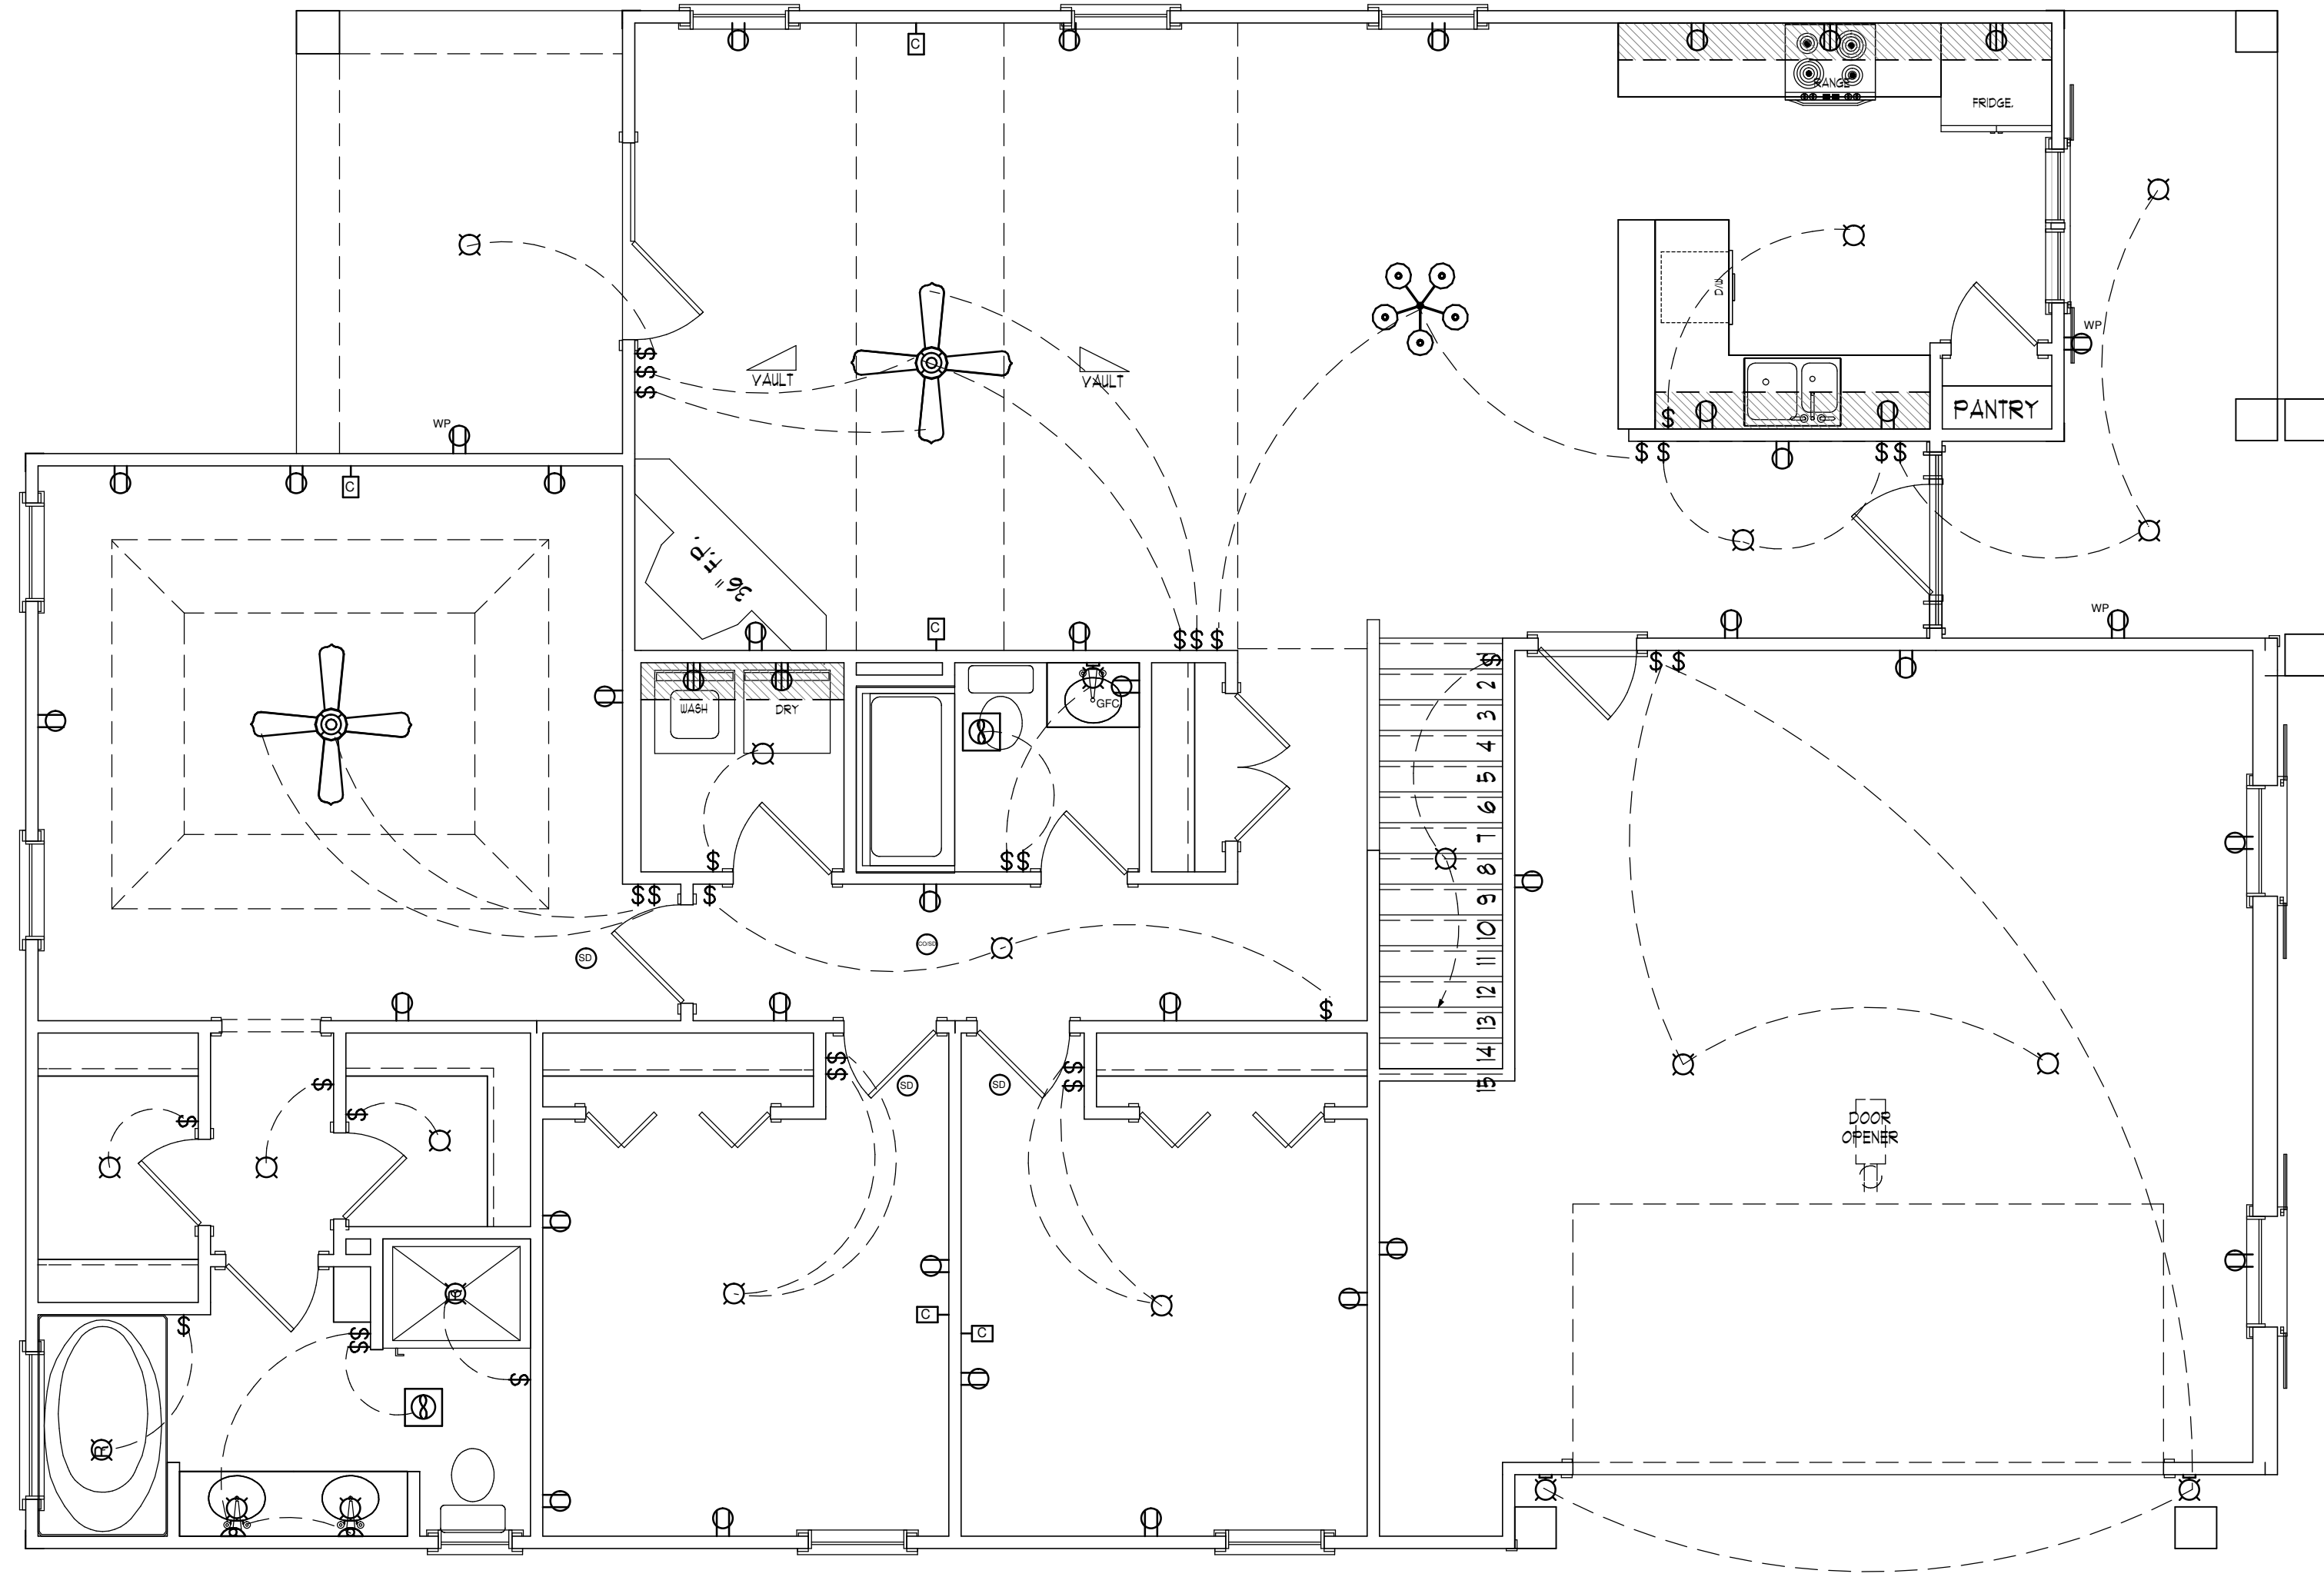

SYMBOL	DESCRIPTION
	CEILING FAN LIGHT
	FLUORESCENT LIGHT FIXTURE
	110V CEILING LIGHT FIXTURE
	110V RECESSED LIGHT FIXTURE
	SINGLE POLE SWITCH
	OUTDOOR SWITCH
	110V DUPLEX RECEPTACLE
	110V DUPLEX RECEPTACLE GROUND FAULT INTERRUPTED
	110V WEATHERPROOF RECEPTACLE W/ WEATHERPROOF COVER
	200V RECEPTACLE
	TELEPHONE JACKS
	TELEVISION JACKS
	SMOKE DETECTOR
	EXHAUST FAN

ELECTRICAL PLAN
SCALE 1/4" = 1'-0"

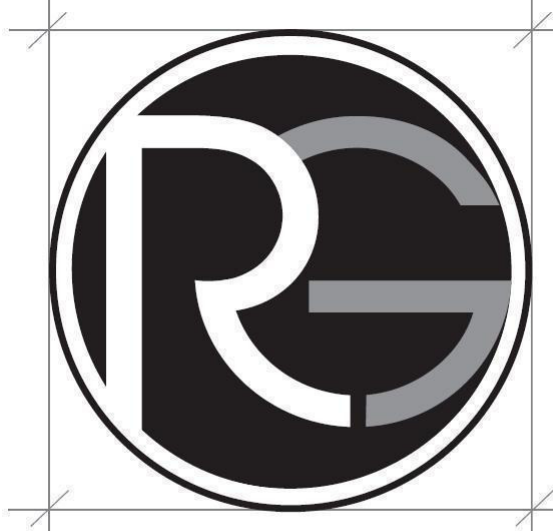

RAY GOOD
CUSTOM HOME DESIGNS

GENERAL NOTES

- DO NOT SCALE DRAWINGS
 - CONTRACTOR SHOULD VERIFY ALL CONDITIONS & DIMENSIONS AT SITE BEFORE BEGINNING CONSTRUCTION.
 - ANY DISCREPANCIES SHOULD BE REPORTED TO RG CUSTOM HOME DESIGNS FOR JUSTIFICATION AND/OR CORRECTIONS BEFORE PROCEEDING WITH WORK.
 - CONTRACTOR SHALL ASSUME ALL RESPONSIBILITY FOR ERRORS THAT ARE NOT REPORTED.
 - ALL WORK SHOULD BE PERFORMED IN ACCORDANCE WITH ALL APPLICABLE INTERNATIONAL BUILDING CODES.
- © RG CUSTOM HOME DESIGNS, INC. 2008

WEAVER
HOMEBUILDERS

CLIENT NAME

"Designers of the 2008 Dream Home"

www.RGoodDesigns.com

427 North Belair Rd.
Evans, G.A. 30809
Cell: 706-267-8555
Office: 706-364-8554
Fax: 706-955-7945

Date Printed: 2/26/2014

Scale:
As Noted

Drawn By:
Gregory Brown

Checked By:
Ray Good

Project Number

1675 A

A-4

Sheet # 4 OF 4