

RAY GOOD
CUSTOM HOME DESIGNS

GENERAL NOTES

- 1) DO NOT SCALE DRAWINGS
- 2) CONTRACTOR SHOULD VERIFY ALL CONDITIONS & DIMENSIONS AT SITE BEFORE BEGINNING CONSTRUCTION.
- 3) ANY DISCREPANCIES SHOULD BE REPORTED TO RG CUSTOM HOME DESIGNS FOR JUSTIFICATION AND/OR CORRECTIONS BEFORE PROCEEDING WITH WORK.
- 4) CONTRACTOR SHALL ASSUME ALL RESPONSIBILITY FOR ERRORS THAT ARE NOT REPORTED.
- 5) ALL WORK SHOULD BE PERFORMED IN ACCORDANCE WITH ALL APPLICABLE INTERNATIONAL BUILDING CODES.

© RAY GOOD CUSTOM HOME DESIGNS, INC. 2013

SPENCER RESIDENCE
CLIENT / COMPANY NAME:
WEAVER HOMEBUILDERS
ADDITIONAL INFO:

Revisions: _____ Date: _____






809-A Oakhurst Dr.
Evans, G.A. 30809
Office: 706-364-8554
Fax: 706-955-7945
Date Printed: 2/15/2016
Scale: as noted

Drawn By:
G.B. R.G. S.S.

Checked By:
Ray Good

Project Number

A-1
Sheet # 1 OF 10

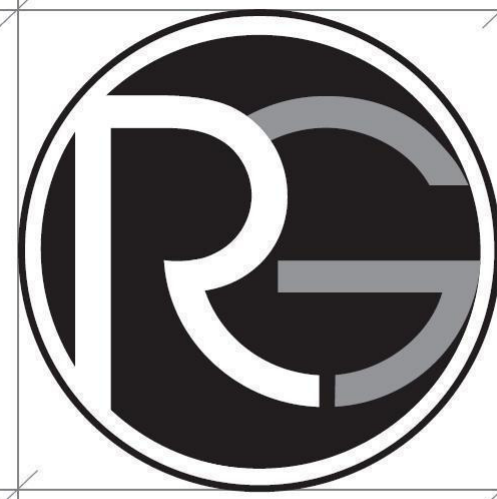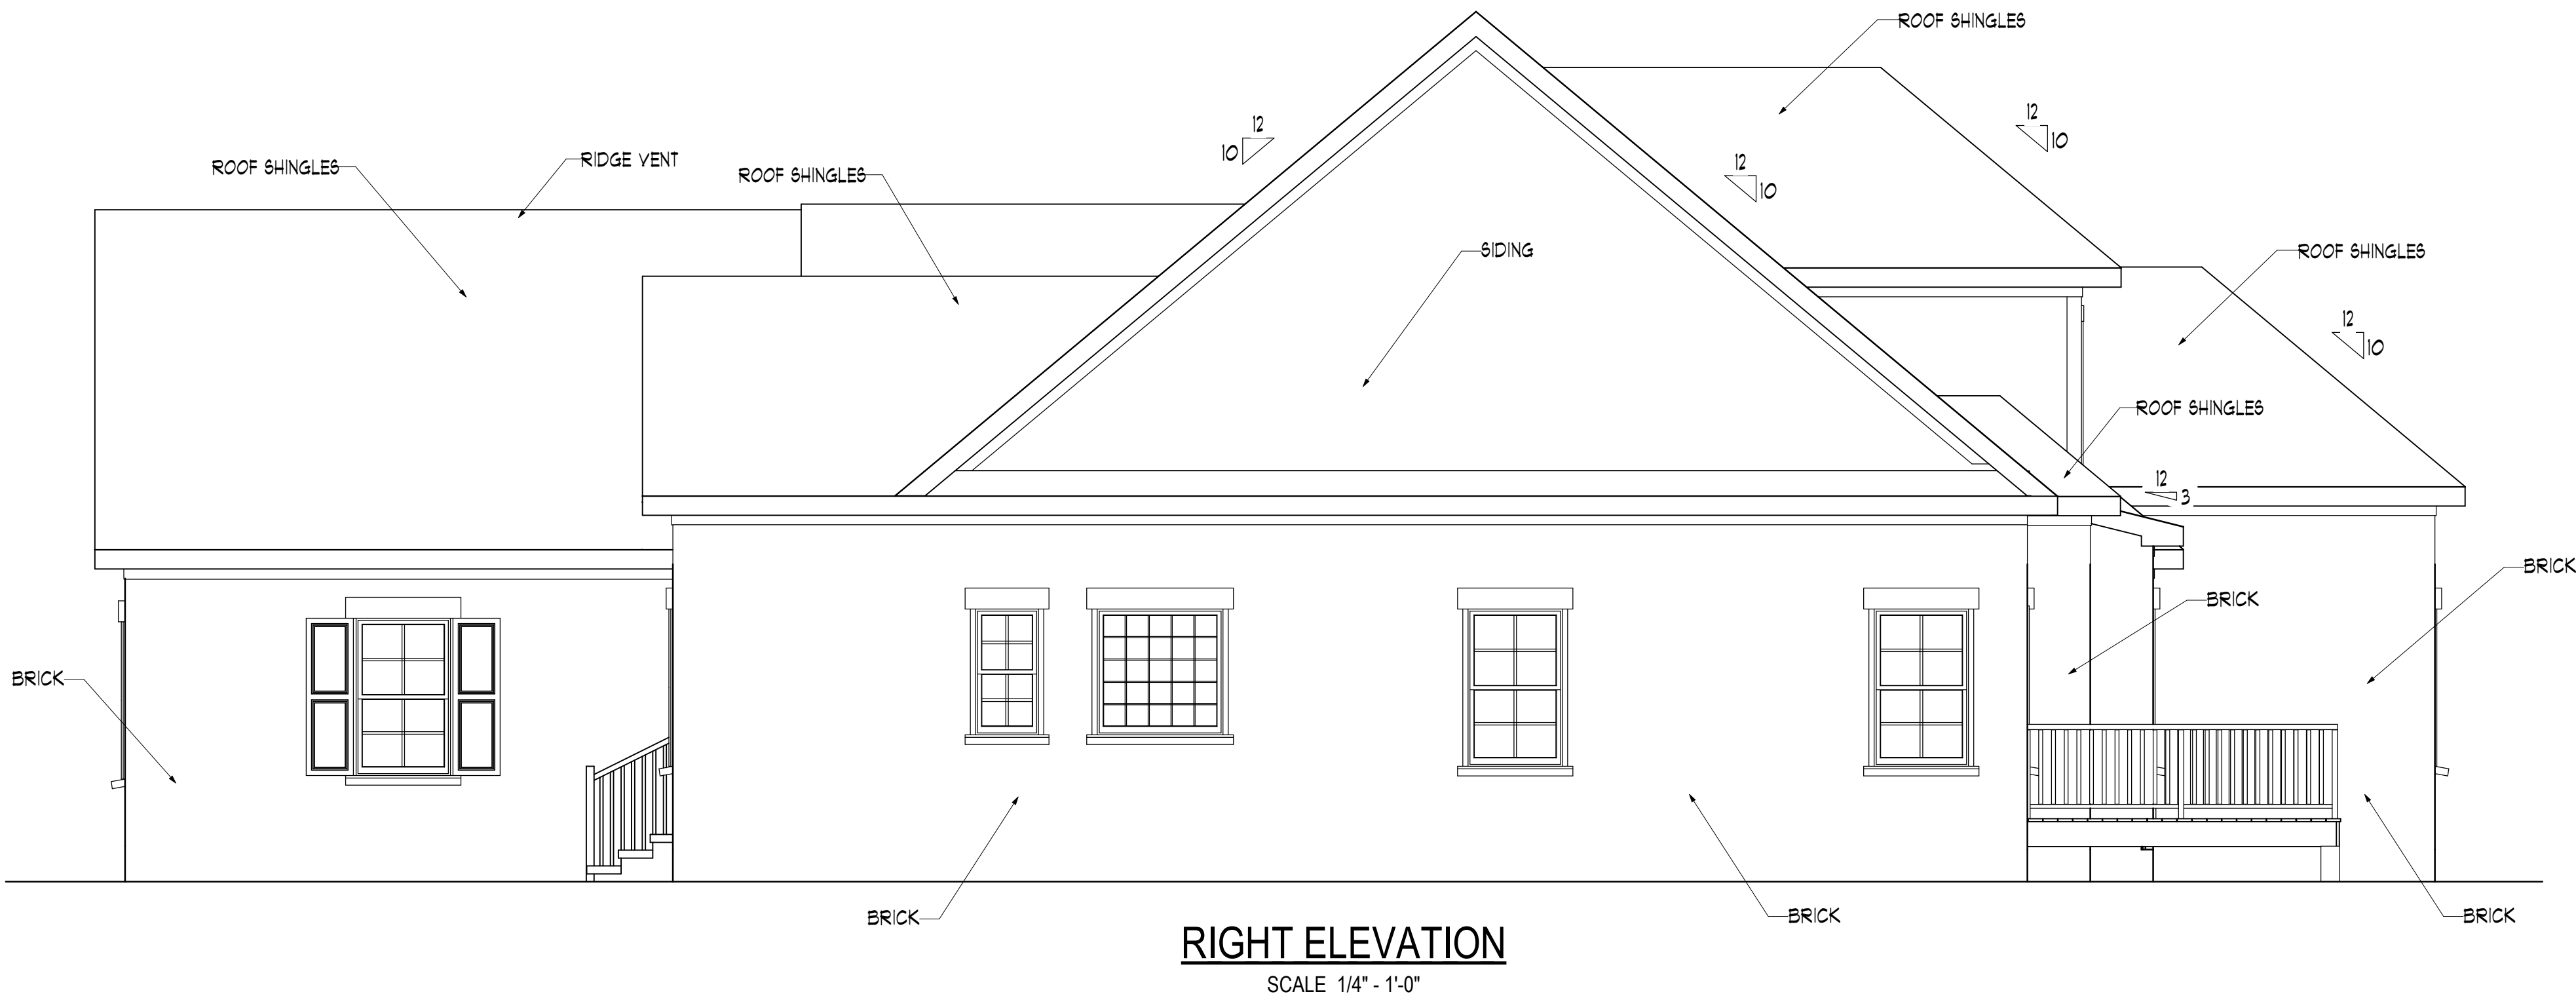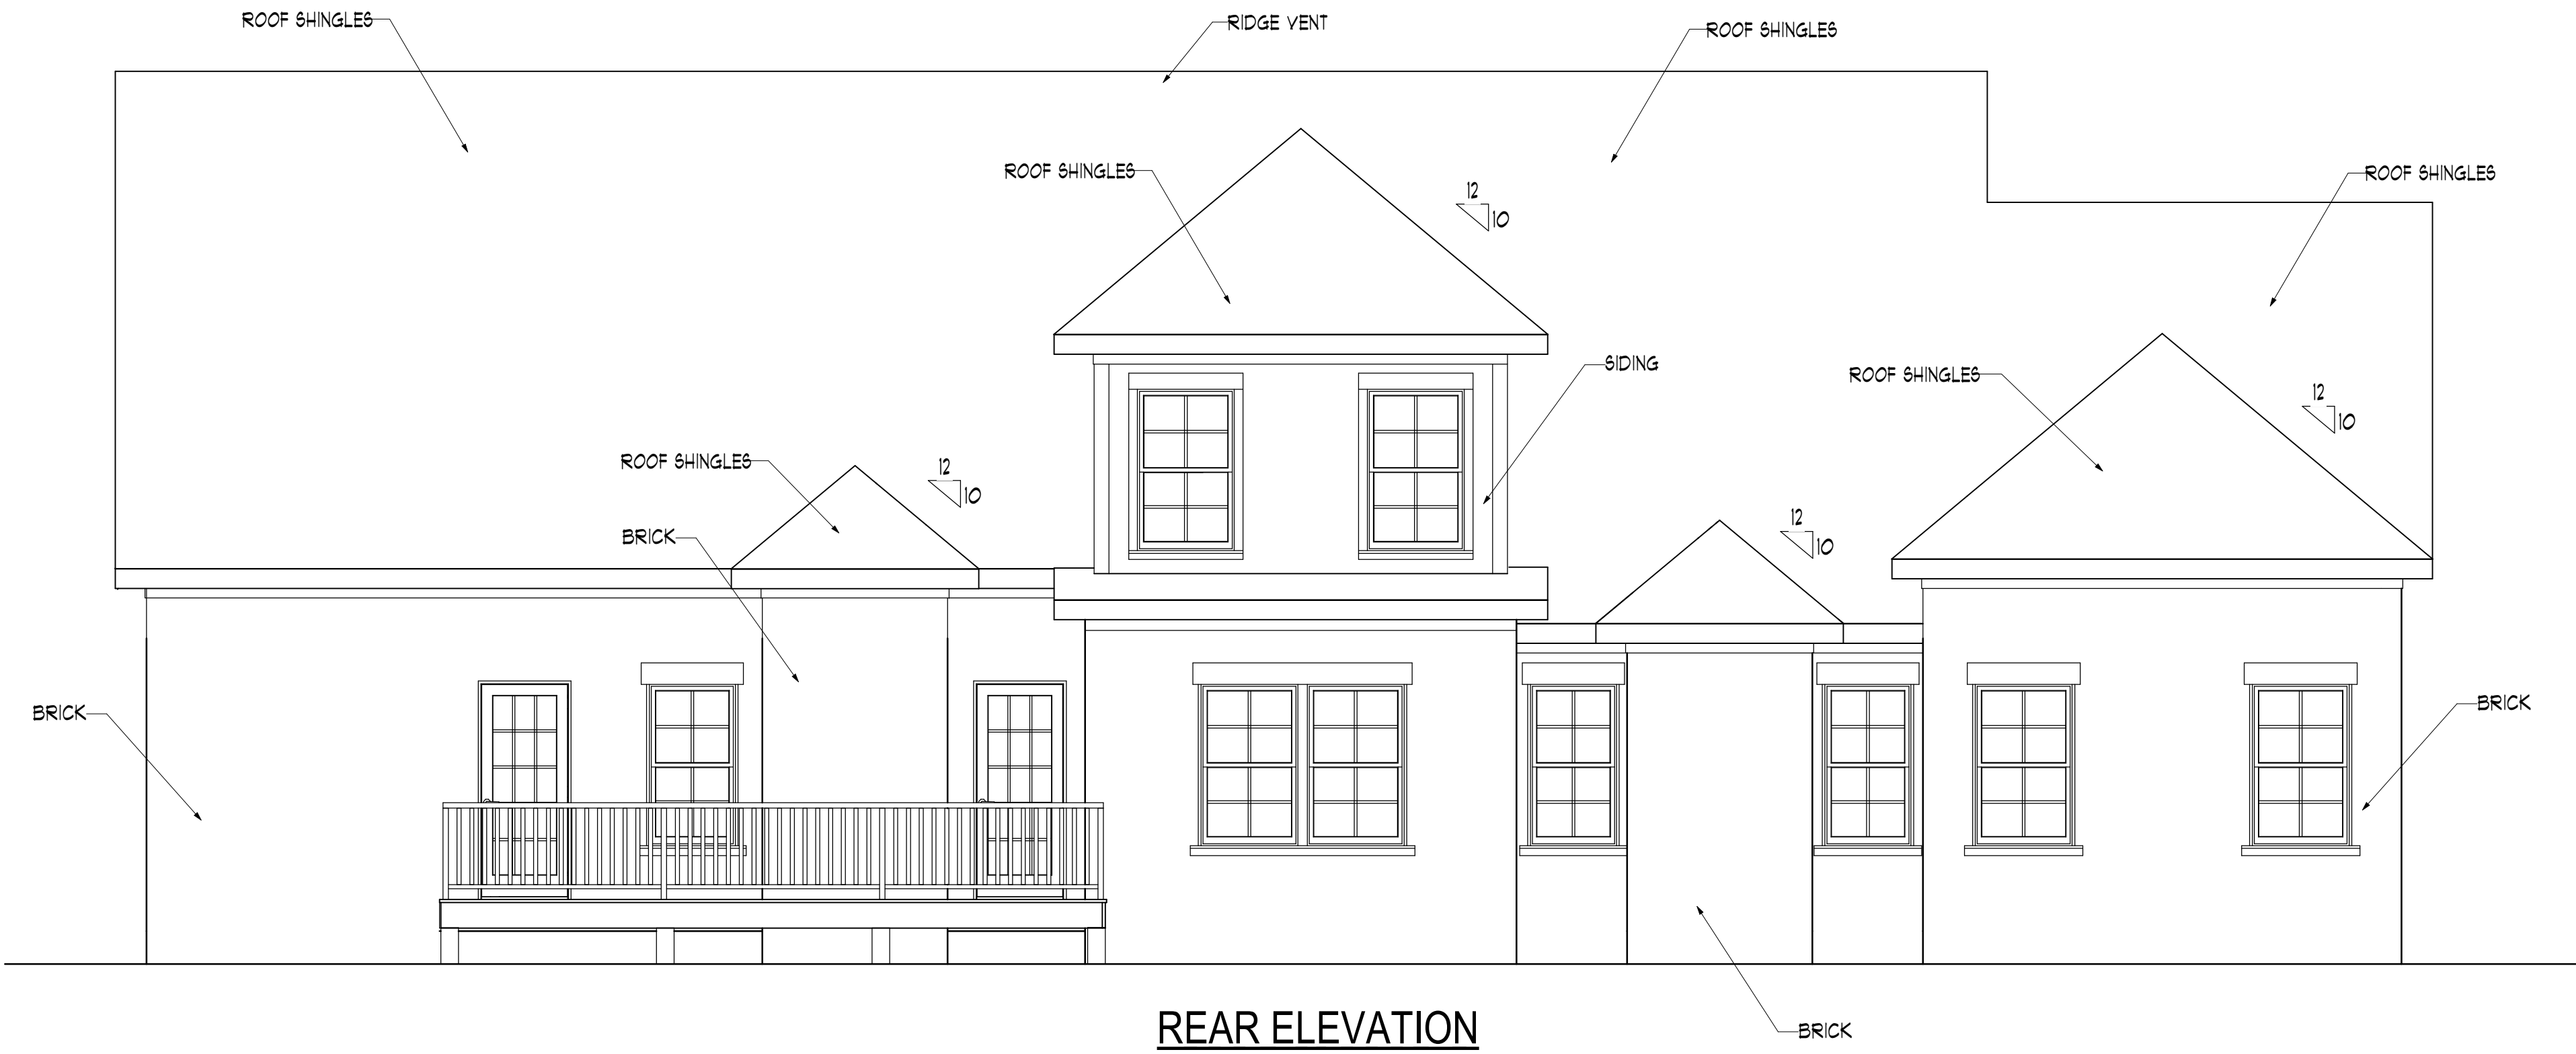

RAY GOOD
CUSTOM HOME DESIGNS

GENERAL NOTES

- 1) DO NOT SCALE DRAWINGS
- 2) CONTRACTOR SHOULD VERIFY ALL CONDITIONS & DIMENSIONS AT SITE BEFORE BEGINNING CONSTRUCTION.
- 3) ANY DISCREPANCIES SHOULD BE REPORTED TO RG CUSTOM HOME DESIGNS FOR JUSTIFICATION AND/OR CORRECTIONS BEFORE PROCEEDING WITH WORK.
- 4) CONTRACTOR SHALL ASSUME ALL RESPONSIBILITY FOR ERRORS THAT ARE NOT REPORTED.
- 5) ALL WORK SHOULD BE PERFORMED IN ACCORDANCE WITH ALL APPLICABLE INTERNATIONAL BUILDING CODES.

© RAY GOOD CUSTOM HOME DESIGNS, INC. 2013

SPENCER RESIDENCE

CLIENT / COMPANY NAME:

WEAVER HOMEBUILDERS

ADDITIONAL INFO:

Revisions: Date:



809-A Oakhurst Dr.
Evans, G.A. 30809

Office: 706-364-8554

Fax: 706-955-7945

Date Printed: 2/15/2016

Scale: as noted

Drawn By:
G.B. R.G. S.S.

Checked By:
Ray Good

Project Number

A-2

Sheet # 2 OF 10




1) DO NOT SCALE DRAWINGS.

- 2) CONTRACTOR SHOULD VERIFY ALL CONDITIONS & DIMENSIONS AT SITE BEFORE BEGINNING CONSTRUCTION
- 3) ANY DISCREPANCIES SHOULD BE REPORTED TO RG CUSTOM HOME DESIGNS FOR JUSTIFICATION AND/OR CORRECTIONS BEFORE PROCEEDING WITH WORK.
- 4) CONTRACTOR SHALL ASSUME ALL RESPONSIBILITY FOR ERRORS THAT ARE NOT REPORTED.
- 5) ALL WORK SHOULD BE PERFORMED IN ACCORDANCE WITH ALL APPLICABLE INTERNATIONAL BUILDING CODES.

© RAY GOOD CUSTOM HOME DESIGNS, INC. 2013


CLIENT / COMPANY NAME:

ADDITIONAL INFO:

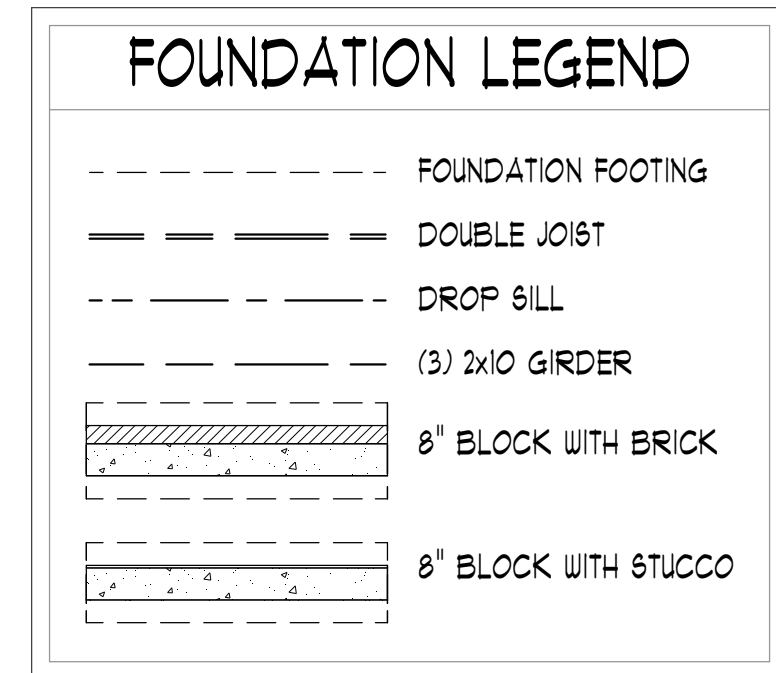

FOUNDATION PLAN
SCALE 1/4" = 1'-0"

 Revisions: Date:




809-A Oakhurst Dr.
Evans, G.A. 30809
Office: 706-364-8554
Fax: 706-955-7945
Date Printed: 2/15/2016
Scale: as noted

Drawn By: G.B. R.G. S.S.
Checked By: Ray Good

Project Number

A-3

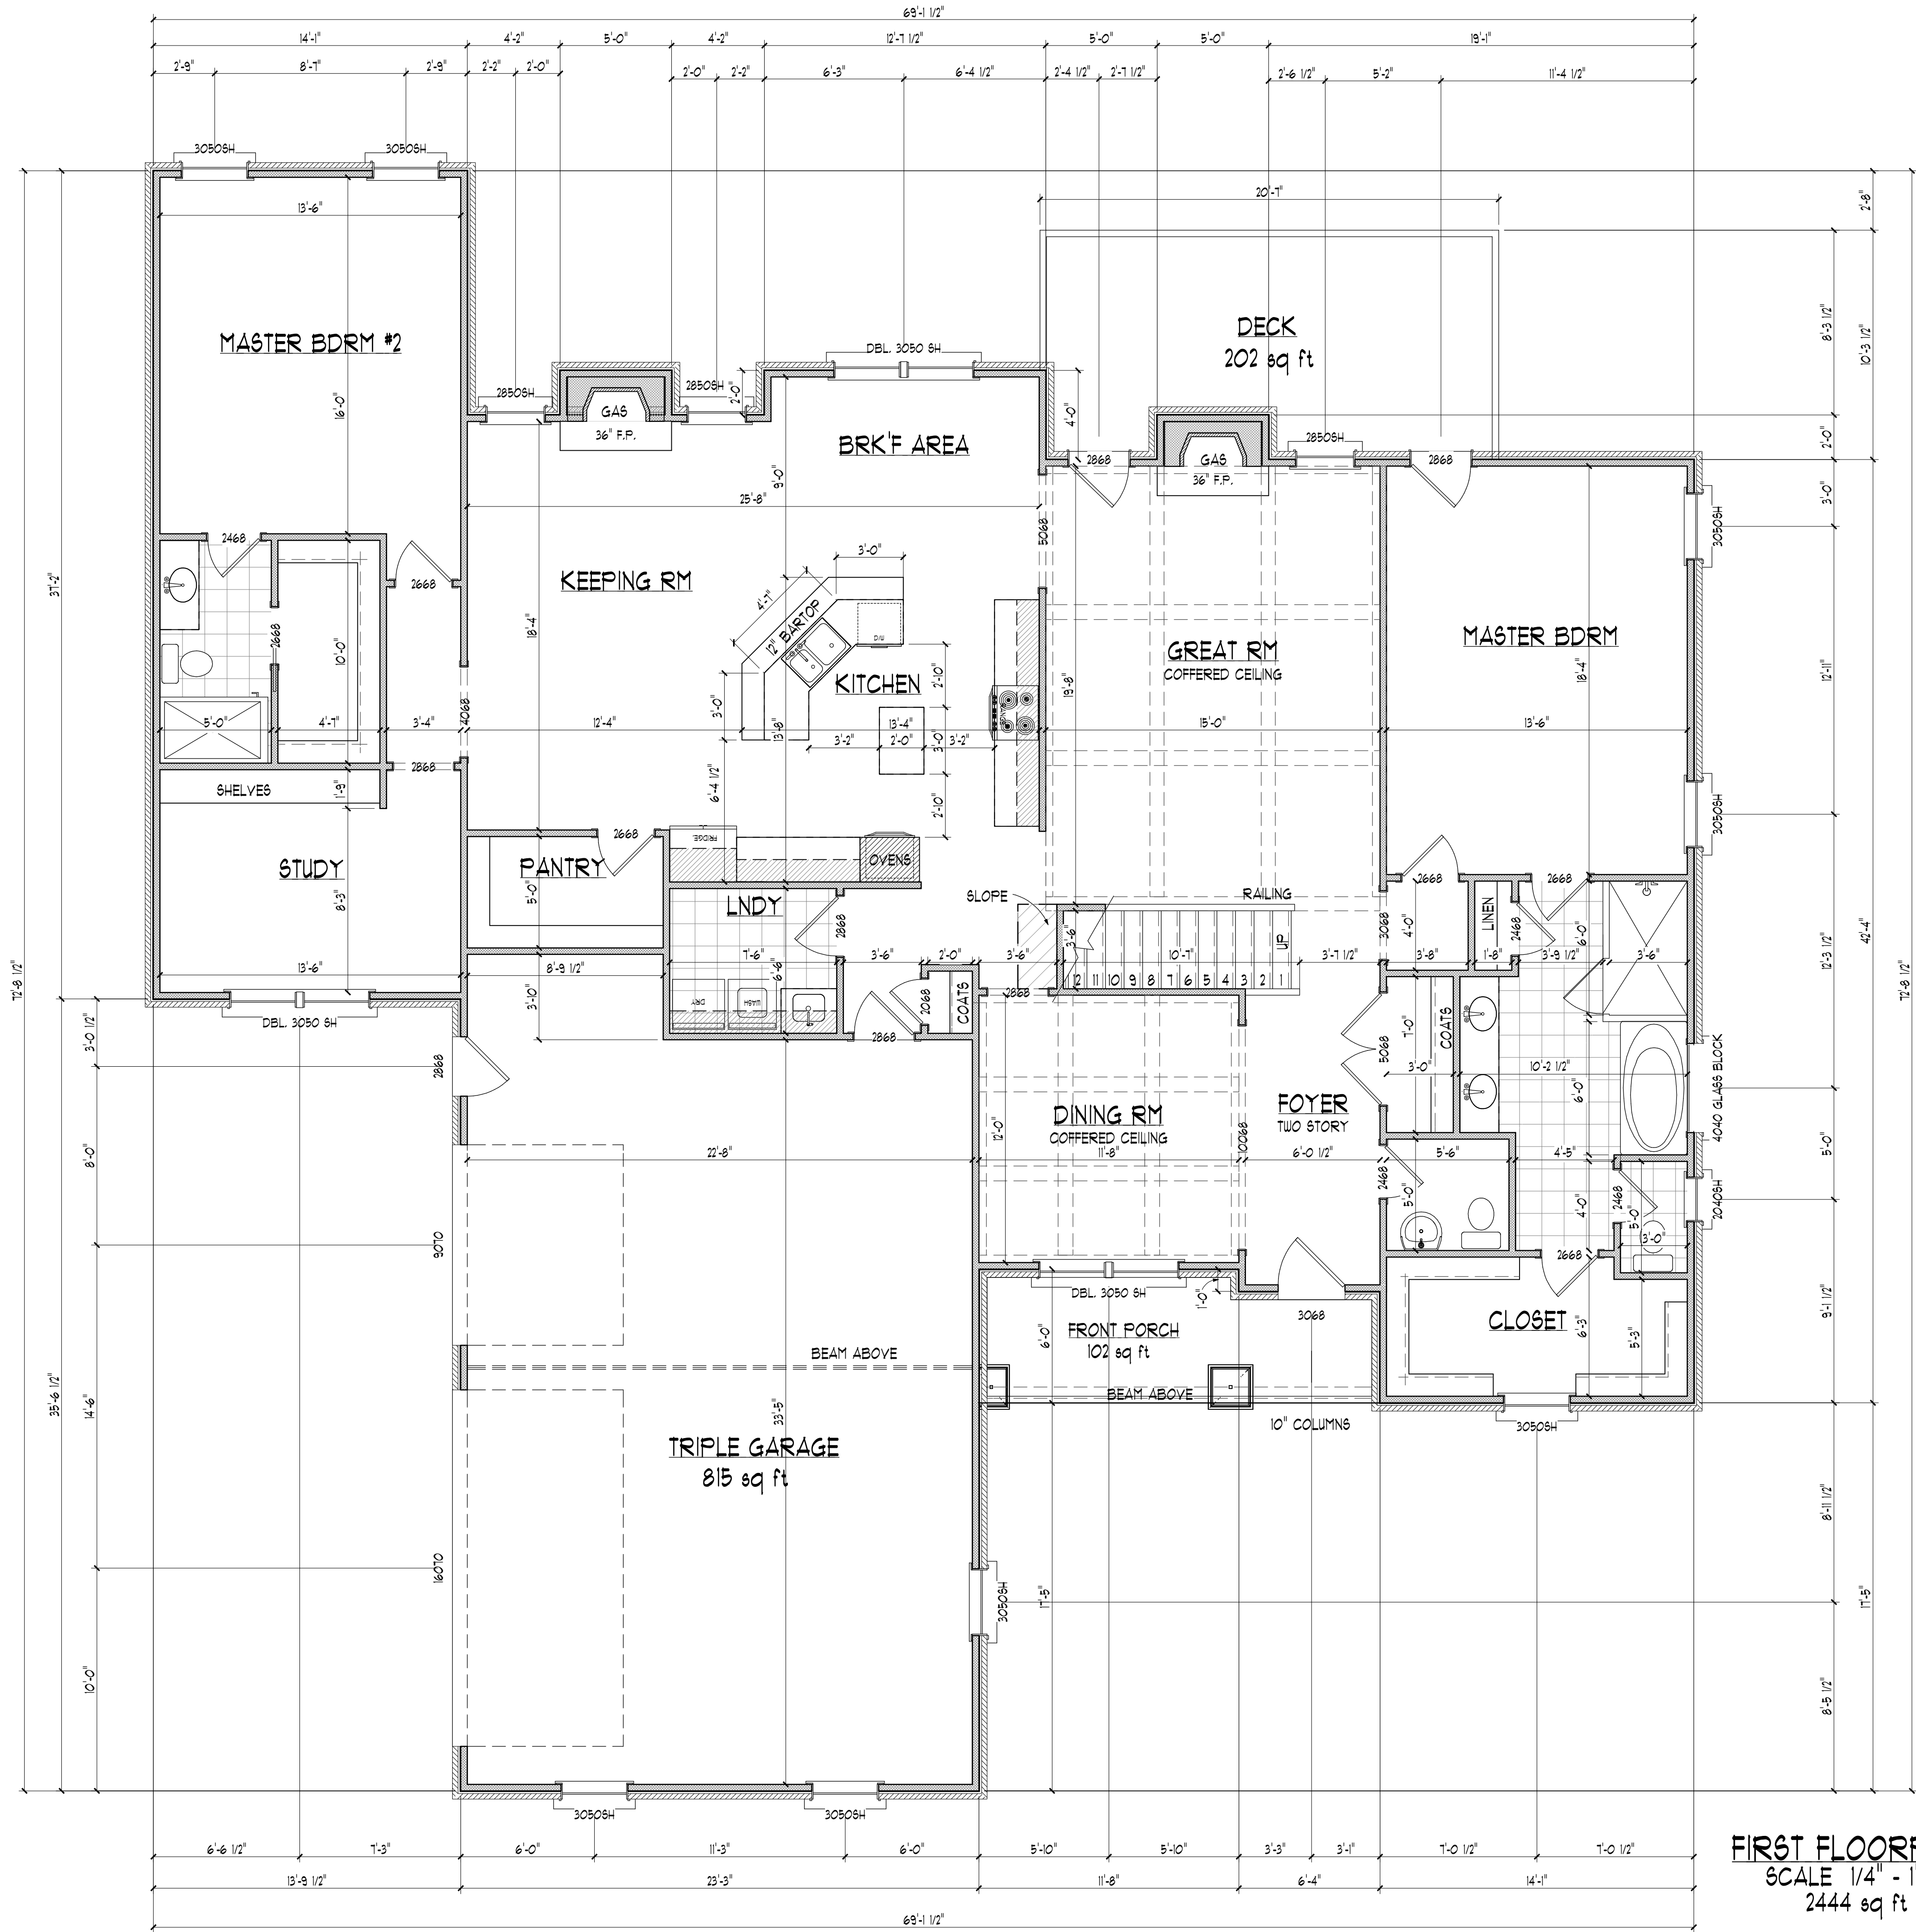


NOTE:
ALL WINDOWS THIS FLOOR @ 8'-0"
HEADER HEIGHT UNLESS NOTED
OTHERWISE

NOTE:
ALL DIMENSIONS ARE TO STUD WALL

NOTE:
BUILDER TO VERIFY ALL WINDOW SIZES FOR
INGRESS / EGRESS REQUIREMENTS

ESTIMATED SQUARE FOOTAGE	
FIRST FLOOR HTD.	2438 SQ. FT.
SECOND FLOOR HTD.	1151 SQ. FT.
TOTAL HTD.	3589 SQ. FT.
FRONT PORCH	102 SQ. FT.
DECK	202 SQ. FT.
GARAGE	821 SQ. FT.
TOTAL	4701 SQ. FT.

Revisions:	Date:
△	
△	
△	
△	
809-A Oakhurst Dr. Evans, G.A. 30809 Office: 706-364-8554 Fax: 706-955-7945 Date Printed: 2/15/2016 Scale: as noted	
Drawn By: G.B. R.G. S.S.	
Checked By: Ray Good	
Project Number	

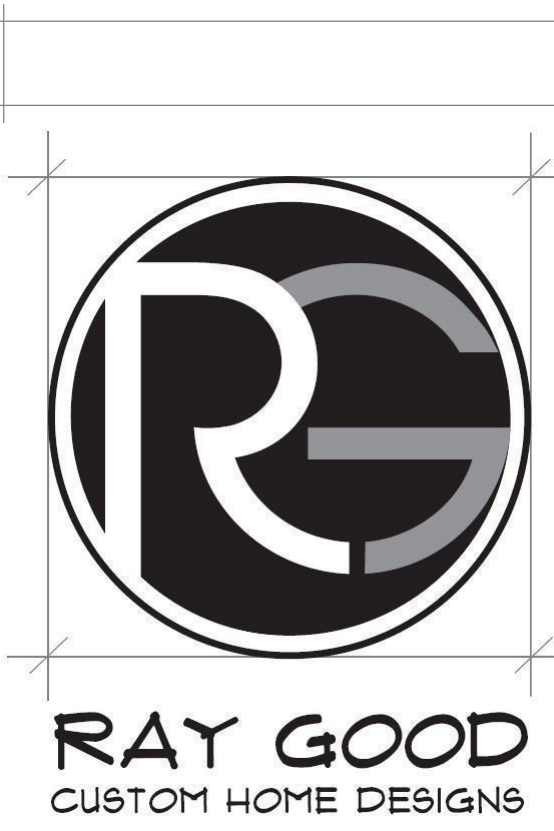



- GENERAL NOTES
- 1) DO NOT SCALE DRAWINGS
 - 2) CONTRACTOR SHOULD VERIFY ALL CONDITIONS & DIMENSIONS AT SITE BEFORE BEGINNING CONSTRUCTION.
 - 3) ANY DISCREPANCIES SHOULD BE REPORTED TO RG CUSTOM HOME DESIGNS FOR JUSTIFICATION AND/OR CORRECTIONS BEFORE PROCEEDING WITH WORK.
 - 4) CONTRACTOR SHALL ASSUME ALL RESPONSIBILITY FOR ERRORS THAT ARE NOT REPORTED.
 - 5) ALL WORK SHOULD BE PERFORMED IN ACCORDANCE WITH ALL APPLICABLE INTERNATIONAL BUILDING CODES.
- © RAY GOOD CUSTOM HOME DESIGNS, INC. 2013

SPENCER RESIDENCE

CLIENT / COMPANY NAME:

WEAVER HOMEBUILDERS

ADDITIONAL INFO:

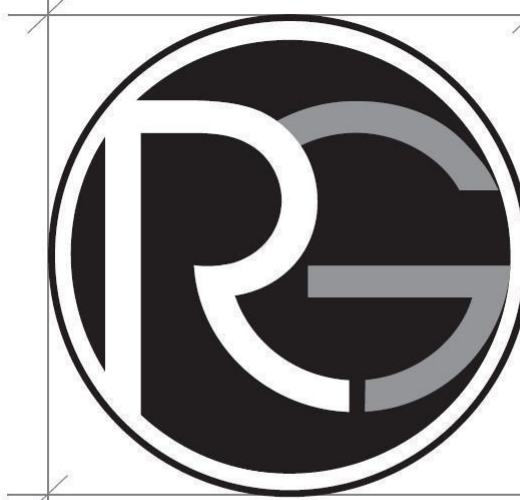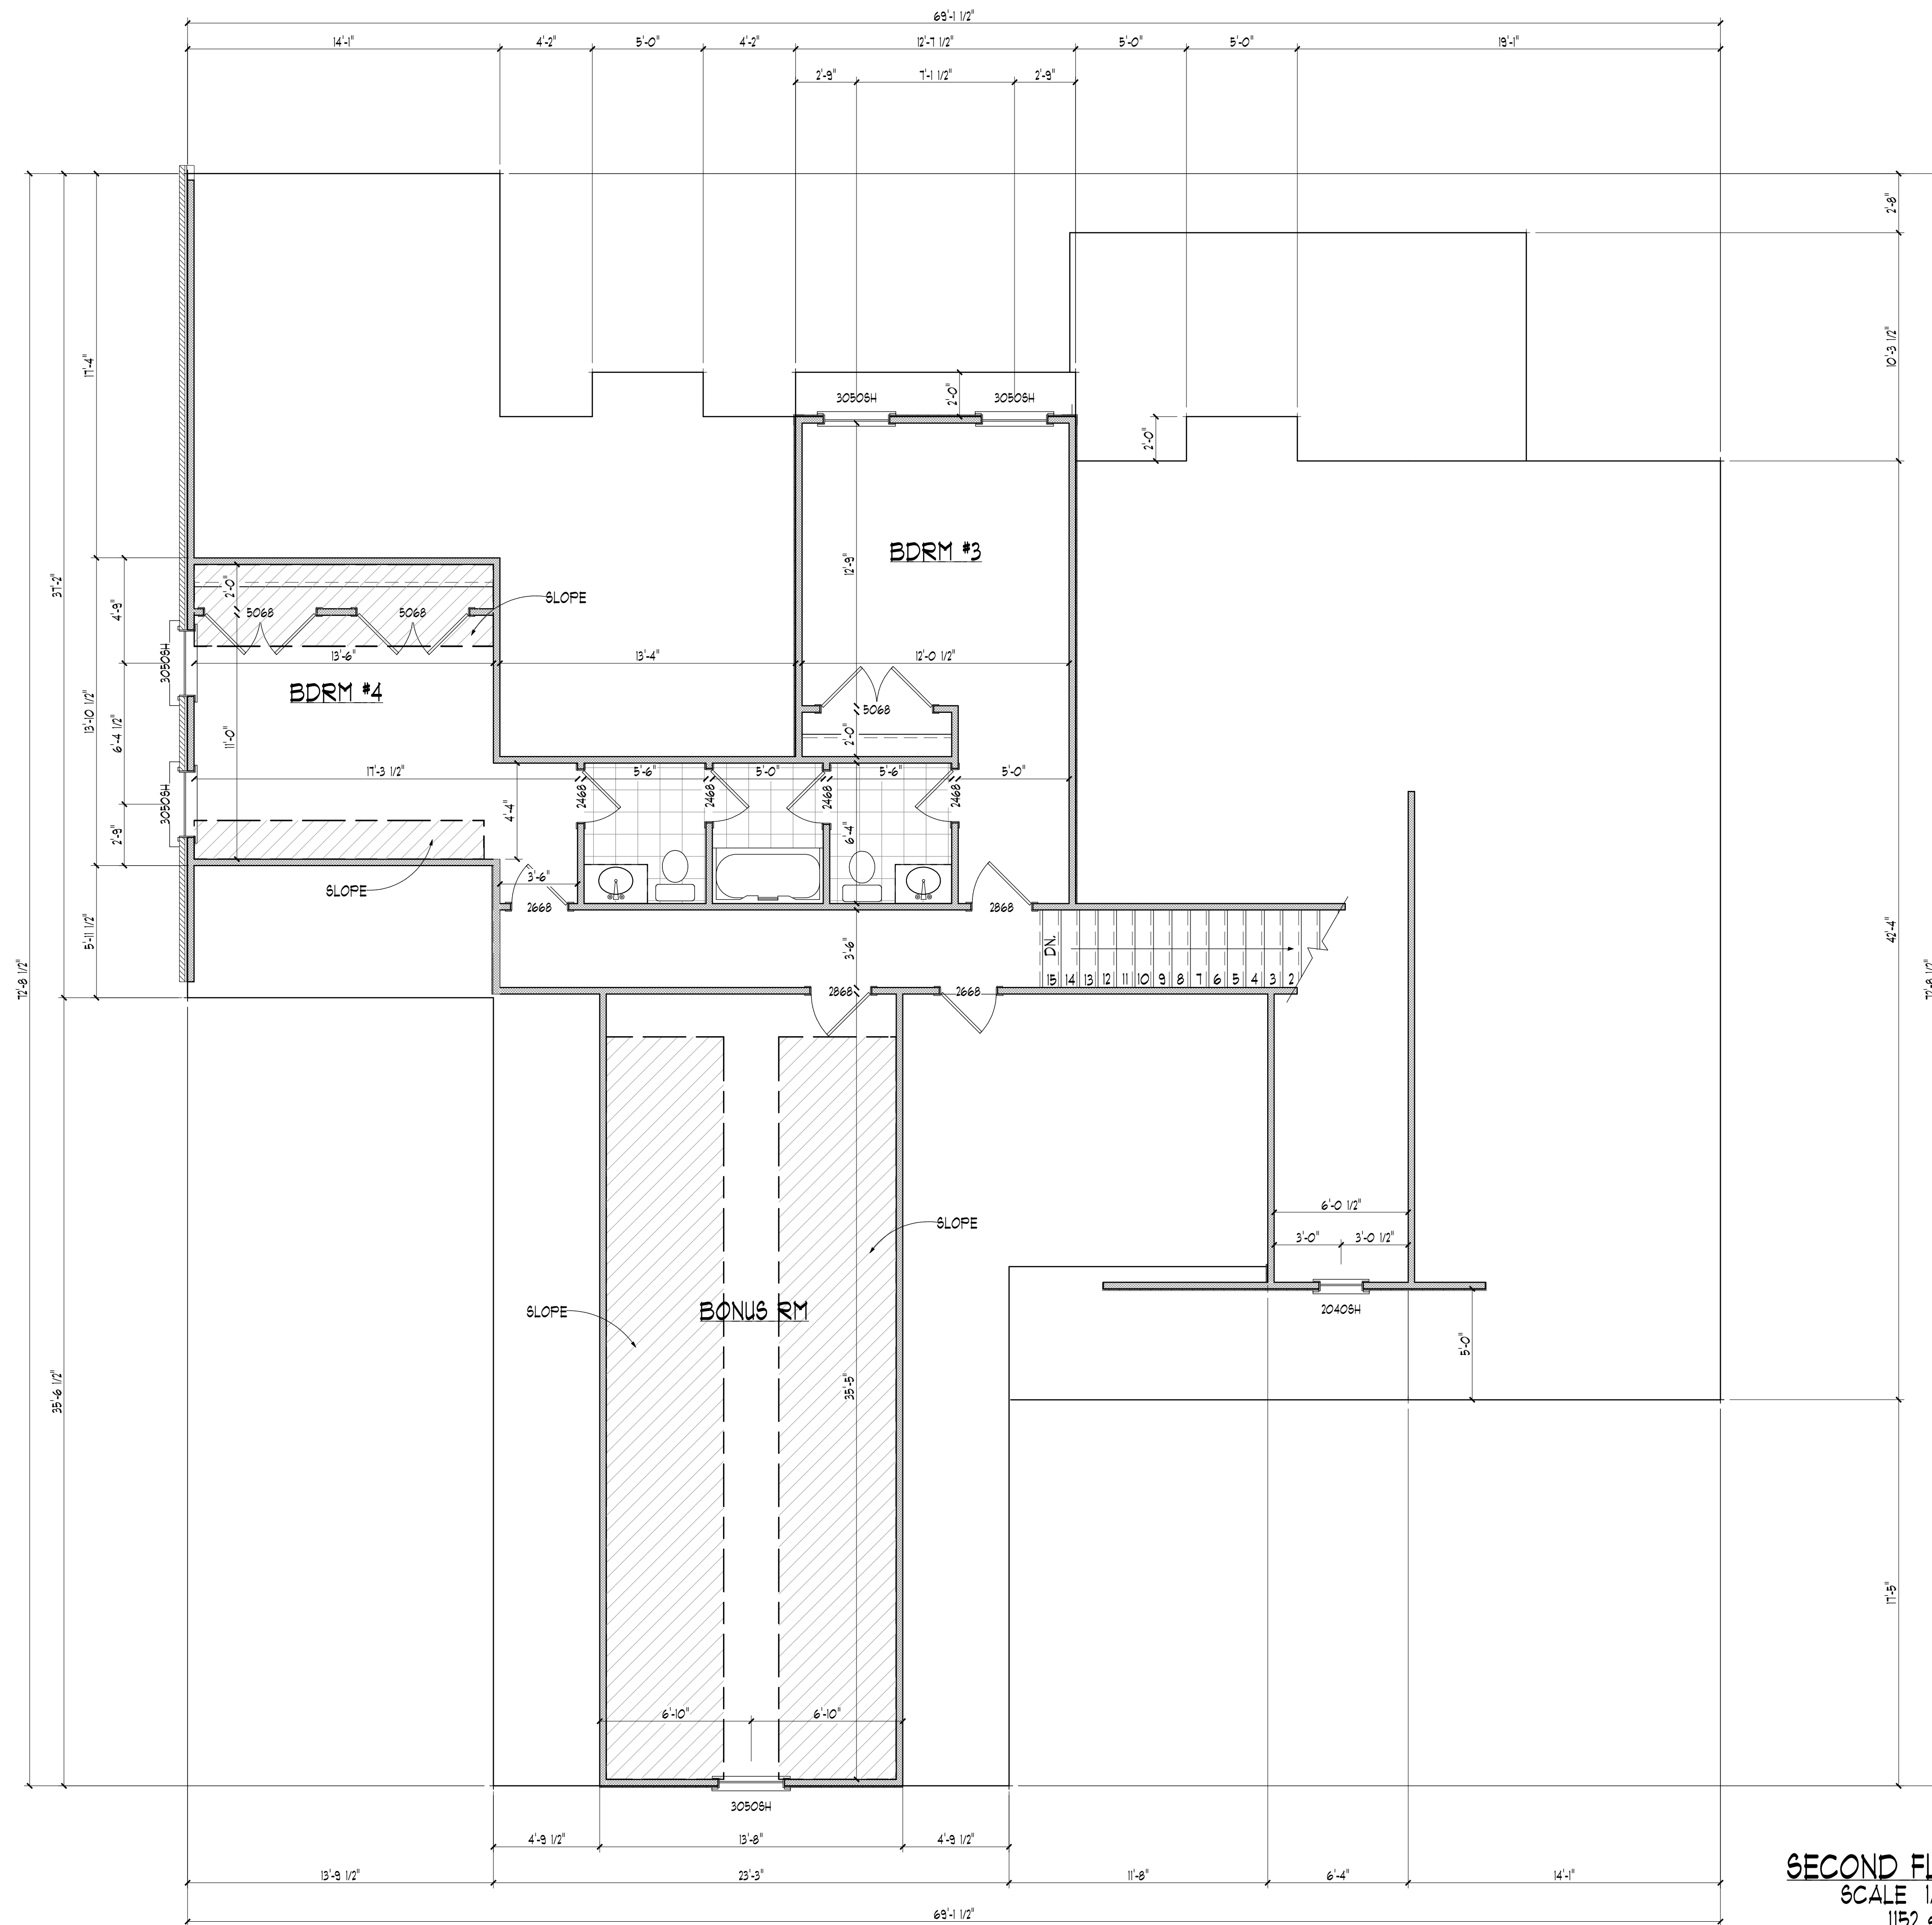

GENERAL NOTES

- D) DO NOT SCALE DRAWINGS.
- 2) CONTRACTOR SHOULD VERIFY ALL CONDITIONS & DIMENSIONS AT SITE BEFORE BEGINNING CONSTRUCTION.
- 3) ANY DISCREPANCIES SHOULD BE REPORTED TO RC CUSTOM HOME DESIGNER FOR JUSTIFICATION AND/OR CORRECTIONS BEFORE PROCEEDING WITH WORK.
- 4) CONTRACTOR SHALL ASSUME ALL RESPONSIBILITY FOR ERRORS THAT ARE NOT REPORTED.
- 5) ALL WORK SHOULD BE PERFORMED IN ACCORDANCE WITH ALL APPLICABLE INTERNATIONAL BUILDING CODES.

© RAY GOOD CUSTOM HOME DESIGNS, INC. 2013

 
SPENCER RESIDENCE

CLIENT / COMPANY NAME: _____

WEAVER HOMEBUILDERS

ADDITIONAL INFO:

Revisions: Date:



809-A Oakhurst Dr.
Evans, G.A. 30809
Office: 706-364-8554
Fax: 706-955-7945

Date Printed: 2/15/2016
Scale: as noted

Drawn By:
G.B. R.G. S.S.


Checked By:
Ray Good

Project Number

— **////**

A-5

Sheet # 5 OF 10

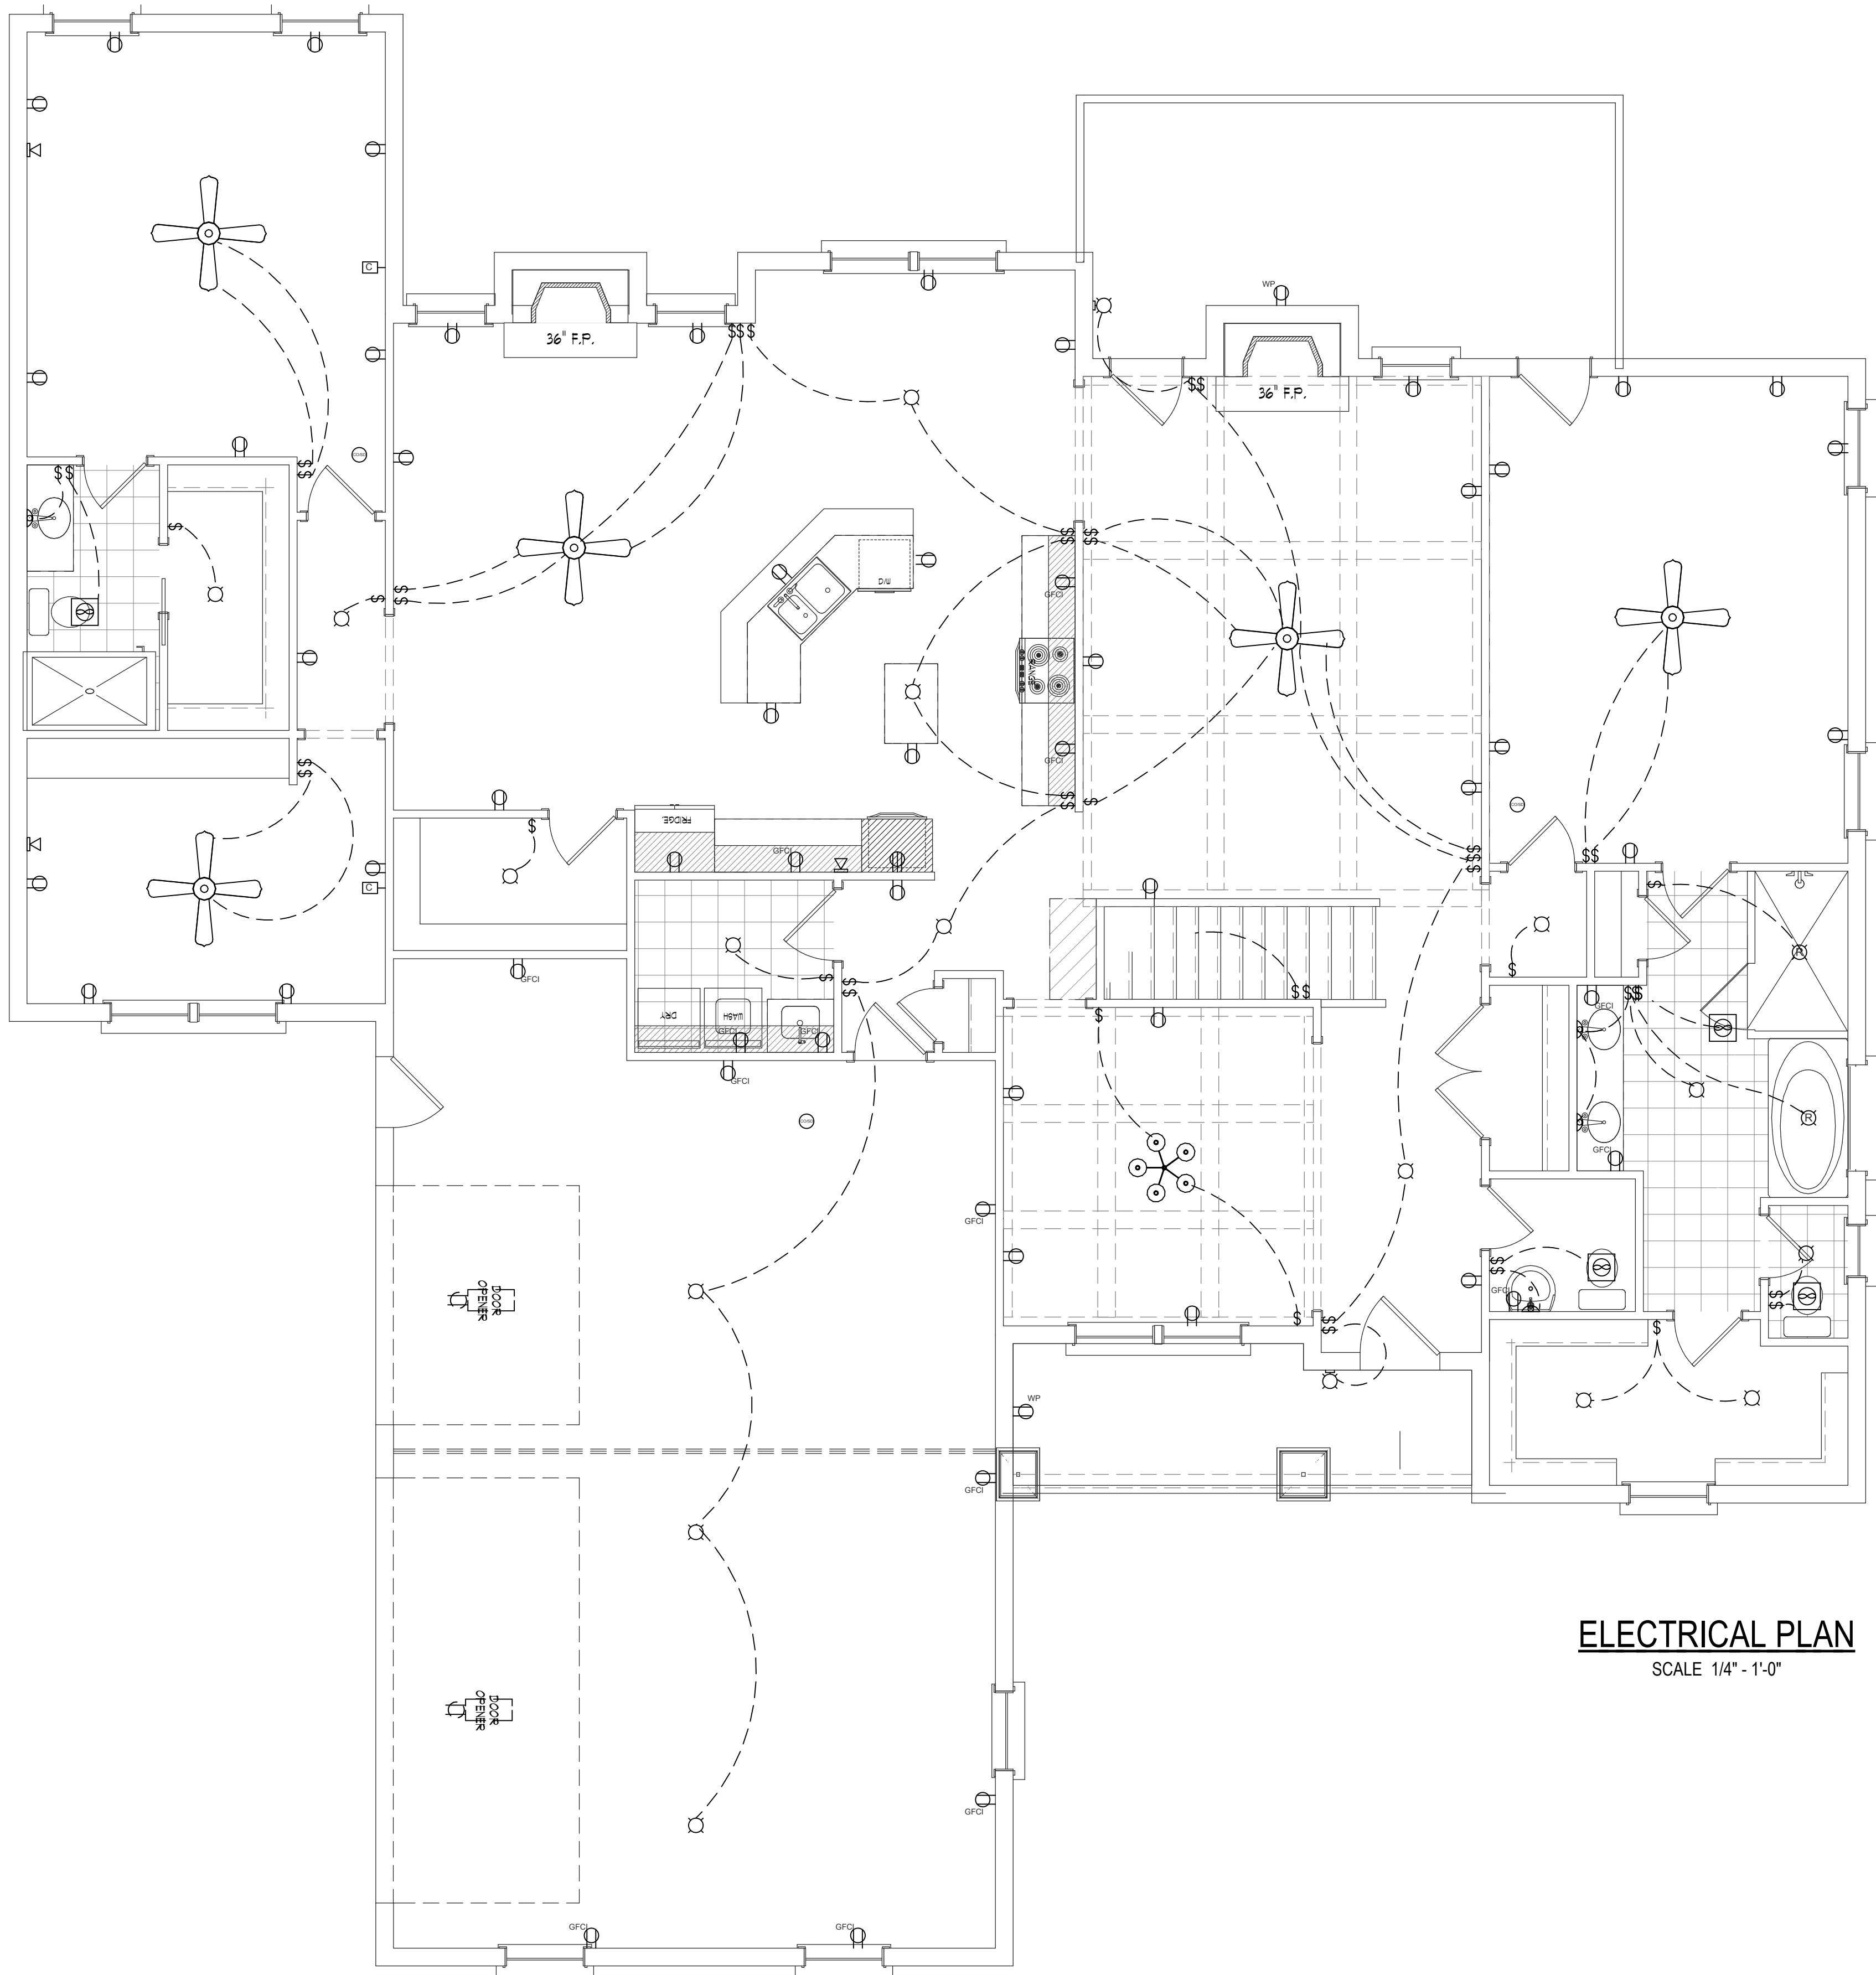

ELECTRICAL PLAN
SCALE 1/4" = 1'-0"

ELECTRICAL LEGEND			
SYMBOL	DESCRIPTION	SYMBOL	DESCRIPTION
	CEILING FAN W/ LIGHT		EXHAUST FAN
	FLUORESCENT LIGHT FIXTURE		110V DUPLEX RECEPTACLE
	CHANDELIER LIGHTING		110V DUPLEX RECEPTACLE GROUND FAULT INTERRUPTED
	PENDANT LIGHTING		110V DUPLEX RECEPTACLE W/ WEATHERPROOF COVER
	110V CEILING LIGHT FIXTURE		240V RECEPTACLE
	110V RECESSED LIGHT FIXTURE		TELEPHONE JACKS
	SINGLE POLE SWITCH		TELEVISION JACKS
	OUTDOOR SWITCH		SMOKE DETECTOR



RAY GOOD
CUSTOM HOME DESIGNS

GENERAL NOTES

- 1) DO NOT SCALE DRAWINGS
- 2) CONTRACTOR SHOULD VERIFY ALL CONDITIONS & DIMENSIONS AT SITE BEFORE BEGINNING CONSTRUCTION.
- 3) ANY DISCREPANCIES SHOULD BE REPORTED TO RG CUSTOM HOME DESIGNS FOR JUSTIFICATION AND/ OR CORRECTIONS BEFORE PROCEEDING WITH WORK.
- 4) CONTRACTOR SHALL ASSUME ALL RESPONSIBILITY FOR ERRORS THAT ARE NOT REPORTED.
- 5) ALL WORK SHOULD BE PERFORMED IN ACCORDANCE WITH ALL APPLICABLE INTERNATIONAL BUILDING CODES.

© RAY GOOD CUSTOM HOME DESIGNS, INC. 2013

SPENCER RESIDENCE

CLIENT / COMPANY NAME:

WEAVER HOMEBUILDERS

ADDITIONAL INFO:

Revisions: Date:

- △
- △
- △
- △

809-A Oakhurst Dr.
Evans, G.A. 30809
Office: 706-364-8554
Fax: 706-955-7945
Date Printed: 2/15/2016
Scale: as noted

Drawn By:
G.B. R.G. S.S.


Checked By:
Ray Good

Project Number

- - - - -

A-6

Sheet # 6 OF 10

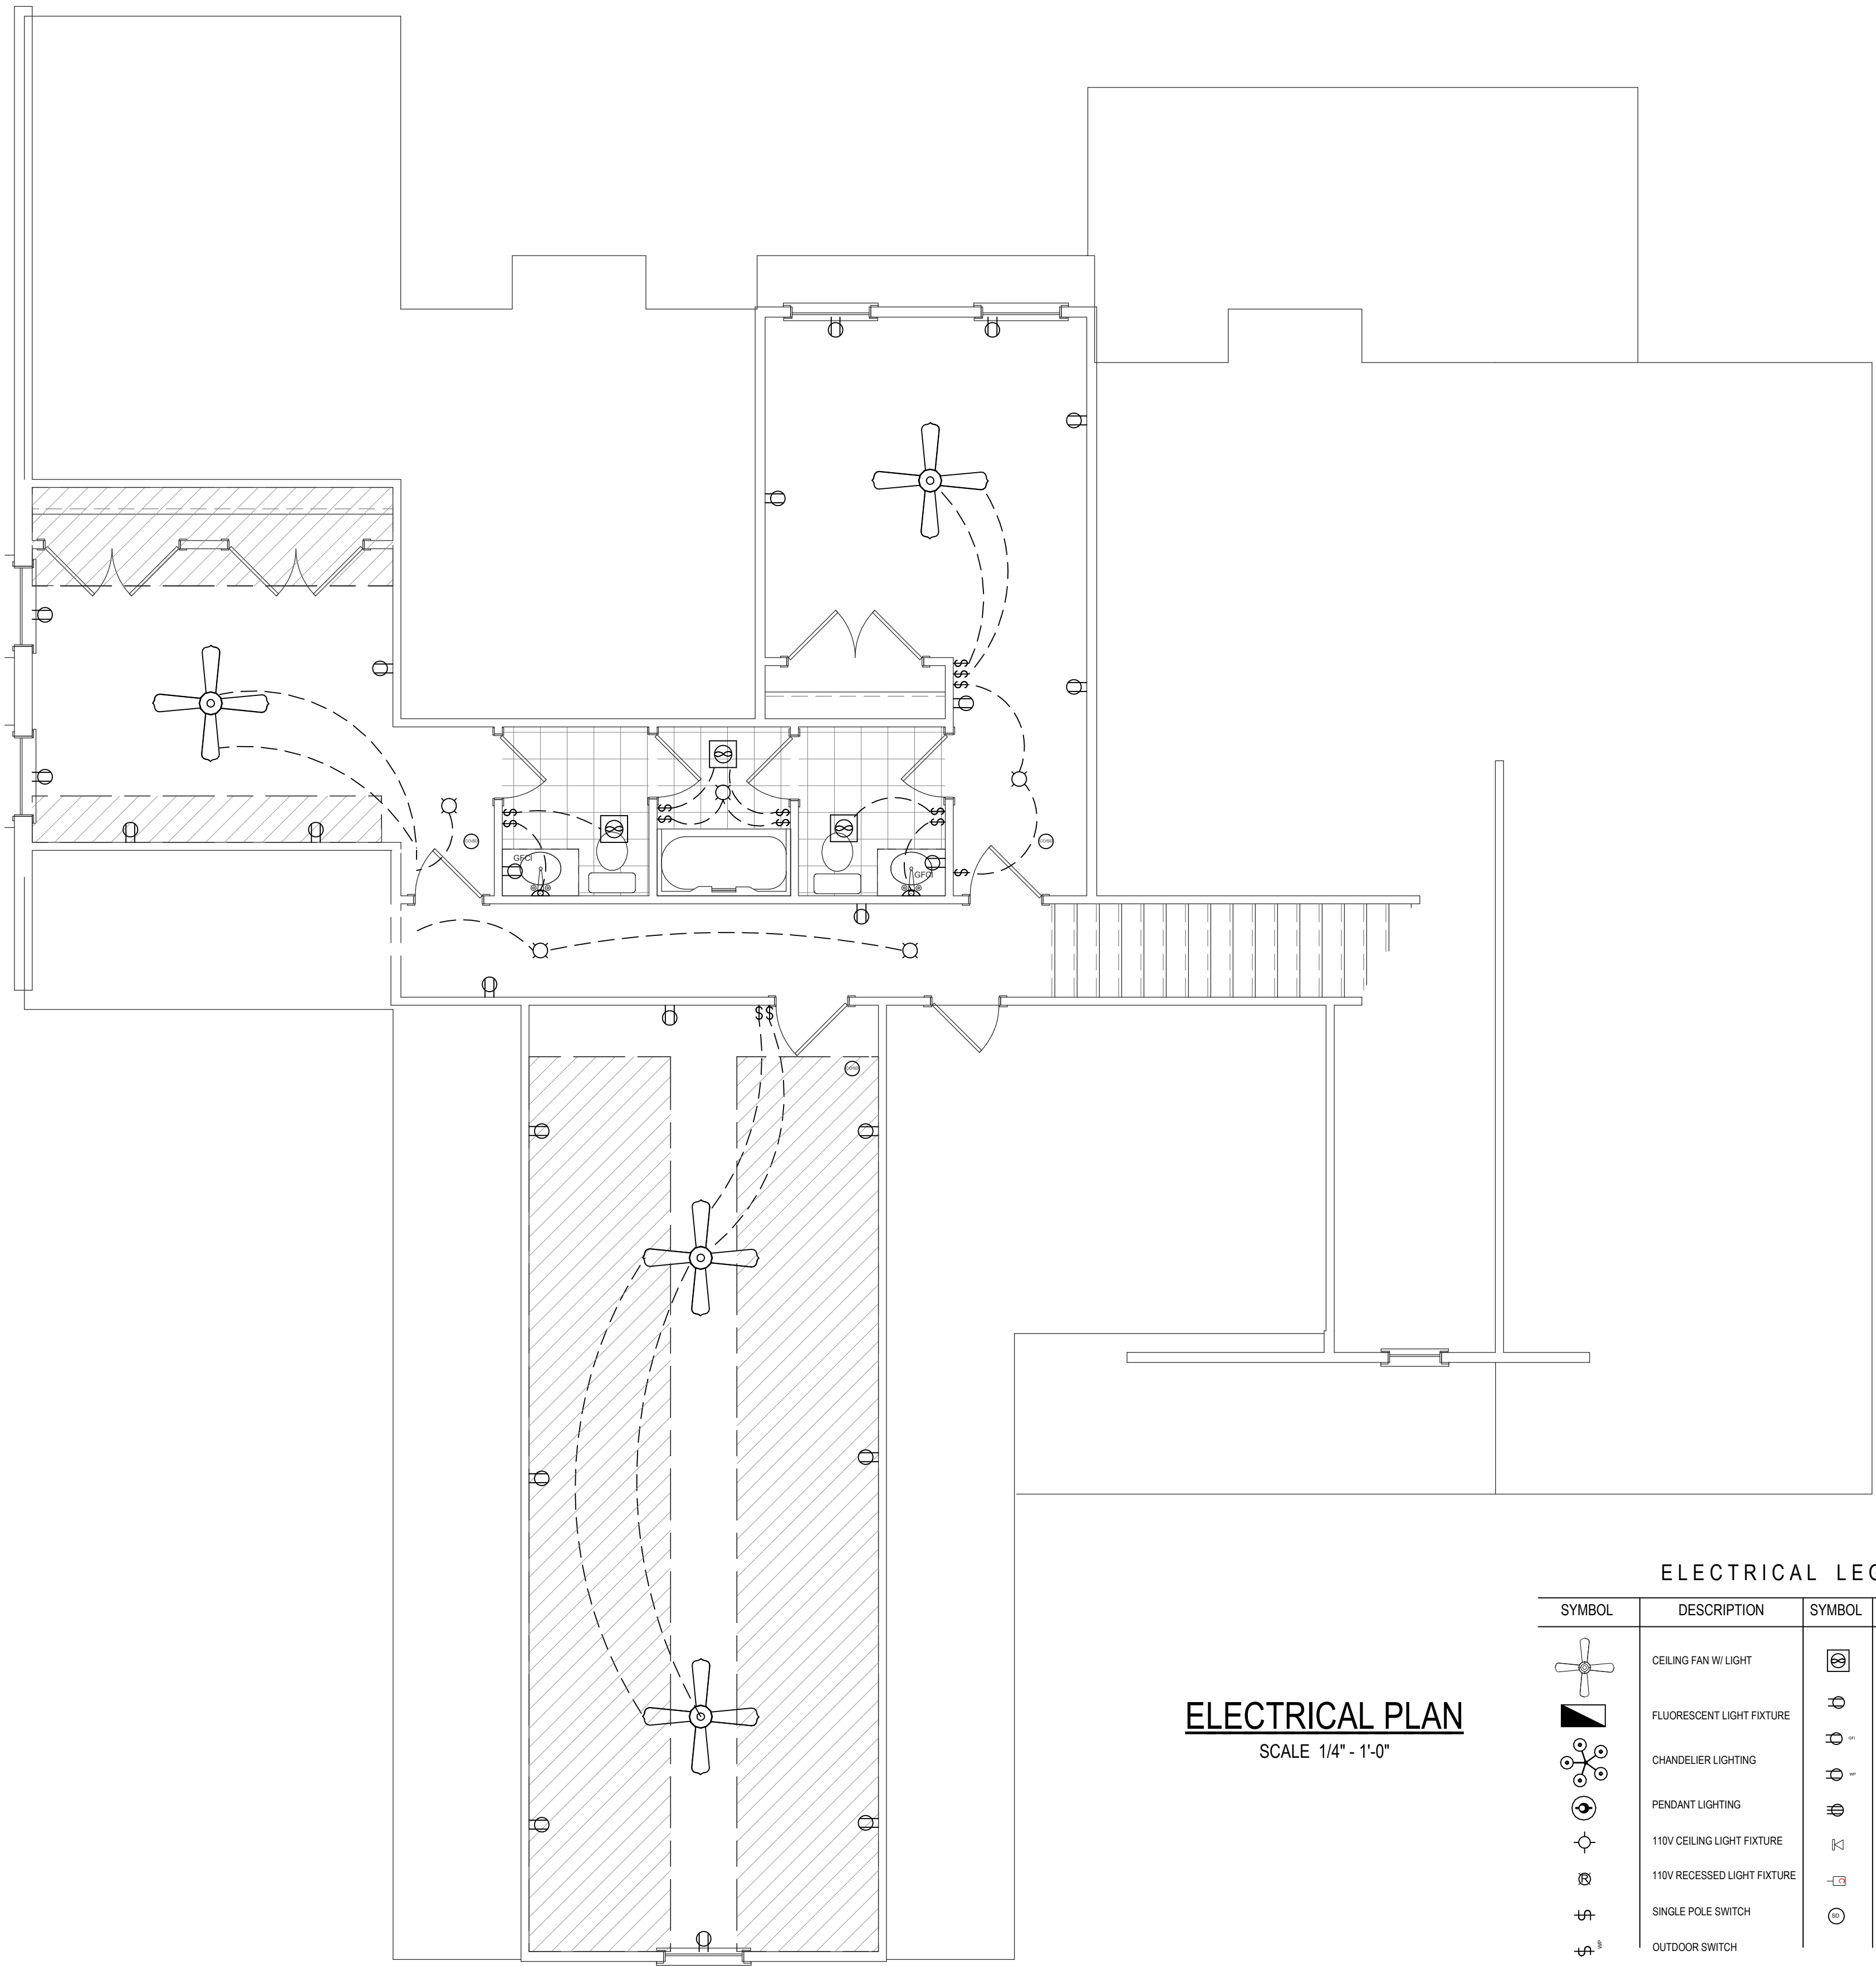

ELECTRICAL LEGEND			
SYMBOL	DESCRIPTION	SYMBOL	DESCRIPTION
	CEILING FAN W/ LIGHT		EXHAUST FAN
	FLUORESCENT LIGHT FIXTURE		110V DUPLEX RECEPTACLE
	CHANDELIER LIGHTING		110V DUPLEX RECEPTACLE GROUND FAULT INTERRUPTED
	PENDANT LIGHTING		110V DUPLEX RECEPTACLE W/ WEATHERPROOF COVER
	110V CEILING LIGHT FIXTURE		240V RECEPTACLE
	110V RECESSED LIGHT FIXTURE		TELEPHONE JACKS
	SINGLE POLE SWITCH		TELEVISION JACKS
	OUTDOOR SWITCH		SMOKE DETECTOR



RAY GOOD
CUSTOM HOME DESIGNS

GENERAL NOTES

- 1) DO NOT SCALE DRAWINGS
- 2) CONTRACTOR SHOULD VERIFY ALL CONDITIONS & DIMENSIONS AT SITE BEFORE BEGINNING CONSTRUCTION.
- 3) ANY DISCREPANCIES SHOULD BE REPORTED TO RG CUSTOM HOME DESIGNS FOR JUSTIFICATION AND/ OR CORRECTIONS BEFORE PROCEEDING WITH WORK.
- 4) CONTRACTOR SHALL ASSUME ALL RESPONSIBILITY FOR ERRORS THAT ARE NOT REPORTED.
- 5) ALL WORK SHOULD BE PERFORMED IN ACCORDANCE WITH ALL APPLICABLE INTERNATIONAL BUILDING CODES.

© RAY GOOD CUSTOM HOME DESIGNS, INC. 2013

 
SPENCER RESIDENCE

CLIENT / COMPANY NAME:

WEAVER HOMEBUILDERS

ADDITIONAL INFO:

Revisions: Date:



809-A Oakhurst Dr.
Evans, G.A. 30809
Office: 706-364-8554
Fax: 706-955-7945
Date Printed: 2/15/2016
Scale: as noted


Drawn By:
G.B. R.G. S.S.
Checked By:
Ray Good

Project Number

- - - - -

A-7

Sheet # 7 OF 10

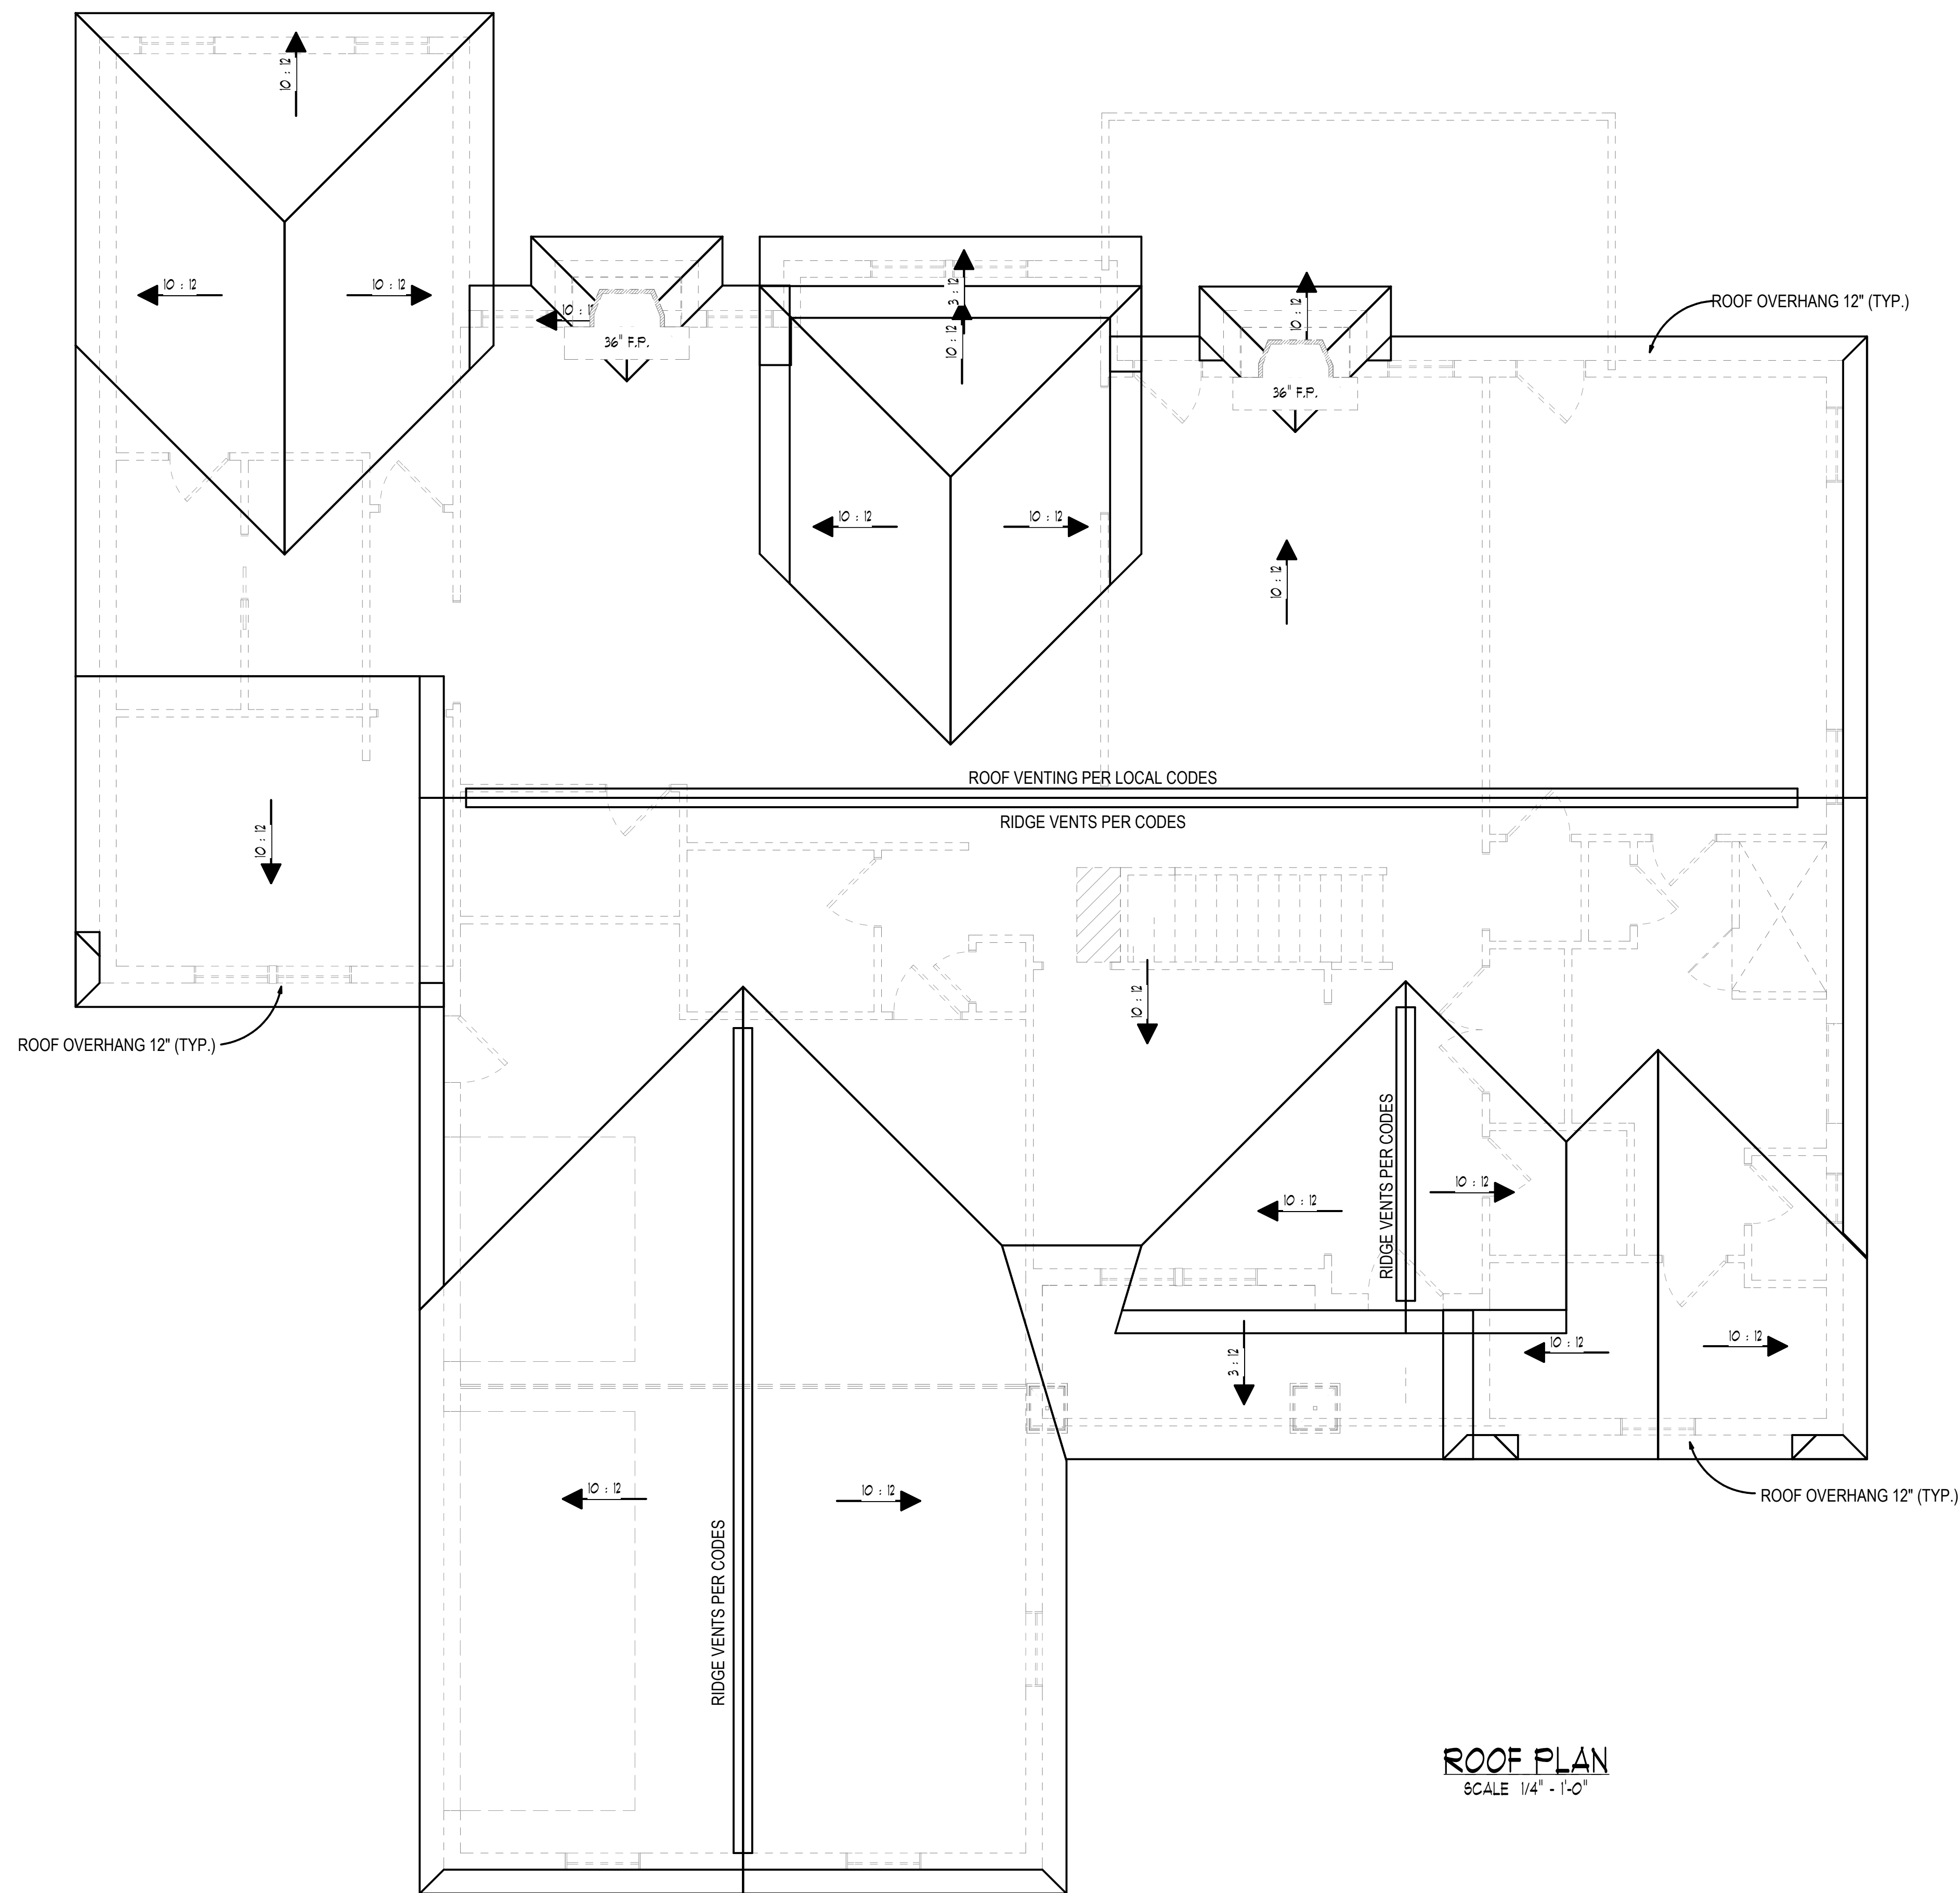

RAY GOOD
CUSTOM HOME DESIGNS

GENERAL NOTES

- 1) DO NOT SCALE DRAWINGS
- 2) CONTRACTOR SHOULD VERIFY ALL CONDITIONS & DIMENSIONS AT SITE BEFORE BEGINNING CONSTRUCTION.
- 3) ANY DISCREPANCIES SHOULD BE REPORTED TO RG CUSTOM HOME DESIGNS FOR JUSTIFICATION AND/OR CORRECTIONS BEFORE PROCEEDING WITH WORK.
- 4) CONTRACTOR SHALL ASSUME ALL RESPONSIBILITY FOR ERRORS THAT ARE NOT REPORTED.
- 5) ALL WORK SHOULD BE PERFORMED IN ACCORDANCE WITH ALL APPLICABLE INTERNATIONAL BUILDING CODES.

© RAY GOOD CUSTOM HOME DESIGNS, INC. 2013

 
SPENCER RESIDENCE

CLIENT / COMPANY NAME:

WEAVER HOMEBUILDERS

ADDITIONAL INFO:

Revisions: Date:



809-A Oakhurst Dr.
Evans, G.A. 30809
Office: 706-364-8554
Fax: 706-955-7945
Date Printed: 2/15/2016
Scale: as noted


Drawn By:
G.B. R.G. S.S.

Checked By:
Ray Good

Project Number

A-8

Sheet # 8 OF 10

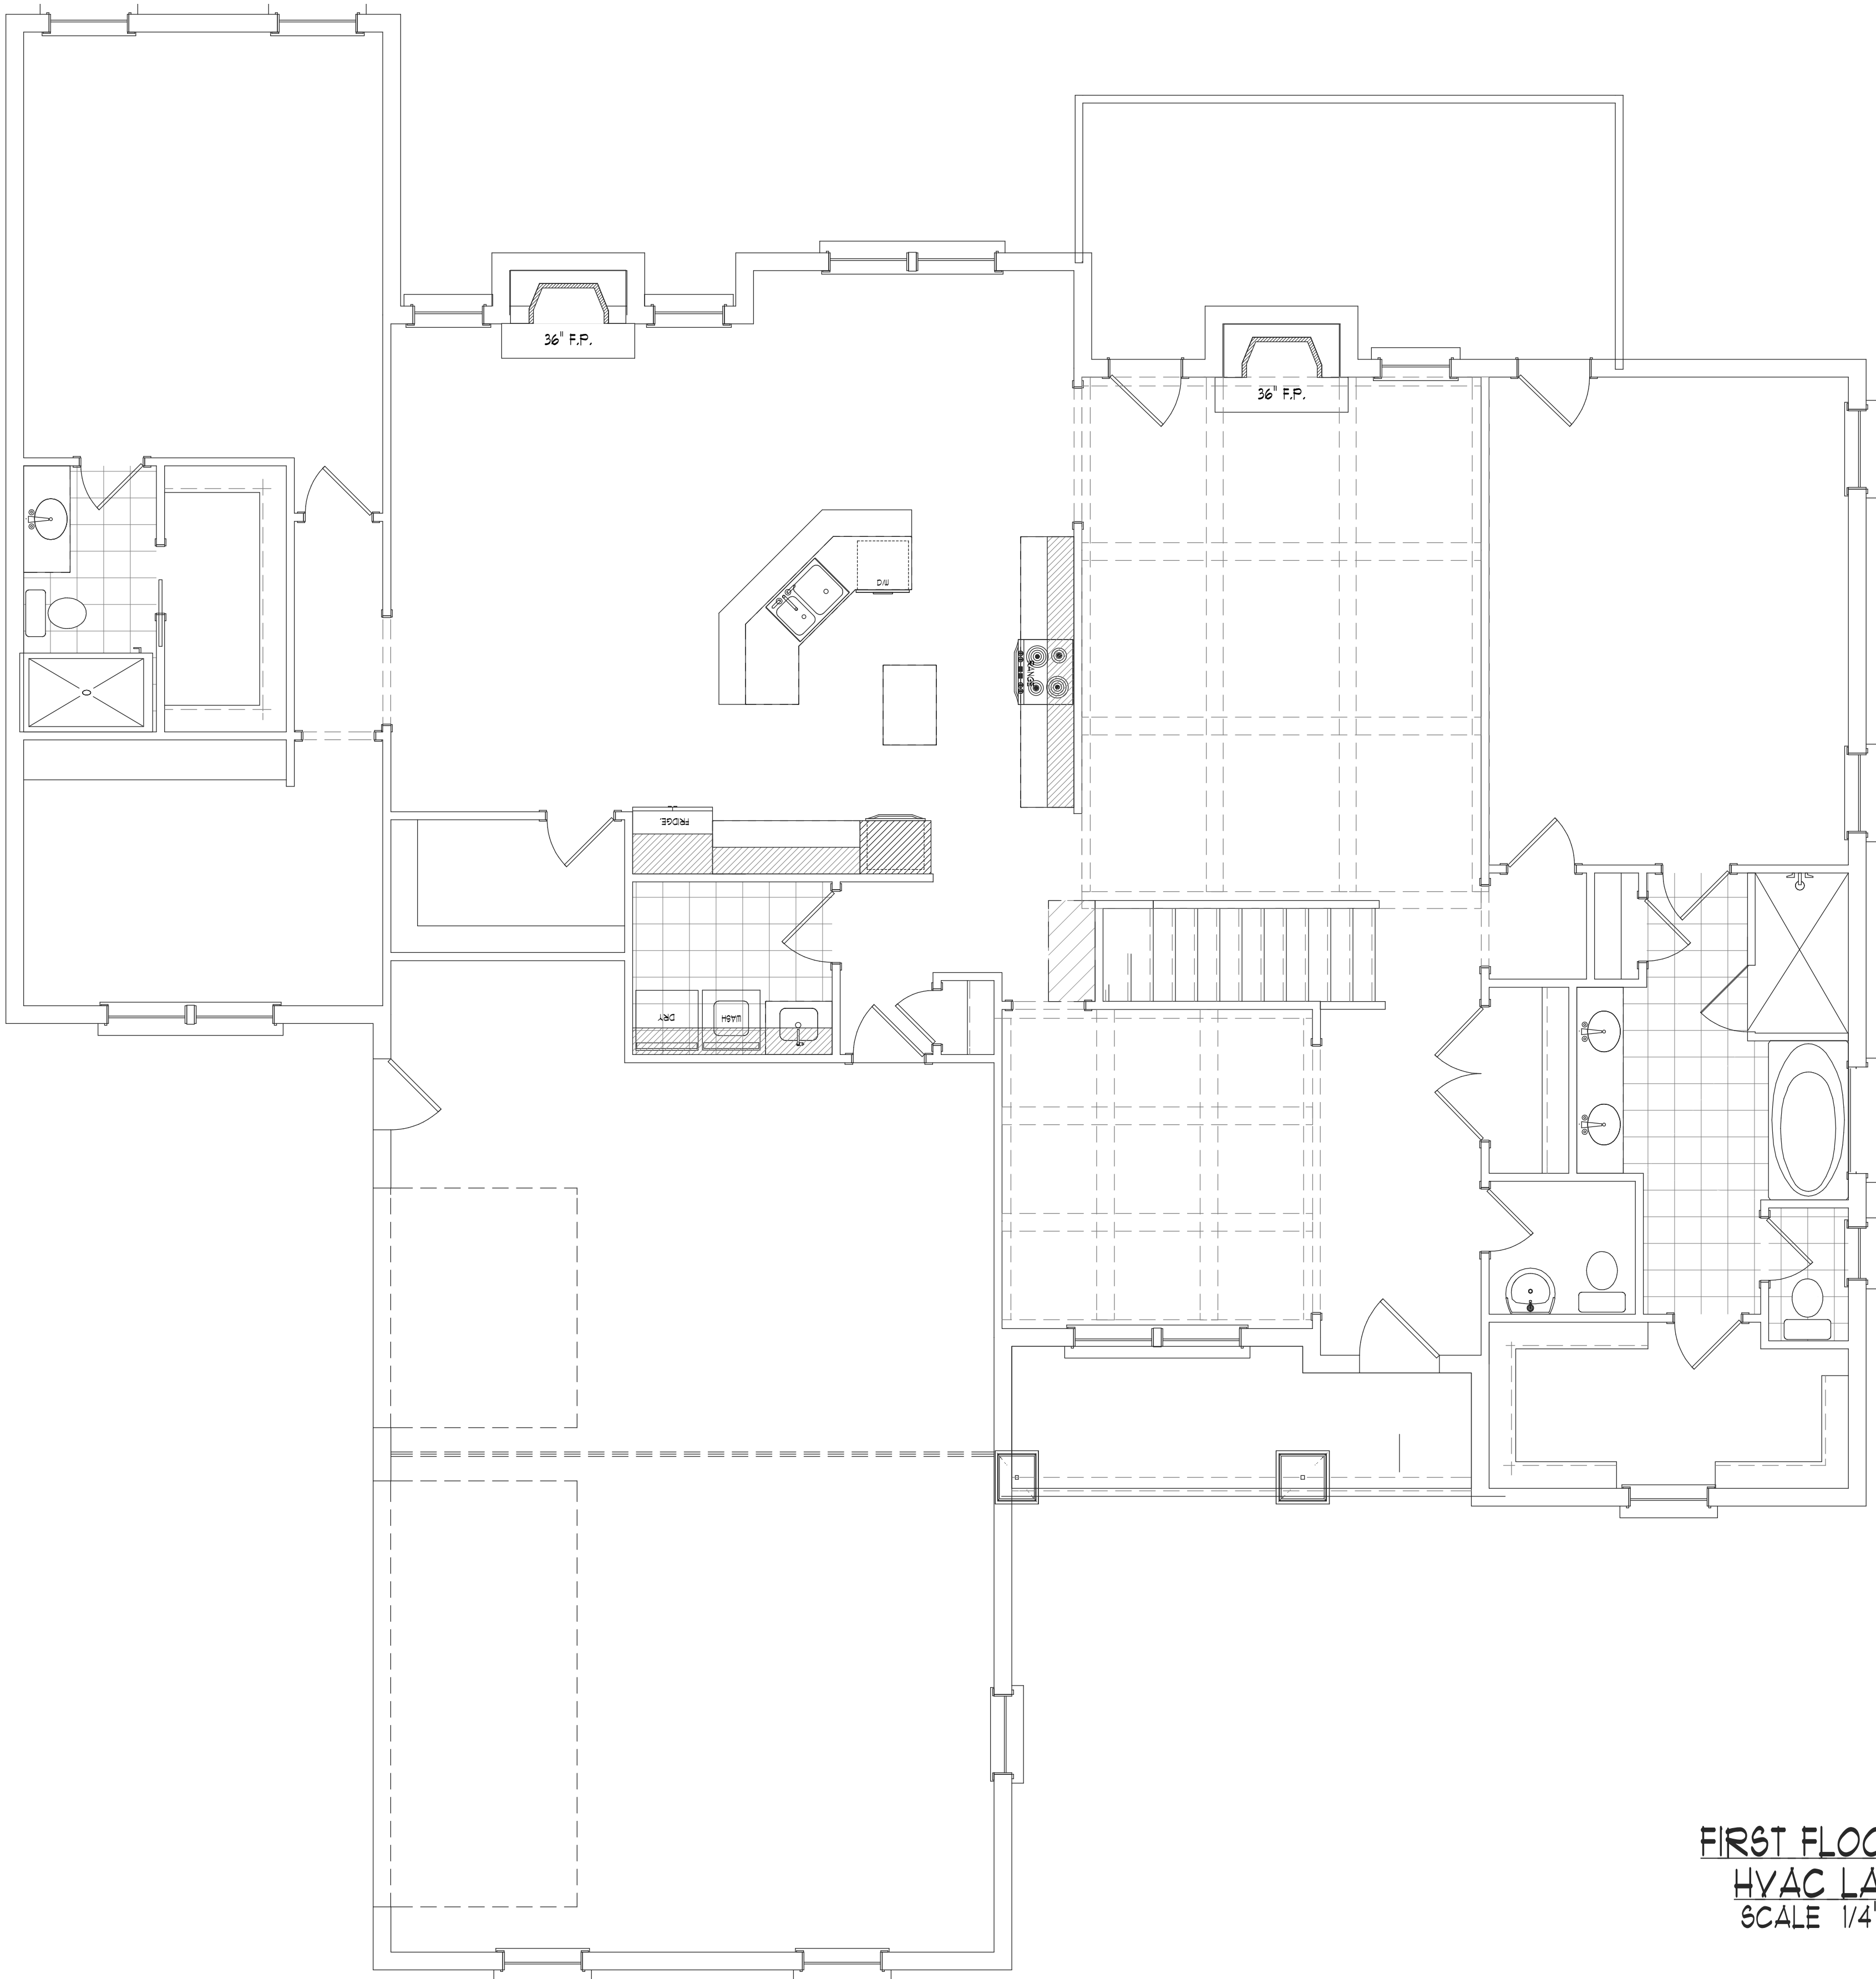

FIRST FLOORPLAN
HVAC LAYOUT
SCALE 1/4" = 1'-0"



RAY GOOD
CUSTOM HOME DESIGNS

GENERAL NOTES

- 1) DO NOT SCALE DRAWINGS
- 2) CONTRACTOR SHOULD VERIFY ALL CONDITIONS & DIMENSIONS AT SITE BEFORE BEGINNING CONSTRUCTION.
- 3) ANY DISCREPANCIES SHOULD BE REPORTED TO RG CUSTOM HOME DESIGNS FOR JUSTIFICATION AND/OR CORRECTIONS BEFORE PROCEEDING WITH WORK.
- 4) CONTRACTOR SHALL ASSUME ALL RESPONSIBILITY FOR ERRORS THAT ARE NOT REPORTED.
- 5) ALL WORK SHOULD BE PERFORMED IN ACCORDANCE WITH ALL APPLICABLE INTERNATIONAL BUILDING CODES.

© RAY GOOD CUSTOM HOME DESIGNS, INC. 2013

 
SPENCER RESIDENCE

CLIENT / COMPANY NAME:

WEAVER HOMEBUILDERS

ADDITIONAL INFO:

Revisions: Date:



809-A Oakhurst Dr.
Evans, G.A. 30809
Office: 706-364-8554
Fax: 706-955-7945
Date Printed: 2/15/2016
Scale: as noted

Drawn By:
G.B. R.G. S.S.


Checked By:
Ray Good

Project Number

- - - - -

A-9

Sheet # 9 OF 10

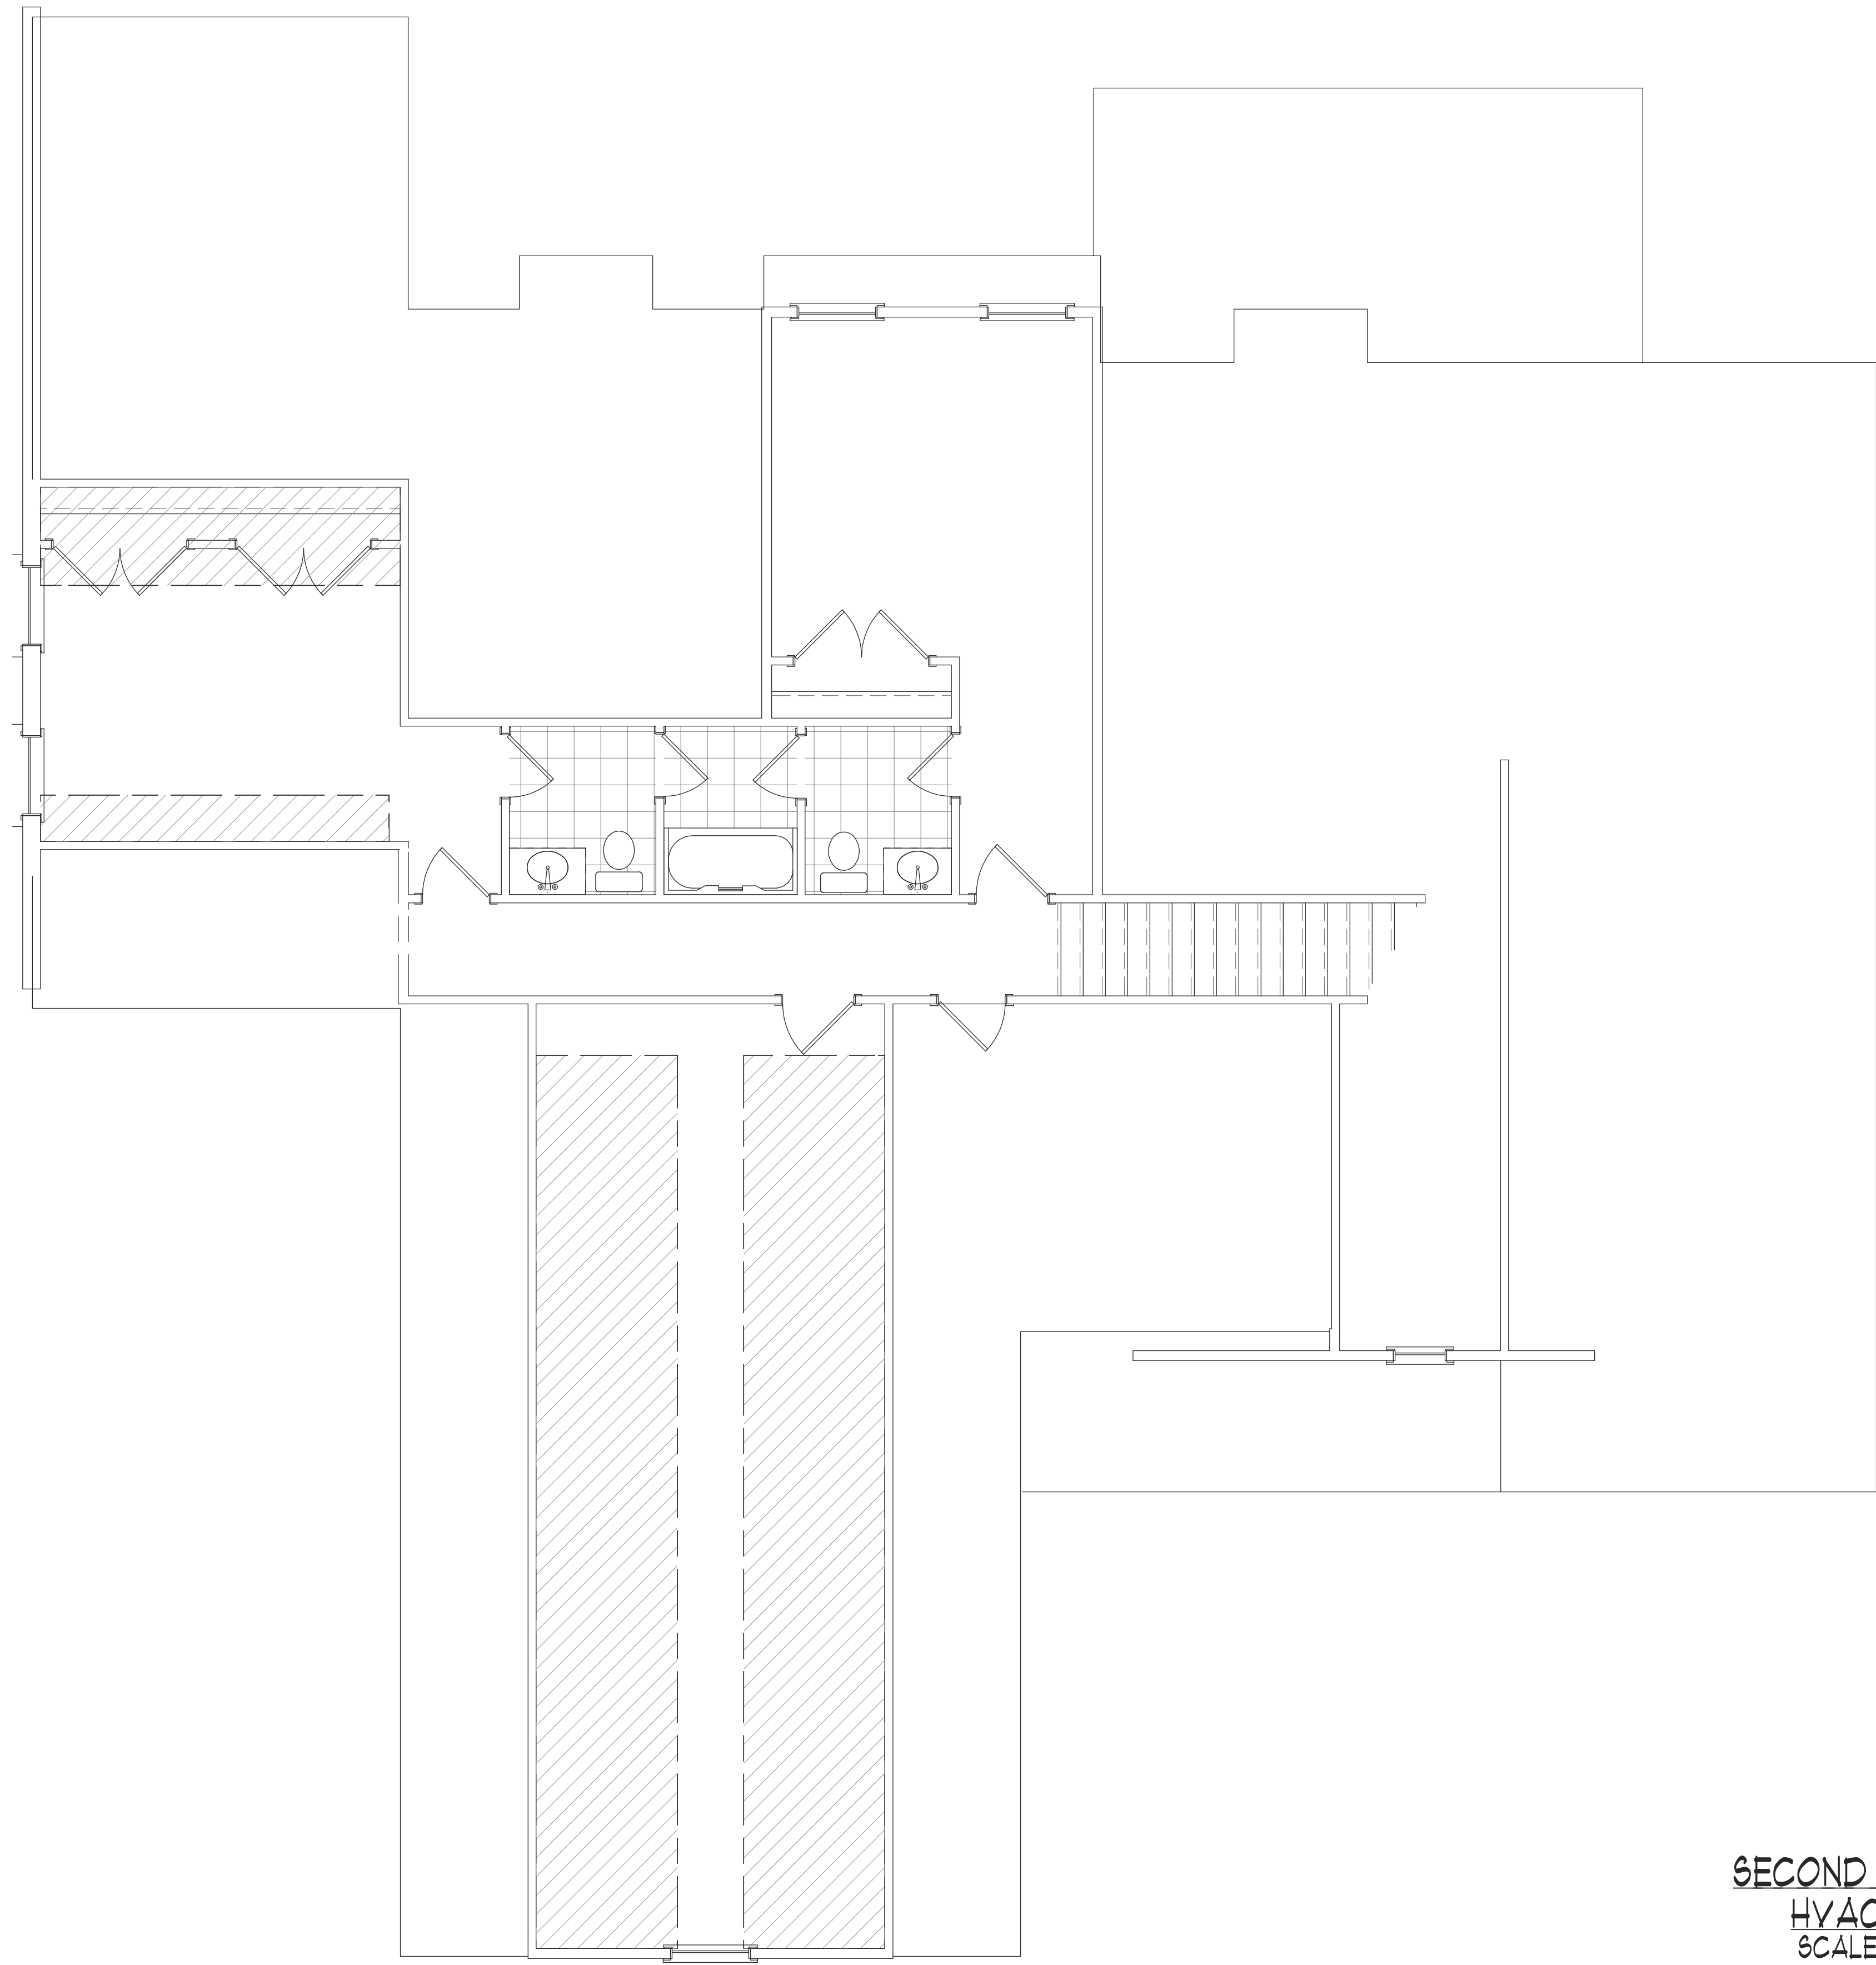

SECOND FLOORPLAN
HVAC LAYOUT
SCALE 1/4" = 1'-0"



RAY GOOD
CUSTOM HOME DESIGNS

GENERAL NOTES

- 1) DO NOT SCALE DRAWINGS
- 2) CONTRACTOR SHOULD VERIFY ALL CONDITIONS & DIMENSIONS AT SITE BEFORE BEGINNING CONSTRUCTION.
- 3) ANY DISCREPANCIES SHOULD BE REPORTED TO RG CUSTOM HOME DESIGNS FOR JUSTIFICATION AND/OR CORRECTIONS BEFORE PROCEEDING WITH WORK.
- 4) CONTRACTOR SHALL ASSUME ALL RESPONSIBILITY FOR ERRORS THAT ARE NOT REPORTED.
- 5) ALL WORK SHOULD BE PERFORMED IN ACCORDANCE WITH ALL APPLICABLE INTERNATIONAL BUILDING CODES.

© RAY GOOD CUSTOM HOME DESIGNS, INC. 2013

SPENCER RESIDENCE

CLIENT / COMPANY NAME:

WEAVER HOMEBUILDERS

ADDITIONAL INFO:

Revisions: Date:



809-A Oakhurst Dr.
Evans, G.A. 30809
Office: 706-364-8554
Fax: 706-955-7945
Date Printed: 2/15/2016
Scale: as noted

Drawn By:
G.B. R.G. S.S.

Checked By:
Ray Good

Project Number

A-10

Sheet # 10 OF 10