
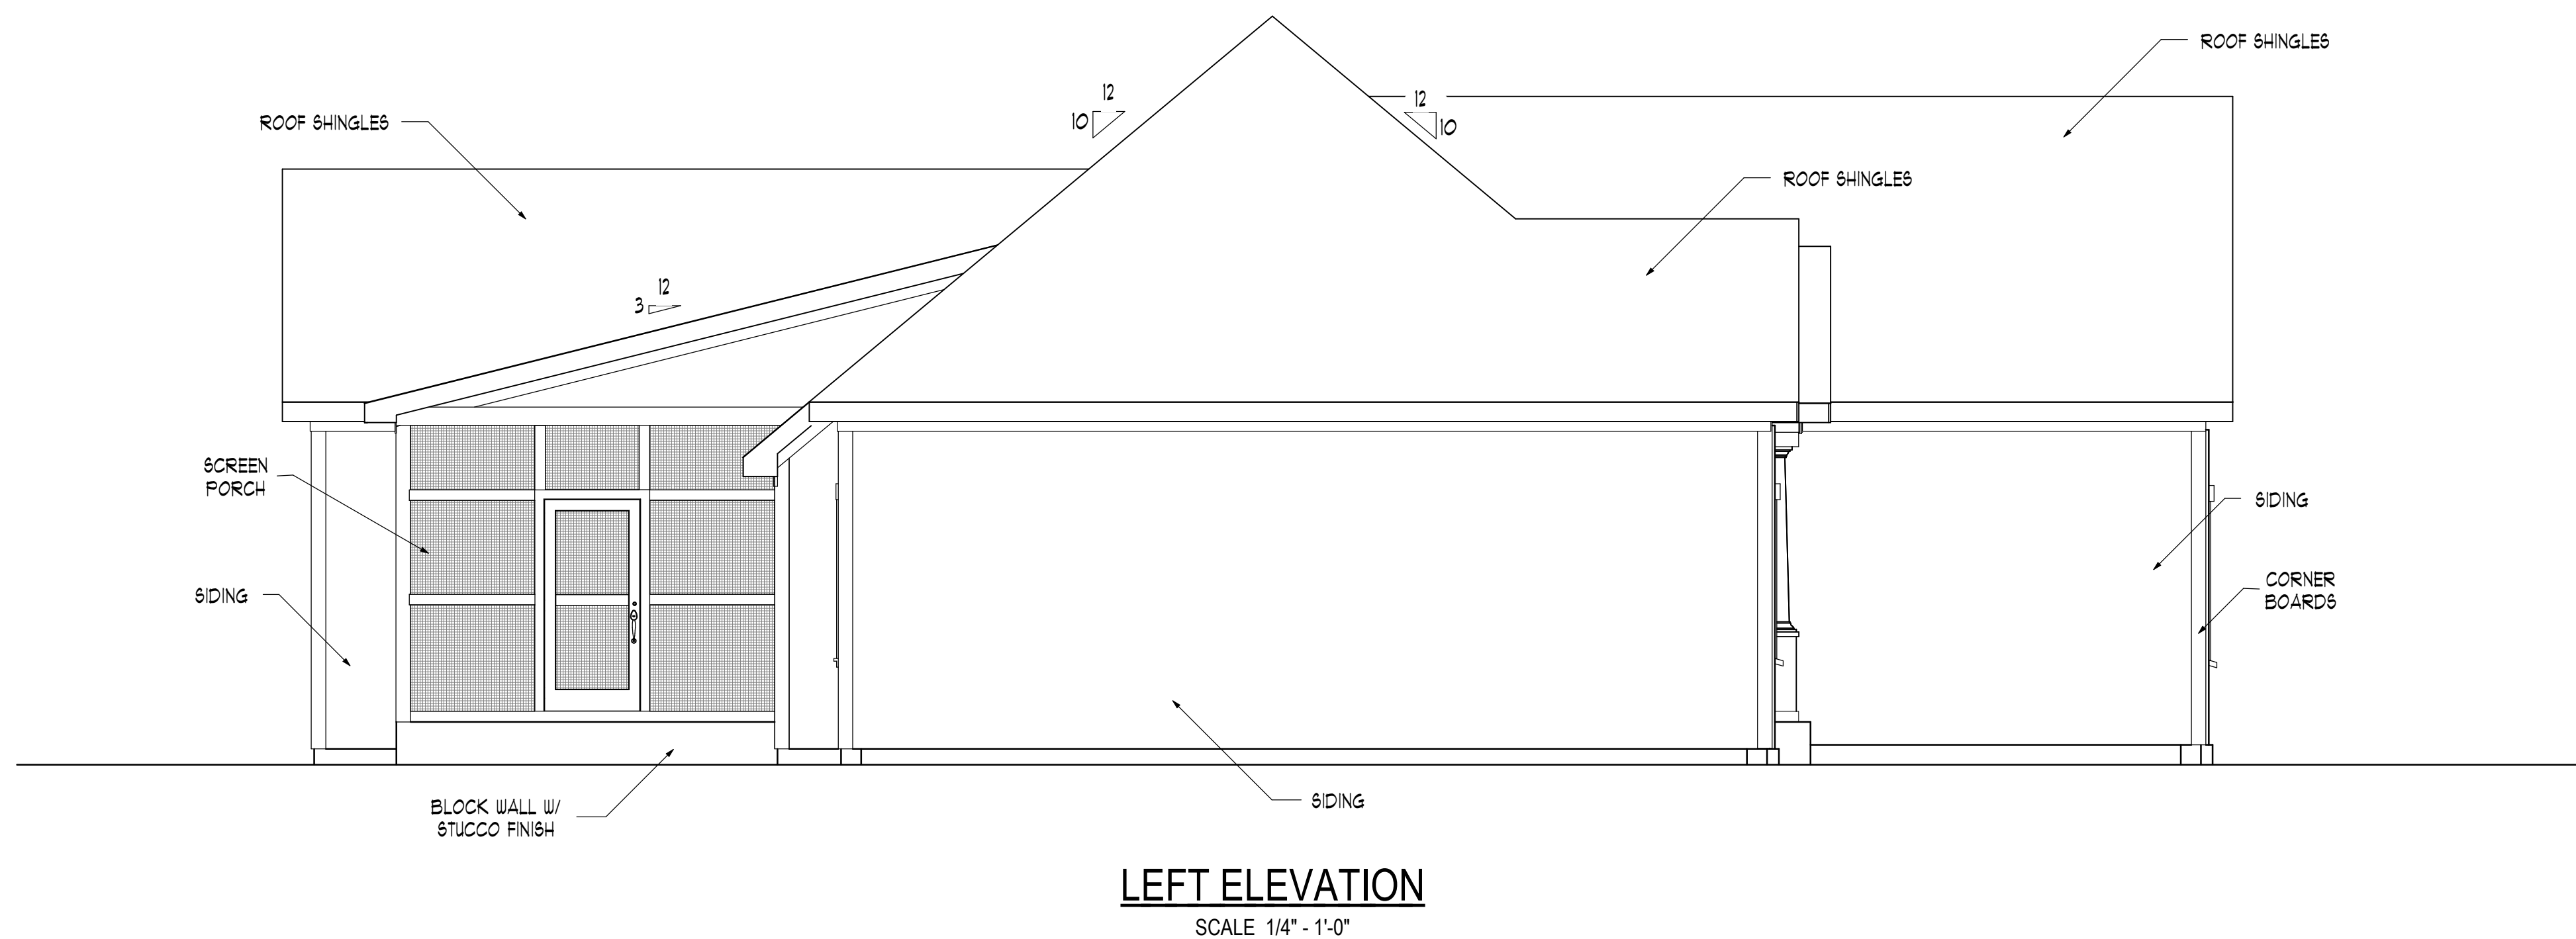


**RAY GOOD**  
CUSTOM HOME DESIGNS

**GENERAL NOTES**

- 1) DO NOT SCALE DRAWINGS
- 2) CONTRACTOR SHOULD VERIFY ALL CONDITIONS & DIMENSIONS AT SITE BEFORE BEGINNING CONSTRUCTION.
- 3) ANY DISCREPANCIES SHOULD BE REPORTED TO RG CUSTOM HOME DESIGNS FOR JUSTIFICATION AND/OR CORRECTIONS BEFORE PROCEEDING WITH WORK.
- 4) CONTRACTOR SHALL ASSUME ALL RESPONSIBILITY FOR ERRORS THAT ARE NOT REPORTED.
- 5) ALL WORK SHOULD BE PERFORMED IN ACCORDANCE WITH ALL APPLICABLE INTERNATIONAL BUILDING CODES.

© RAY GOOD CUSTOM HOME DESIGNS, INC. 2013

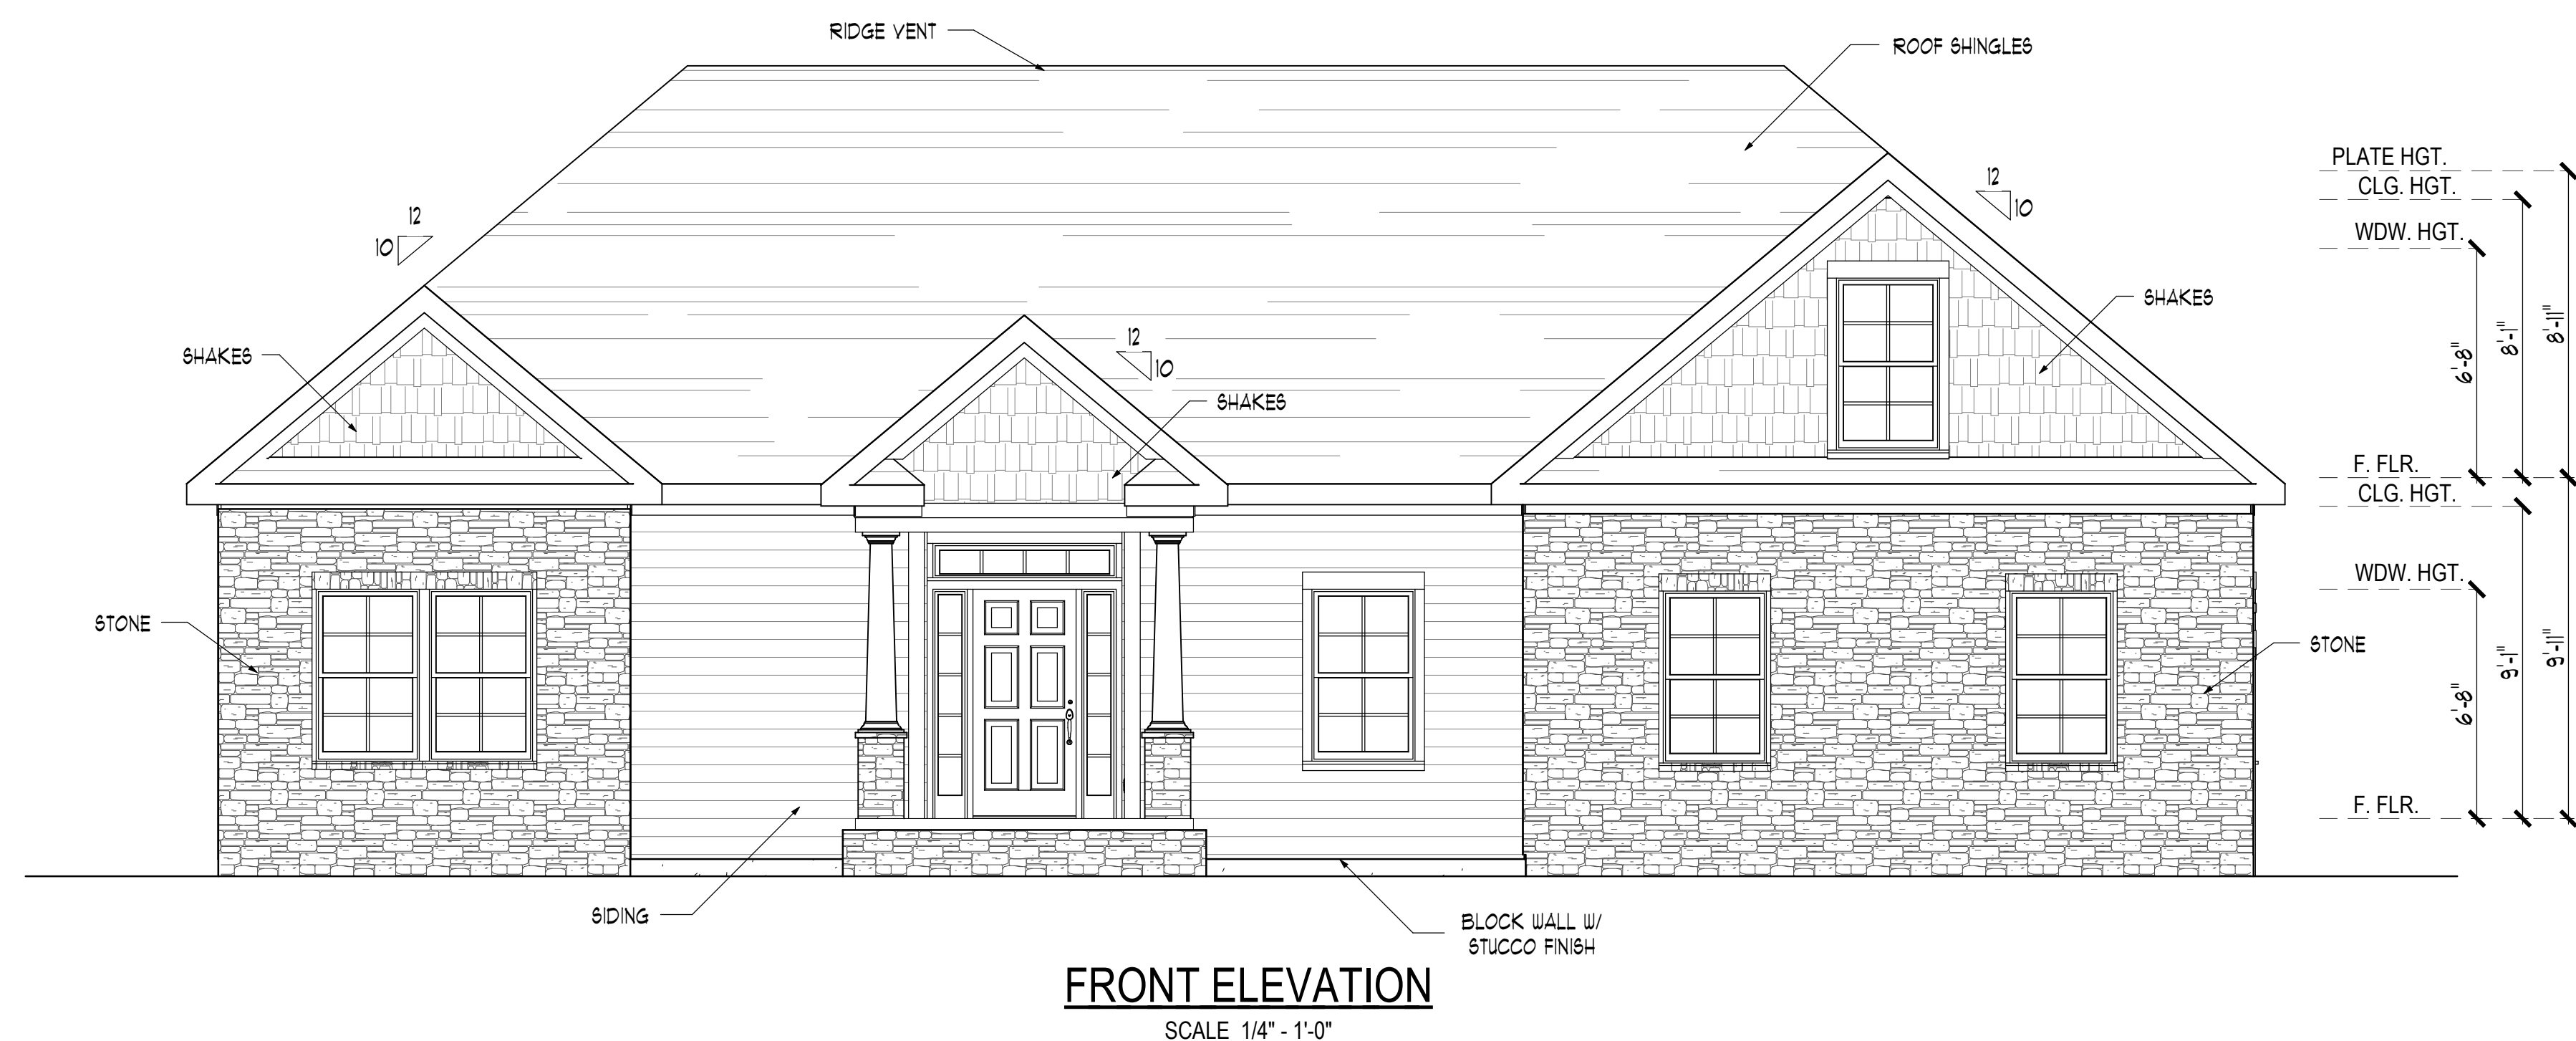

**STEVENS RESIDENCE**

CLIENT / COMPANY NAME:

[RAYGOODDESIGNS.COM](http://RAYGOODDESIGNS.COM)

ADDITIONAL INFO:

Revisions:                      Date:

- △
- △
- △
- △

809-A Oakhurst Dr.  
Evans, G.A. 30809  
Office: 706-364-8554  
Fax: 706-955-7945

Date Printed: 8/7/2014  
Scale: as noted


Drawn By:  
G.B. R.G. S.S.

Checked By:  
Ray Good

Project Number

**A-1**

Sheet # 1 OF 8

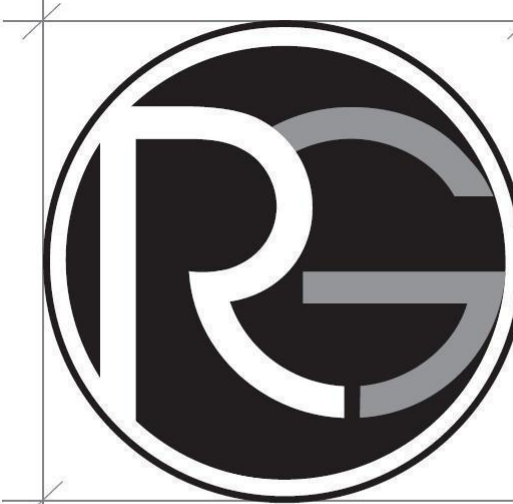


**RAY GOOD**  
CUSTOM HOME DESIGNS


**GENERAL NOTES**

- 1) DO NOT SCALE DRAWINGS
- 2) CONTRACTOR SHOULD VERIFY ALL CONDITIONS & DIMENSIONS AT SITE BEFORE BEGINNING CONSTRUCTION.
- 3) ANY DISCREPANCIES SHOULD BE REPORTED TO RG CUSTOM HOME DESIGNS FOR JUSTIFICATION AND/OR CORRECTIONS BEFORE PROCEEDING WITH WORK.
- 4) CONTRACTOR SHALL ASSUME ALL RESPONSIBILITY FOR ERRORS THAT ARE NOT REPORTED.
- 5) ALL WORK SHOULD BE PERFORMED IN ACCORDANCE WITH ALL APPLICABLE INTERNATIONAL BUILDING CODES.

© RAY GOOD CUSTOM HOME DESIGNS, INC. 2013

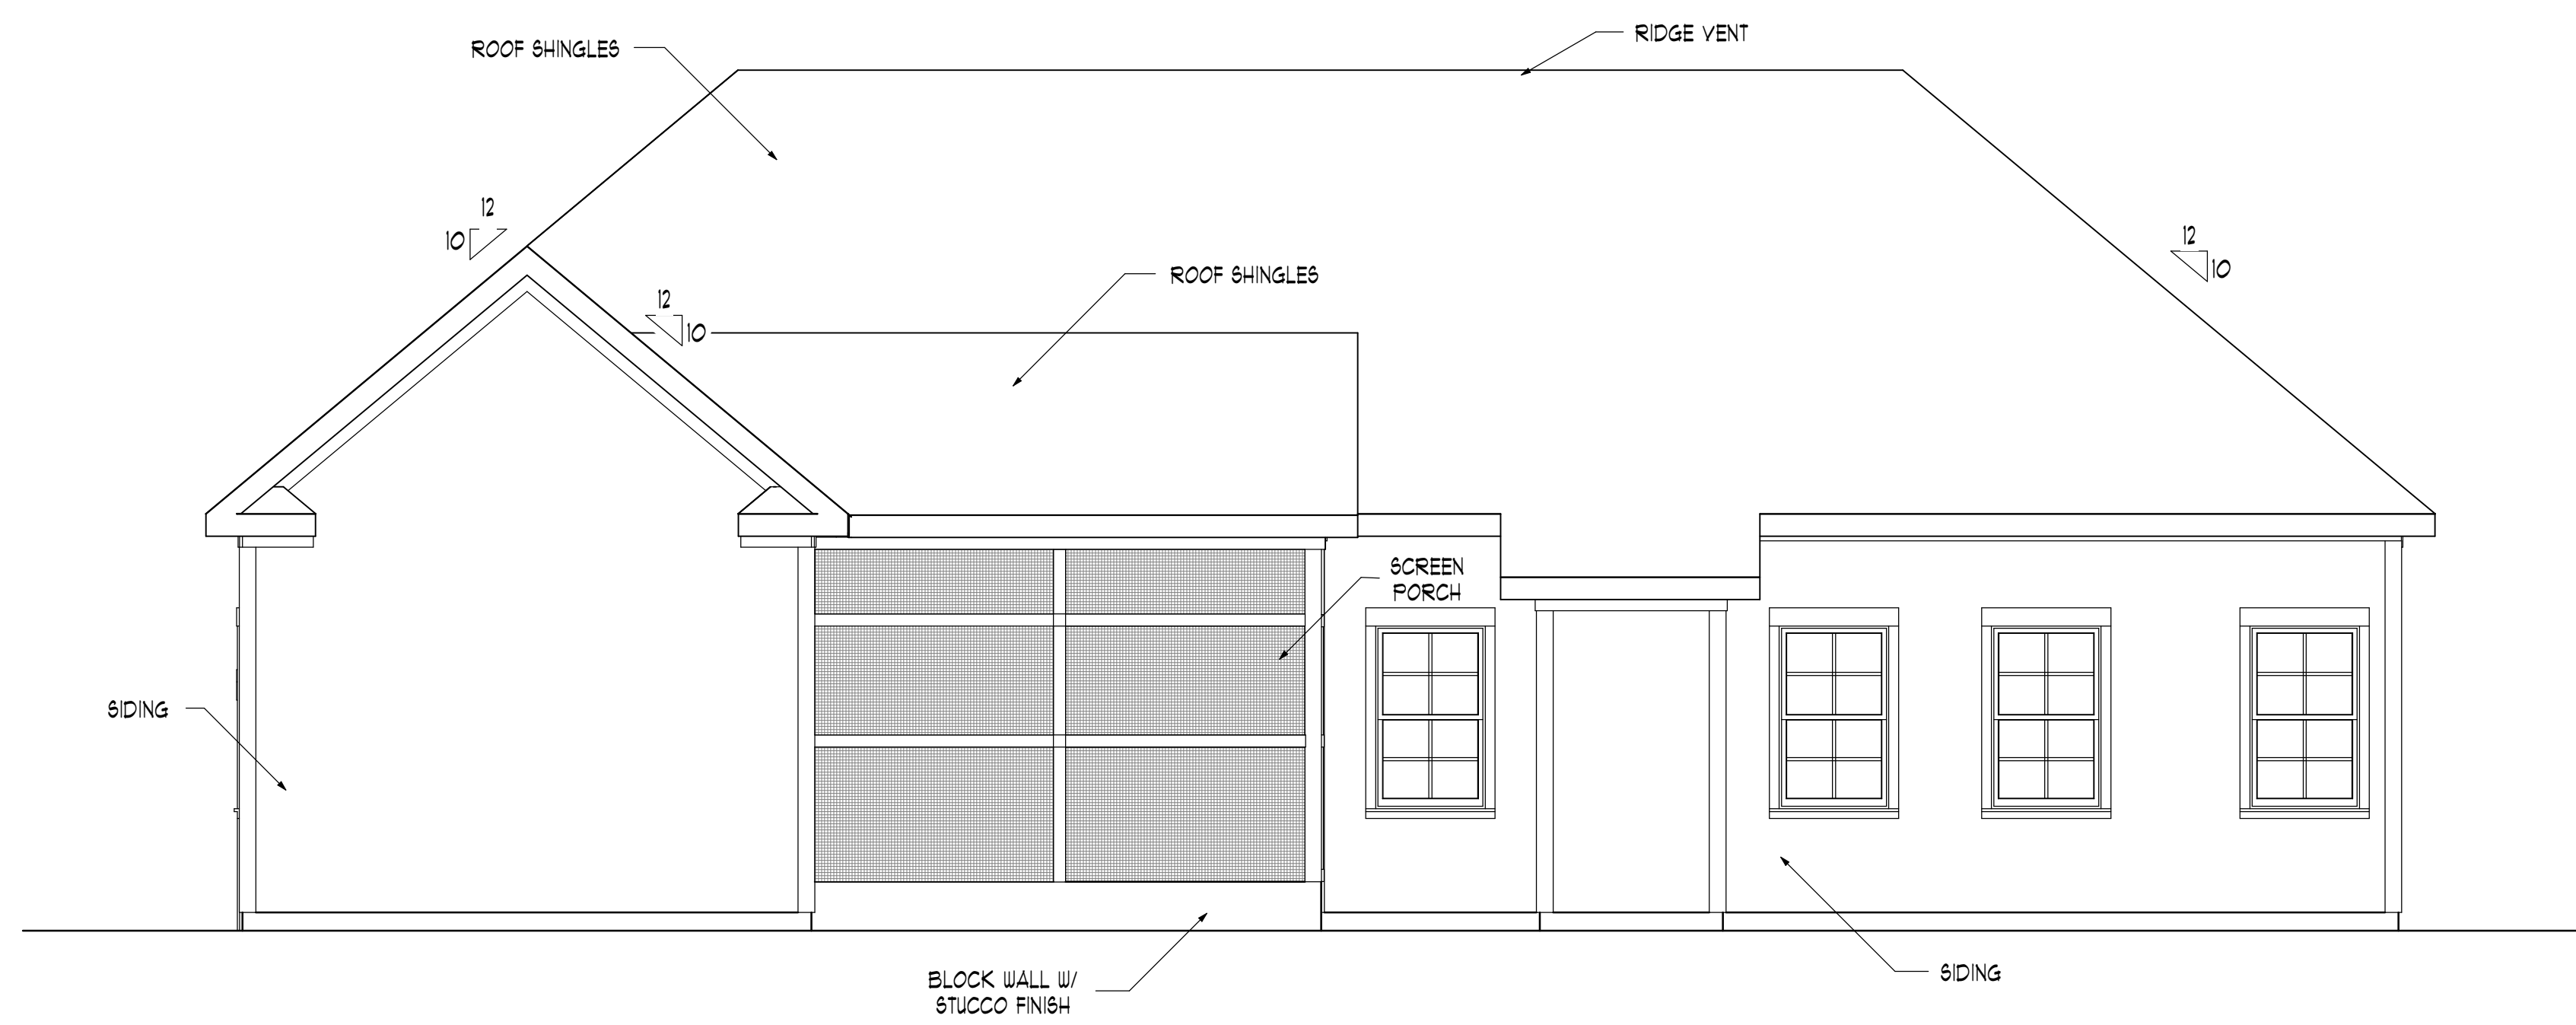

**REAR ELEVATION**  
SCALE 1/4" = 1'-0"

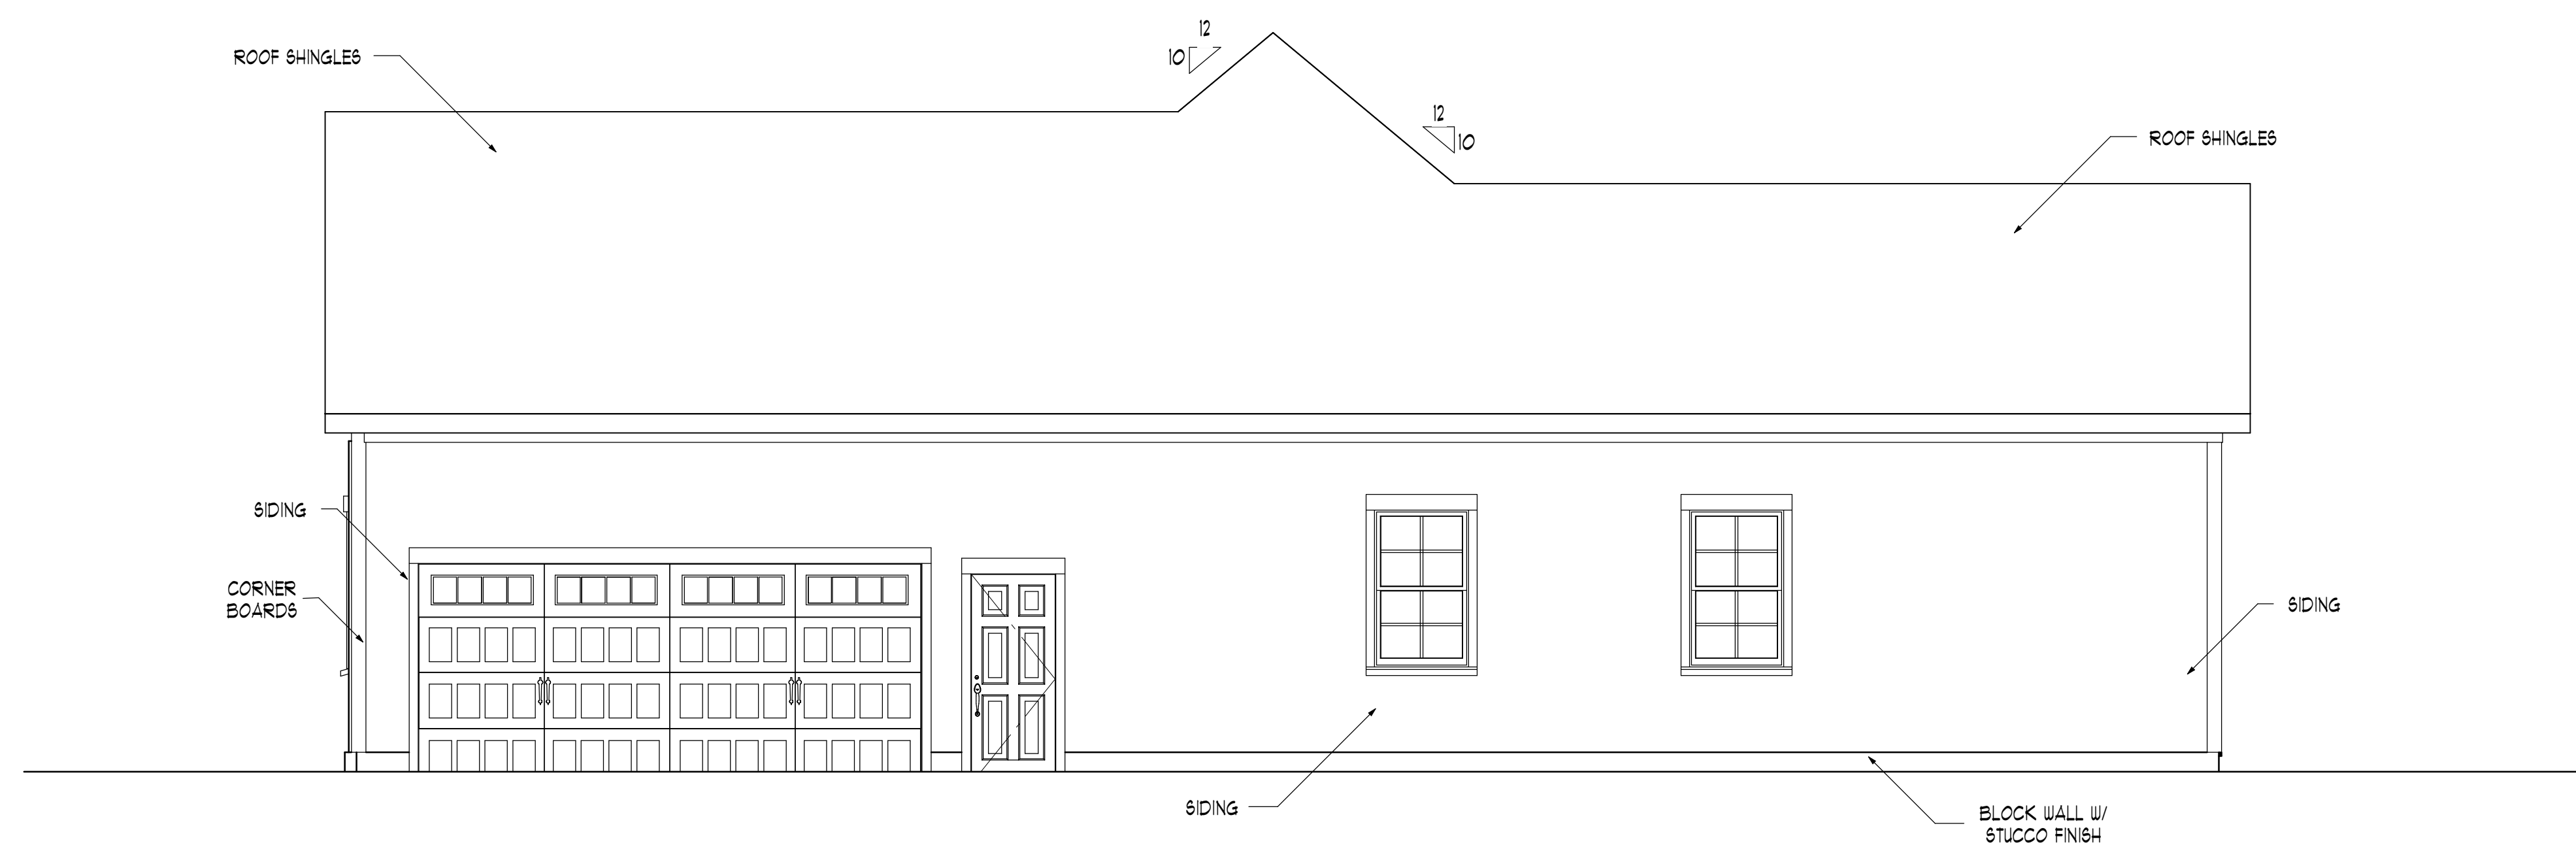

**RIGHT ELEVATION**  
SCALE 1/4" = 1'-0"

**STEVENS RESIDENCE**

CLIENT / COMPANY NAME:

**RAYGOODDESIGNS.COM**

ADDITIONAL INFO:

Revisions:                      Date:

- △
- △
- △
- △

809-A Oakhurst Dr.  
Evans, G.A. 30809  
Office: 706-364-8554  
Fax: 706-955-7945

Date Printed: 8/7/2014  
Scale: as noted

Drawn By:  
G.B. R.G. S.S.


Checked By:  
Ray Good

Project Number

**A-2**

Sheet # 2 OF 8



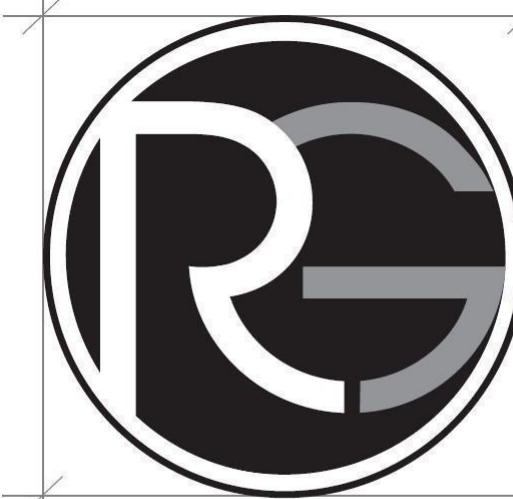

**RAY GOOD**  
CUSTOM HOME DESIGNS

**GENERAL NOTES**

- 1) DO NOT SCALE DRAWINGS
- 2) CONTRACTOR SHOULD VERIFY ALL CONDITIONS & DIMENSIONS AT SITE BEFORE BEGINNING CONSTRUCTION.
- 3) ANY DISCREPANCIES SHOULD BE REPORTED TO RG CUSTOM HOME DESIGNS FOR JUSTIFICATION AND/OR CORRECTIONS BEFORE PROCEEDING WITH WORK.
- 4) CONTRACTOR SHALL ASSUME ALL RESPONSIBILITY FOR ERRORS THAT ARE NOT REPORTED.
- 5) ALL WORK SHOULD BE PERFORMED IN ACCORDANCE WITH ALL APPLICABLE INTERNATIONAL BUILDING CODES.

© RAY GOOD CUSTOM HOME DESIGNS, INC. 2013



NOTE:  
BUILDER TO VERIFY ALL WINDOW SIZES  
FOR INGRESS / EGRESS REQUIREMENTS

NOTE:  
STAIRS ARE DRAWN TO BE 10" TREAD  
W/ 7 1/2" RISERS

NOTE:  
ALL DIMENSIONS ARE TO STUD WALL

ESTIMATED SQUARE FOOTAGE	
FIRST FLOOR HTD.	1726 SQ. FT.
SECOND FLOOR HTD.	311 SQ. FT.
TOTAL HTD.	2037 SQ. FT.
FRONT PORCH	46 SQ. FT.
SCREEN PORCH	161 SQ. FT.
GARAGE	486 SQ. FT.
TOTAL	2730 SQ. FT.

**FIRST FLOORPLAN**  
SCALE 1/4" = 1'-0"  
1726 sq ft

**STEVENS RESIDENCE**

CLIENT / COMPANY NAME:

[RAYGOODDESIGNS.COM](http://RAYGOODDESIGNS.COM)

ADDITIONAL INFO:

Revisions: \_\_\_\_\_ Date: \_\_\_\_\_



809-A Oakhurst Dr.  
Evans, G.A. 30809  
Office: 706-364-8554  
Fax: 706-955-7945  
Date Printed: 8/7/2014  
Scale: as noted

Drawn By:

G.B. R.G. S.S.


Checked By:

Ray Good


Project Number

**A-4**

Sheet # 4 OF 8

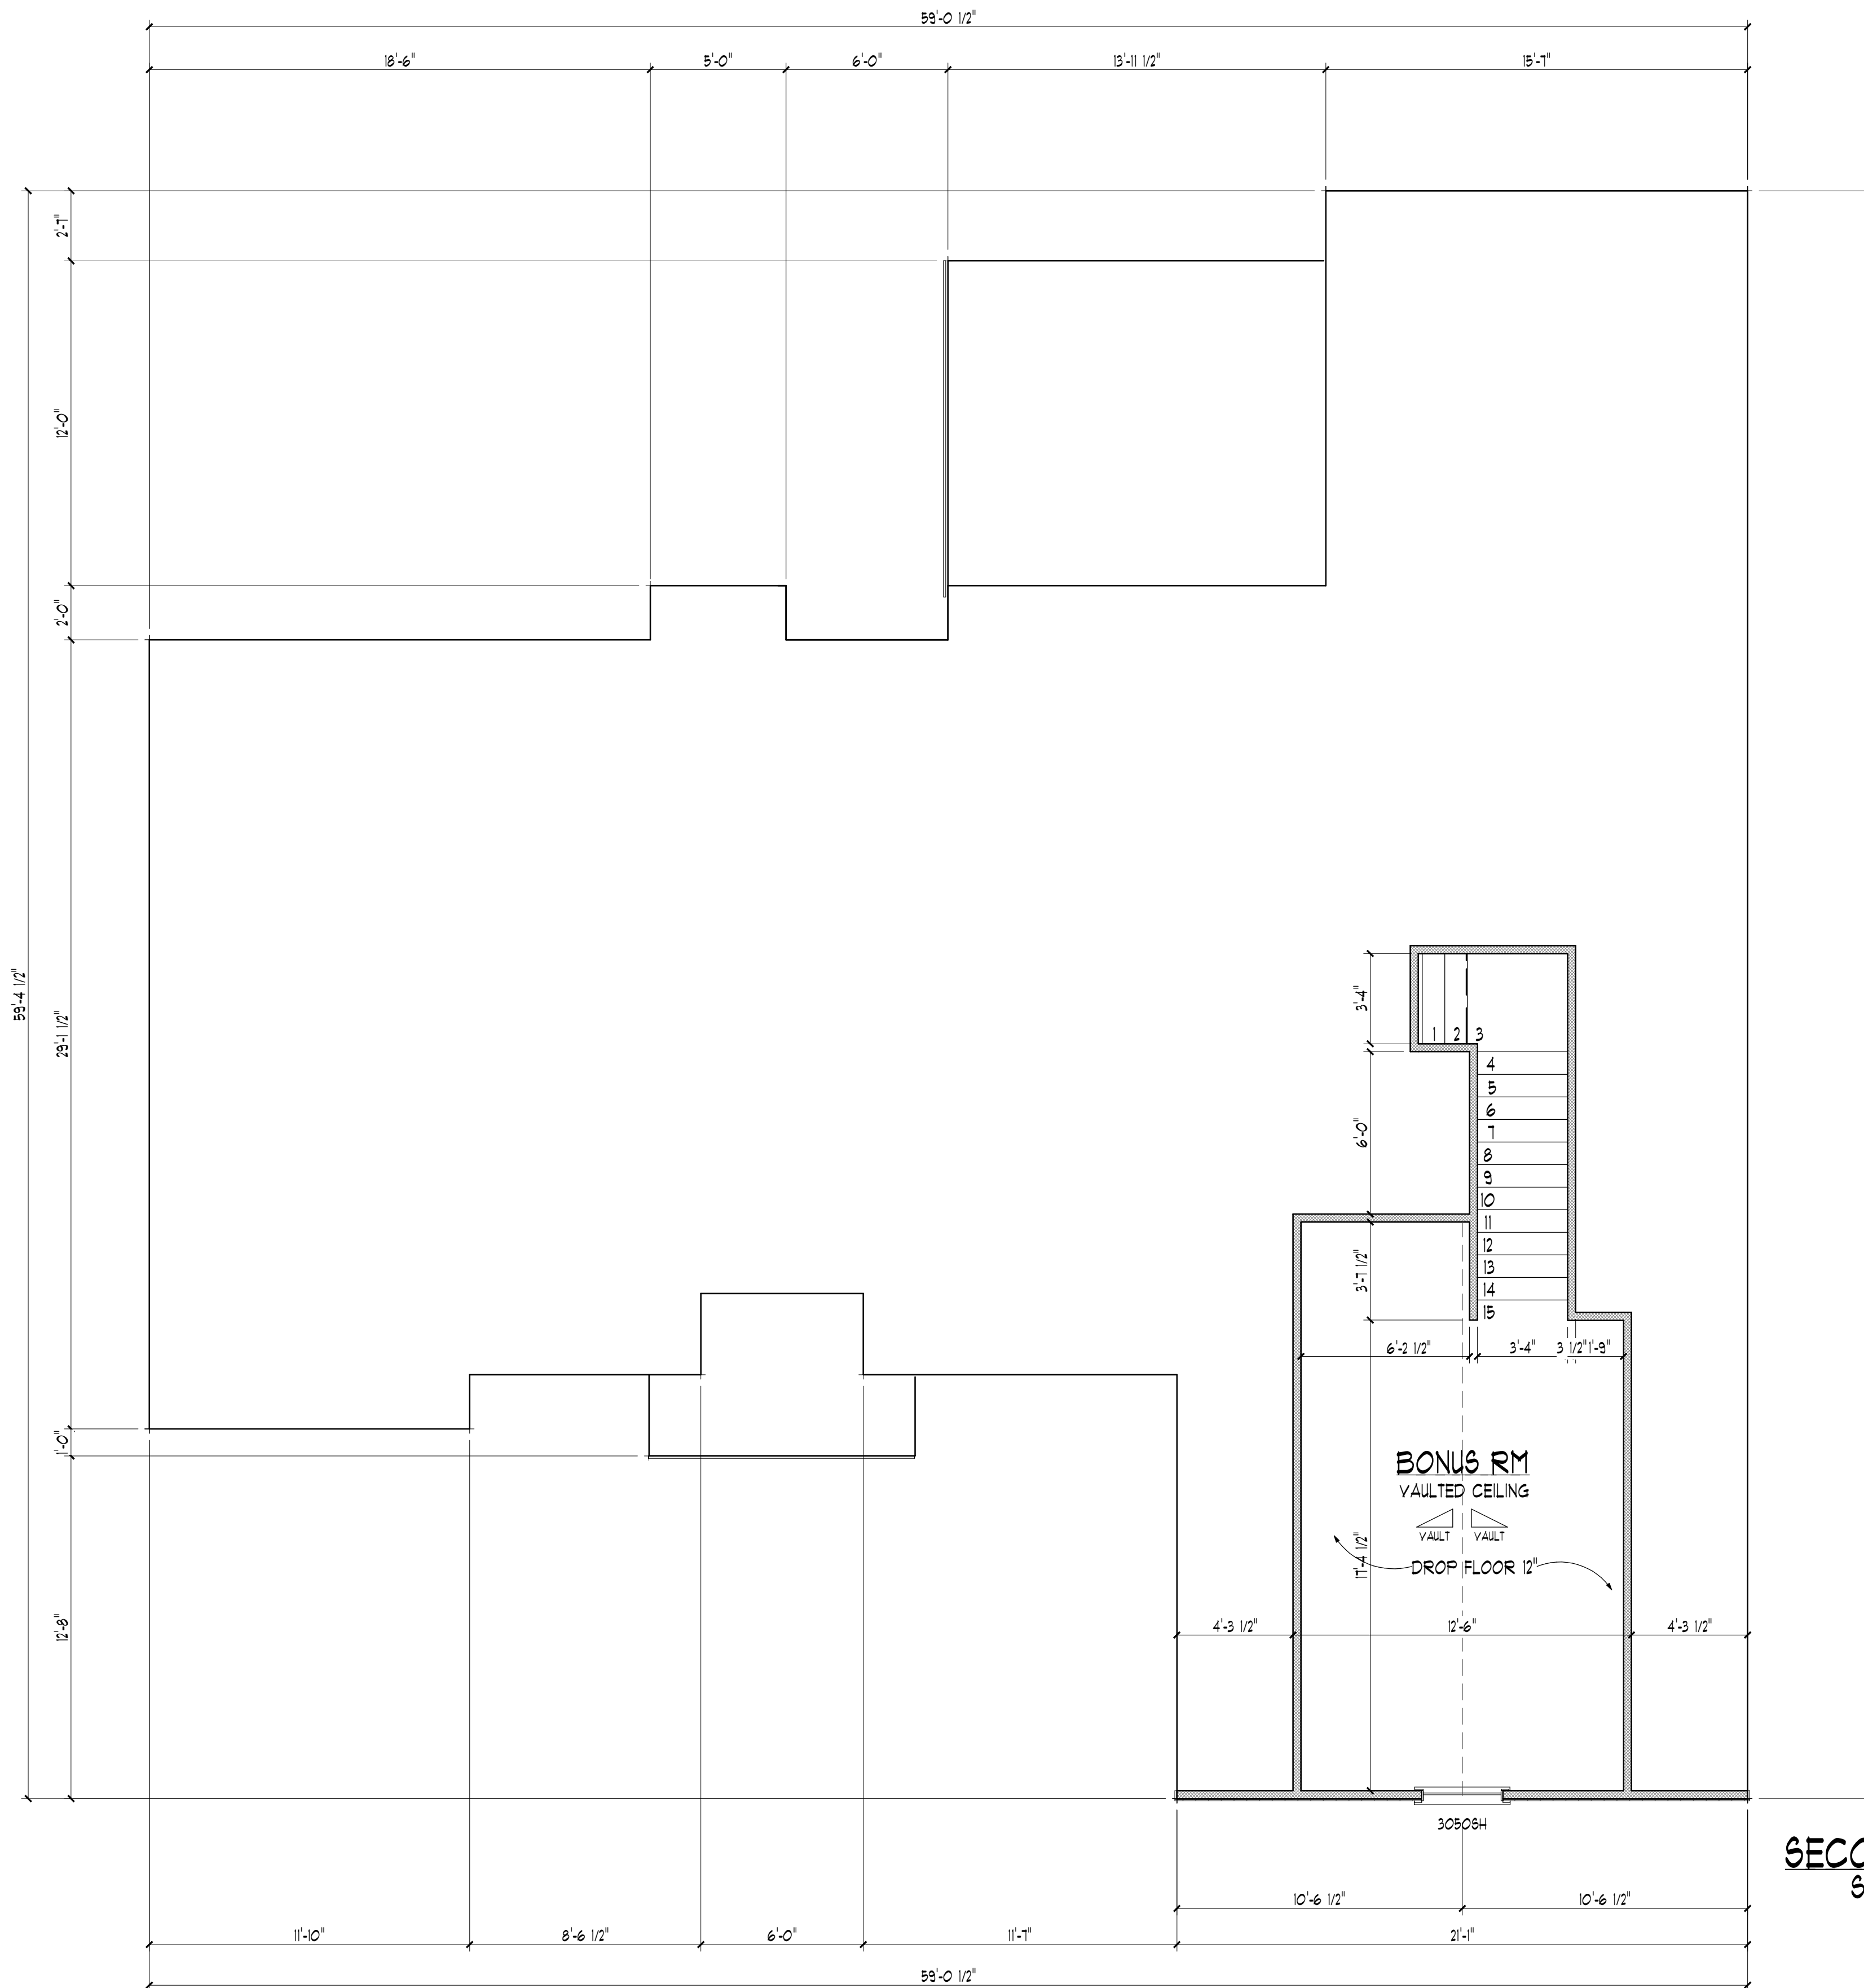

**SECOND FLOORPLAN**  
SCALE 1/4" = 1'-0"  
311 sq ft

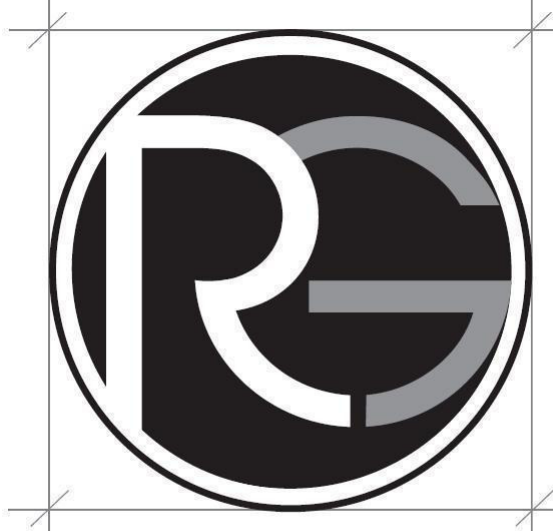

**RAY GOOD**  
CUSTOM HOME DESIGNS

**GENERAL NOTES**

- 1) DO NOT SCALE DRAWINGS
- 2) CONTRACTOR SHOULD VERIFY ALL CONDITIONS & DIMENSIONS AT SITE BEFORE BEGINNING CONSTRUCTION.
- 3) ANY DISCREPANCIES SHOULD BE REPORTED TO RG CUSTOM HOME DESIGNS FOR JUSTIFICATION AND/OR CORRECTIONS BEFORE PROCEEDING WITH WORK.
- 4) CONTRACTOR SHALL ASSUME ALL RESPONSIBILITY FOR ERRORS THAT ARE NOT REPORTED.
- 5) ALL WORK SHOULD BE PERFORMED IN ACCORDANCE WITH ALL APPLICABLE INTERNATIONAL BUILDING CODES.

© RAY GOOD CUSTOM HOME DESIGNS, INC. 2013

**STEVENS RESIDENCE**

CLIENT / COMPANY NAME:

**RAYGOODDESIGNS.COM**

ADDITIONAL INFO:

Revisions:                      Date:

- △
- △
- △
- △

809-A Oakhurst Dr.  
Evans, G.A. 30809

Office: 706-364-8554  
Fax: 706-955-7945

Date Printed: 8/7/2014  
Scale: as noted


Drawn By:  
G.B. R.G. S.S.

Checked By:  
Ray Good

Project Number

**A-5**

Sheet # 5 OF 8

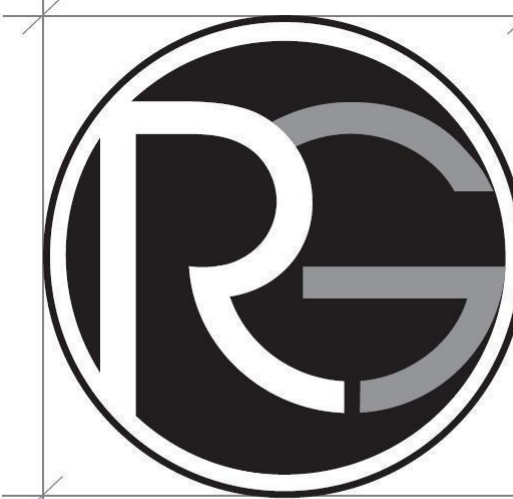

**RAY GOOD**  
CUSTOM HOME DESIGNS

**GENERAL NOTES**

- 1) DO NOT SCALE DRAWINGS
- 2) CONTRACTOR SHOULD VERIFY ALL CONDITIONS & DIMENSIONS AT SITE BEFORE BEGINNING CONSTRUCTION.
- 3) ANY DISCREPANCIES SHOULD BE REPORTED TO RG CUSTOM HOME DESIGNS FOR JUSTIFICATION AND/OR CORRECTIONS BEFORE PROCEEDING WITH WORK.
- 4) CONTRACTOR SHALL ASSUME ALL RESPONSIBILITY FOR ERRORS THAT ARE NOT REPORTED.
- 5) ALL WORK SHOULD BE PERFORMED IN ACCORDANCE WITH ALL APPLICABLE INTERNATIONAL BUILDING CODES.

© RAY GOOD CUSTOM HOME DESIGNS, INC. 2013

**STEVENS RESIDENCE**

CLIENT / COMPANY NAME:

[RAYGOODDESIGNS.COM](http://RAYGOODDESIGNS.COM)

ADDITIONAL INFO:

Revisions: \_\_\_\_\_ Date: \_\_\_\_\_

- △ \_\_\_\_\_
- △ \_\_\_\_\_
- △ \_\_\_\_\_
- △ \_\_\_\_\_

809-A Oakhurst Dr.  
Evans, G.A. 30809  
Office: 706-364-8554  
Fax: 706-955-7945

Date Printed: 8/7/2014  
Scale: as noted


Drawn By:  
G.B. R.G. S.S.

Checked By:  
Ray Good


Project Number

**A-6**

Sheet # 6 OF 8

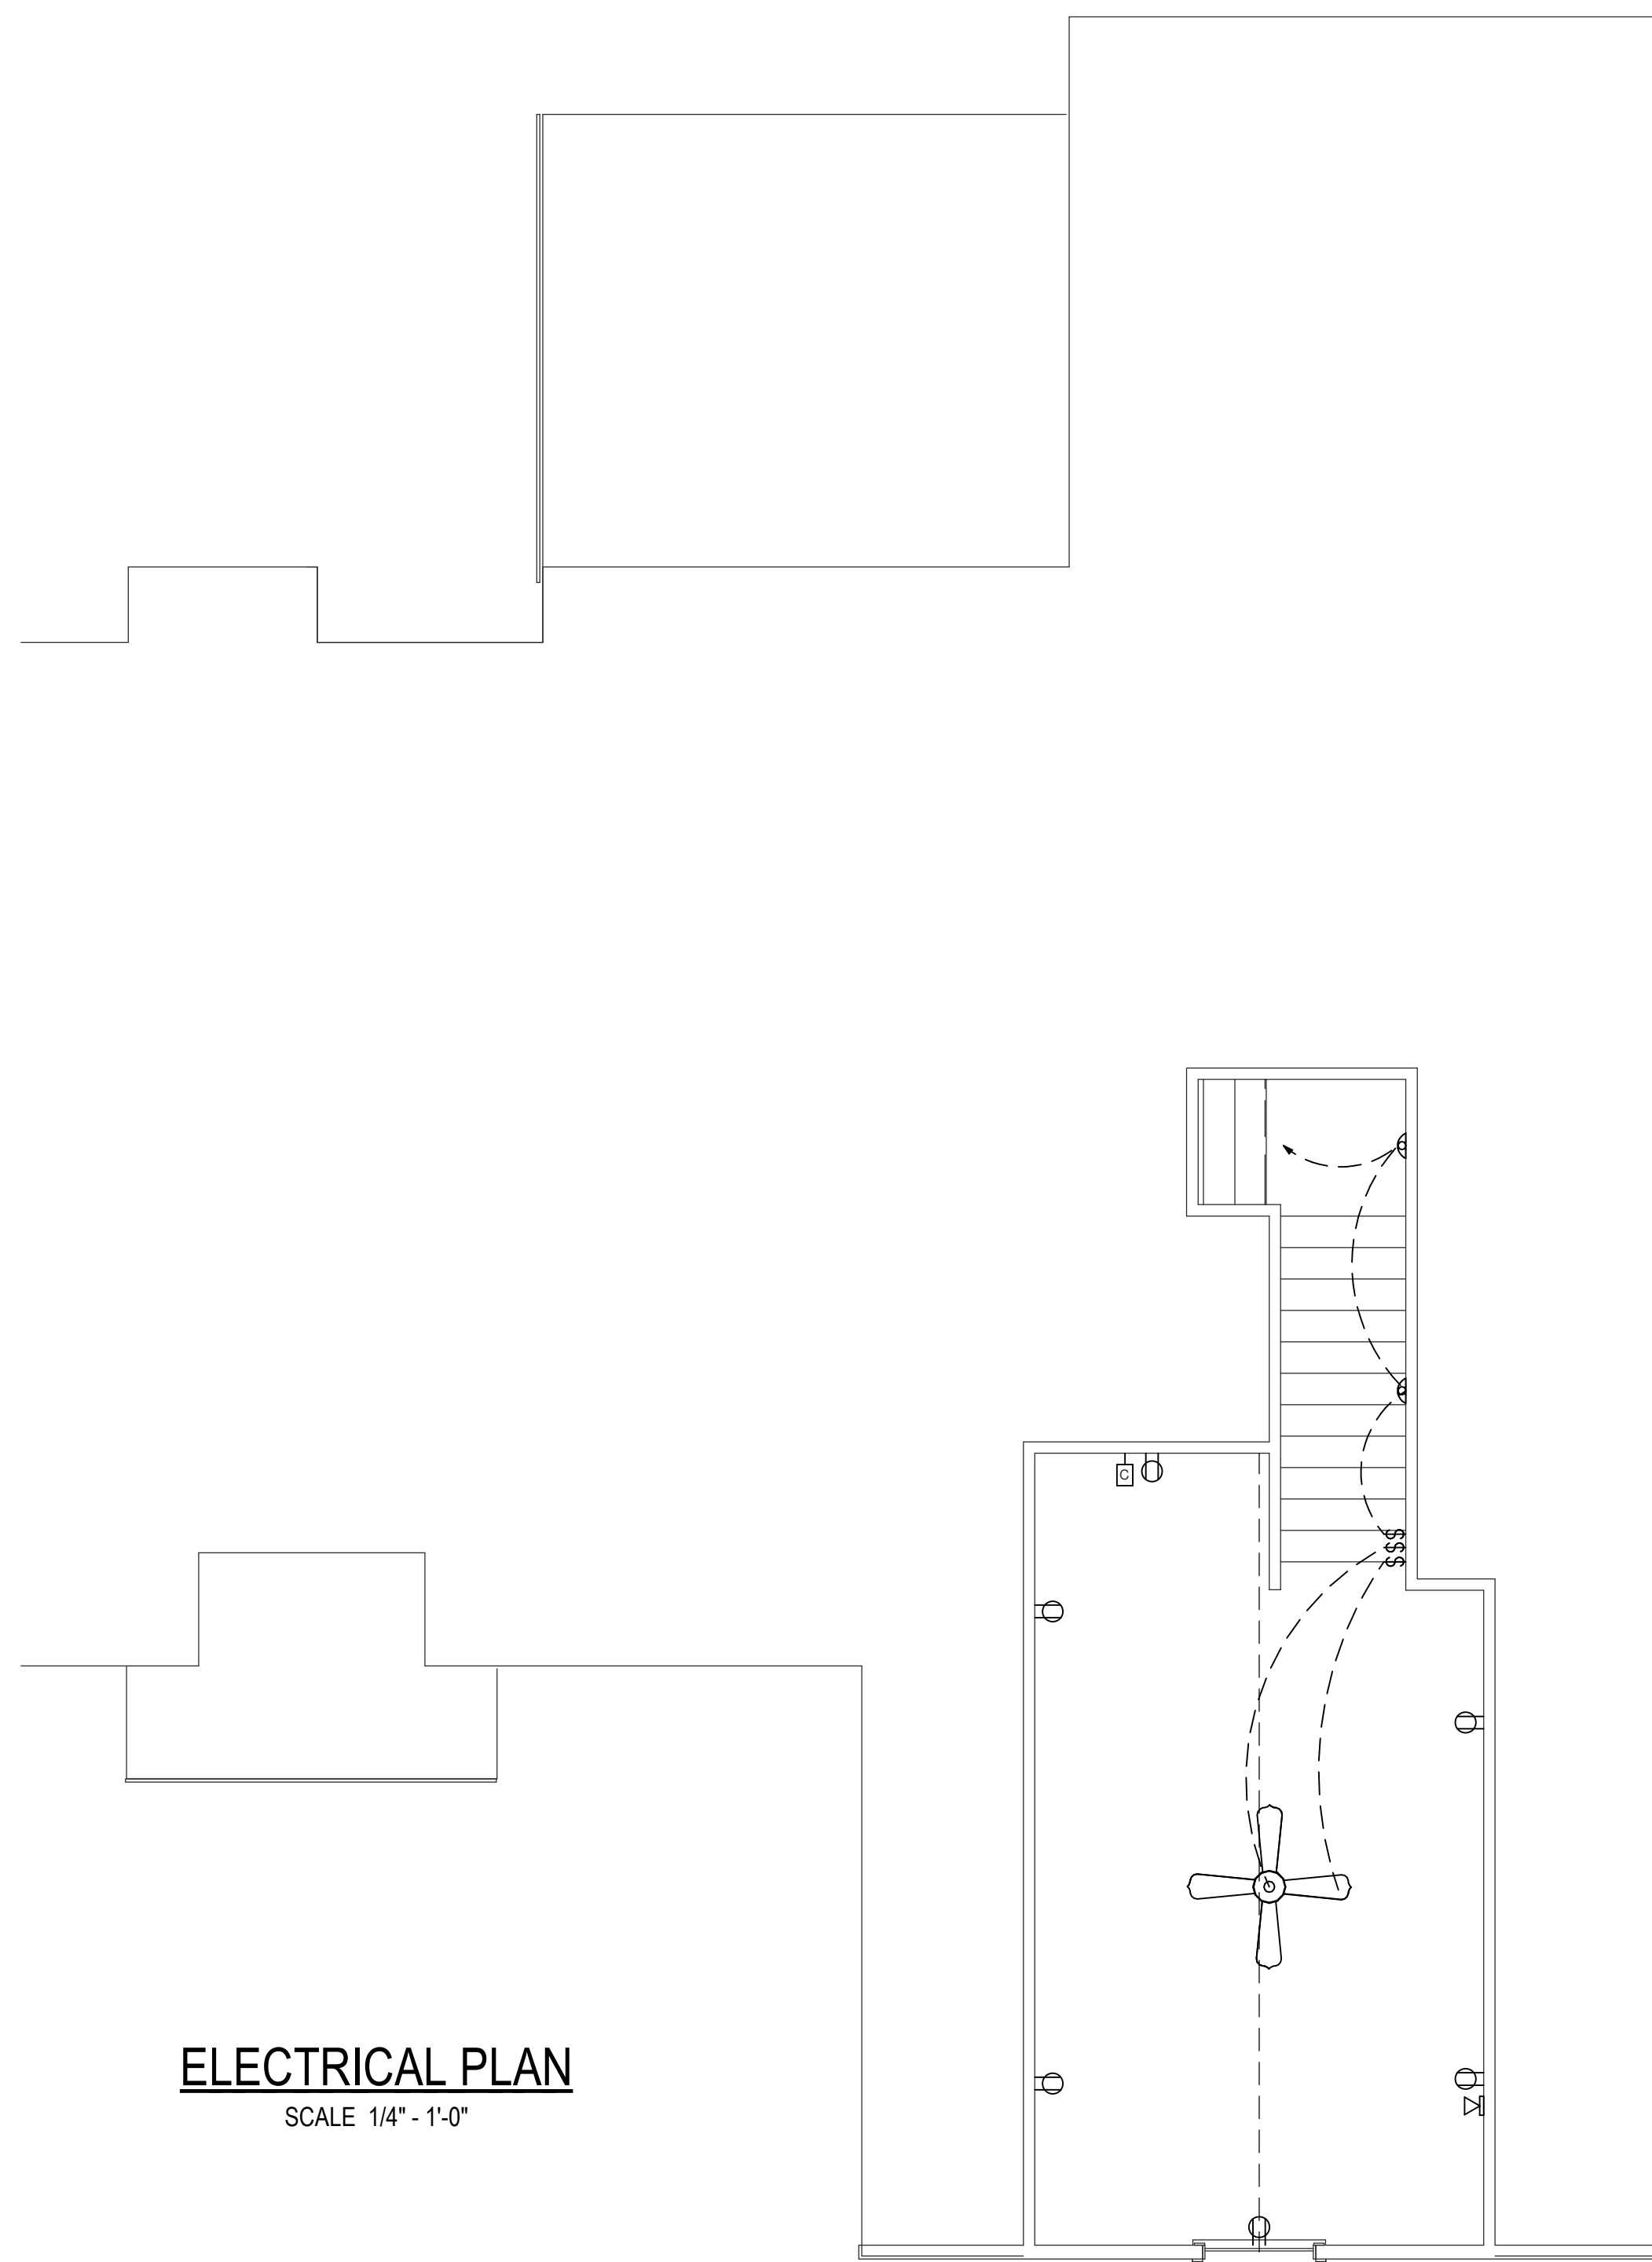

**ELECTRICAL PLAN**  
SCALE 1/4" - 1'-0"

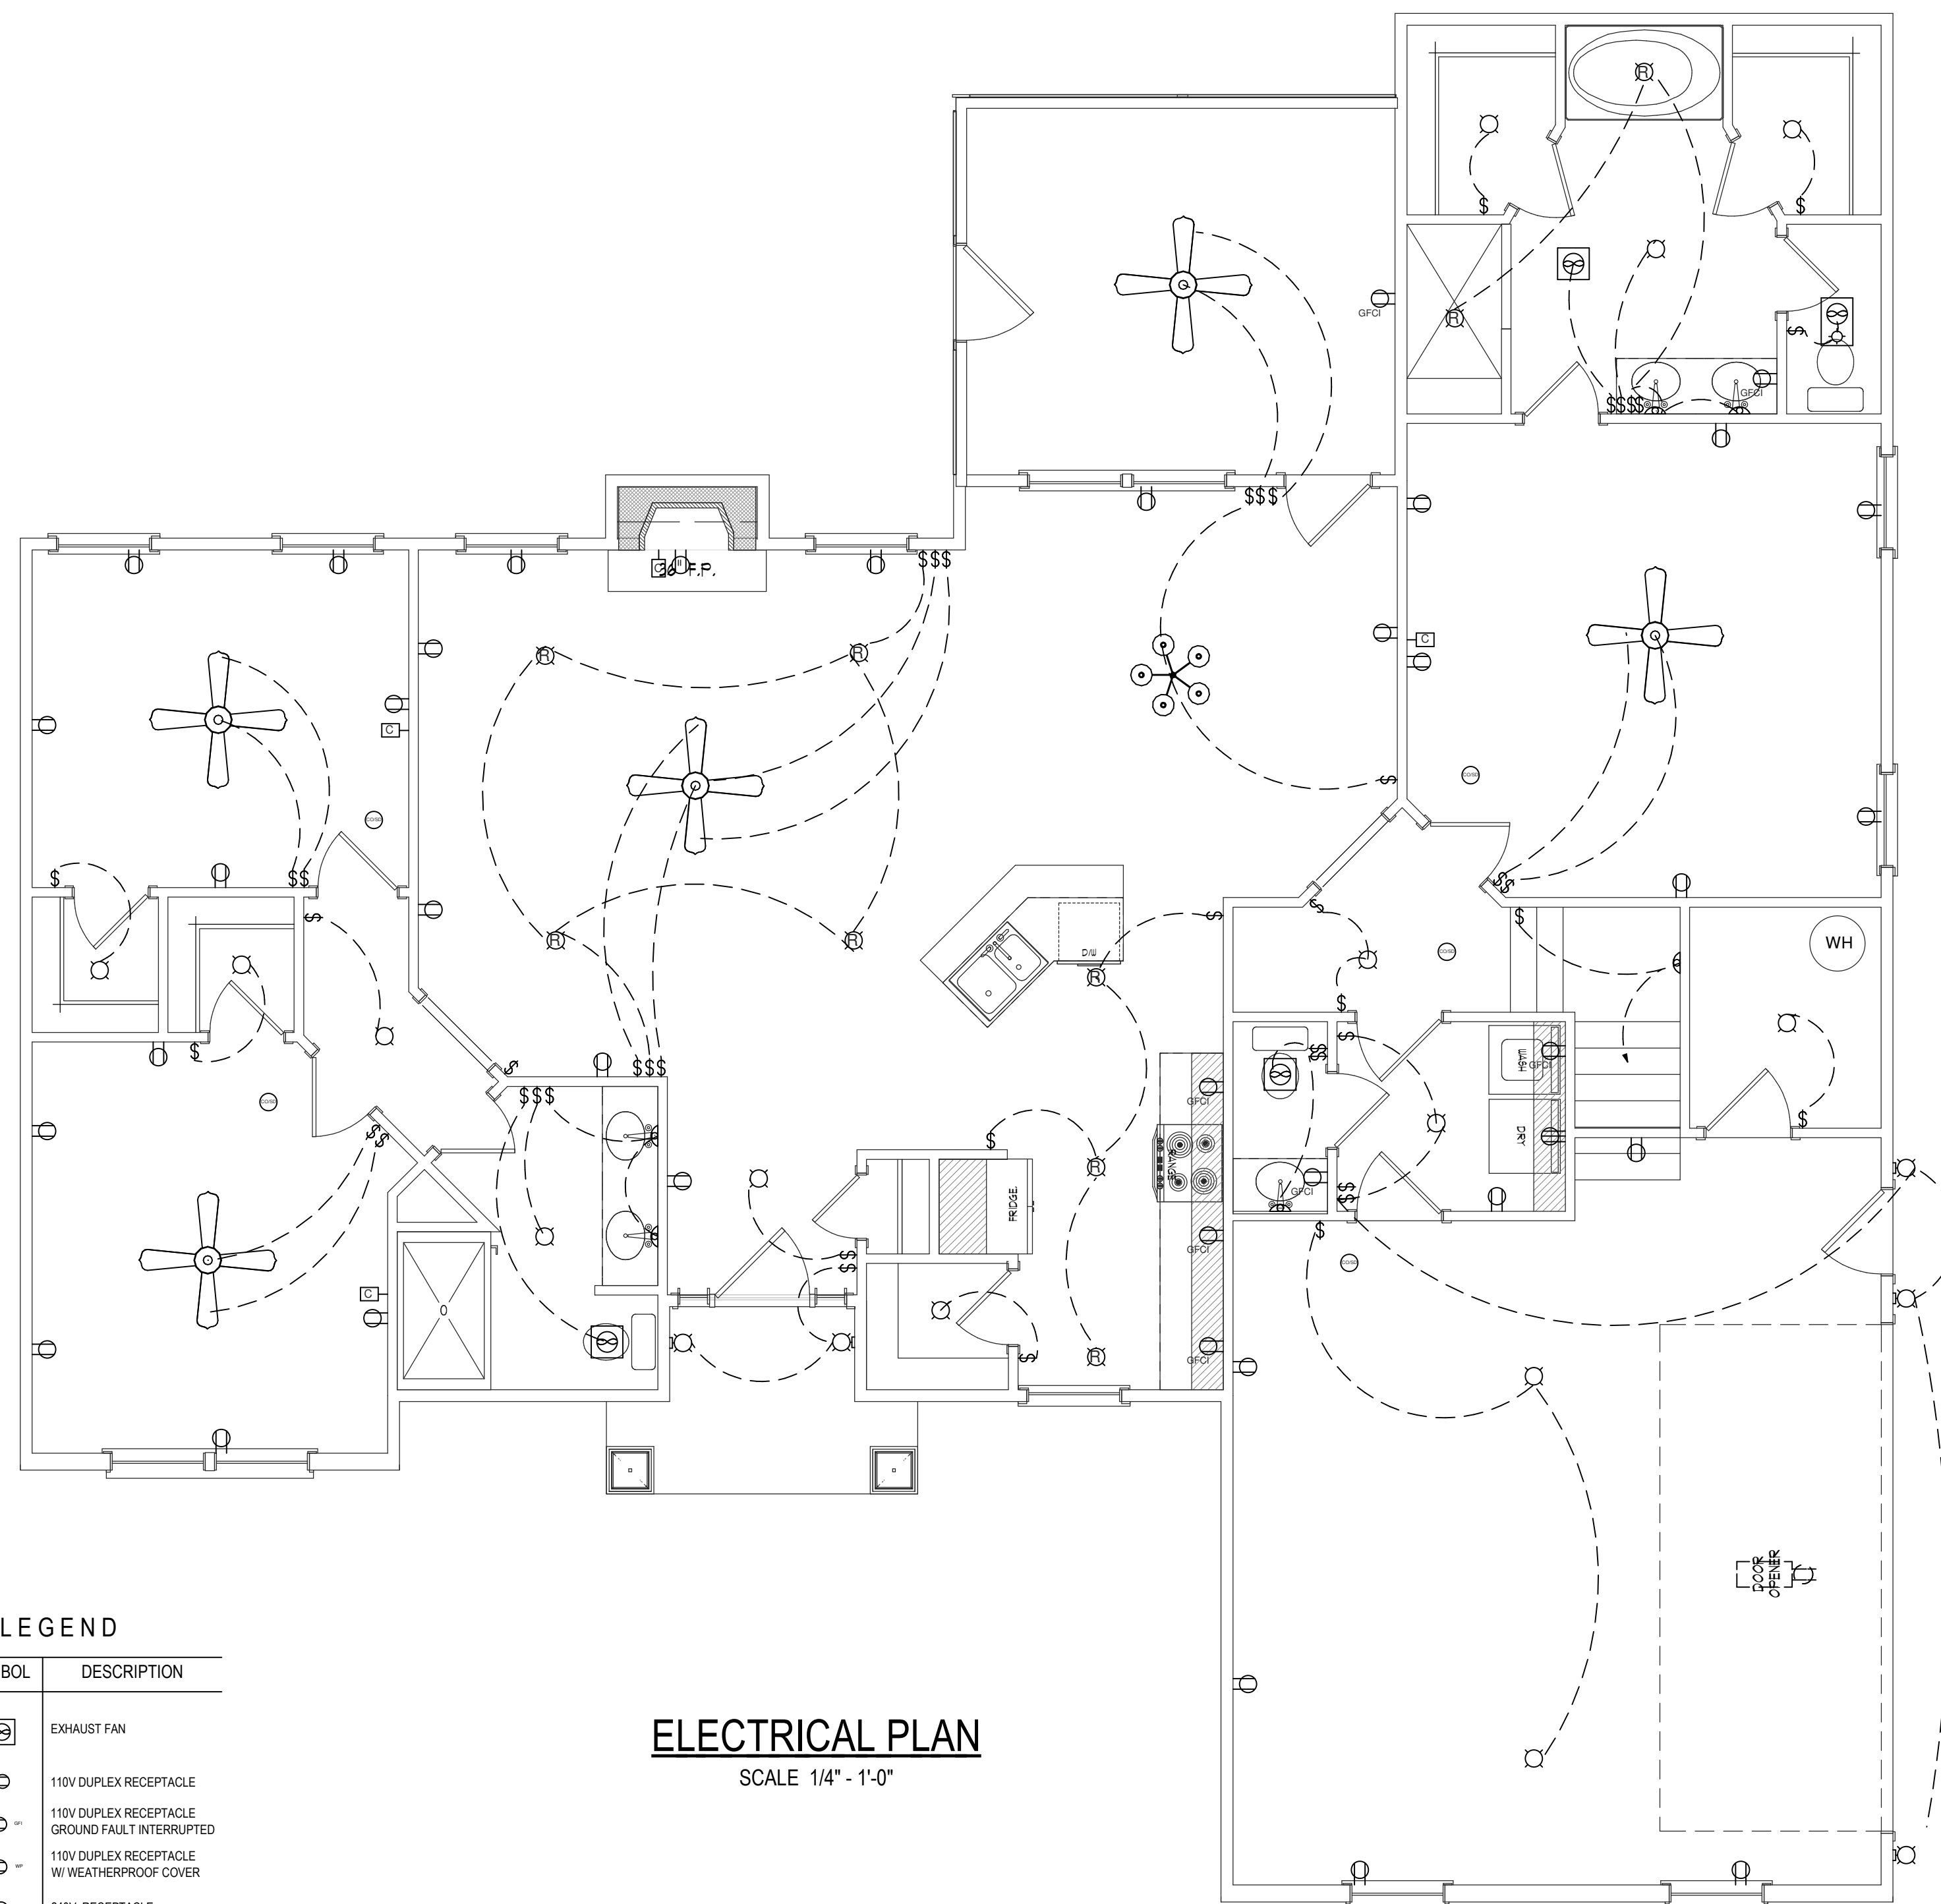


**ELECTRICAL PLAN**  
SCALE 1/4" - 1'-0"

**ELECTRICAL LEGEND**

SYMBOL	DESCRIPTION	SYMBOL	DESCRIPTION
	CEILING FAN W/ LIGHT		EXHAUST FAN
	FLUORESCENT LIGHT FIXTURE		110V DUPLEX RECEPTACLE
	CHANDELIER LIGHTING		110V DUPLEX RECEPTACLE W/ WEATHERPROOF COVER
	PENDANT LIGHTING		240V RECEPTACLE
	110V CEILING LIGHT FIXTURE		TELEPHONE JACKS
	110V RECESSED LIGHT FIXTURE		TELEVISION JACKS
	SINGLE POLE SWITCH		SMOKE DETECTOR
	OUTDOOR SWITCH		



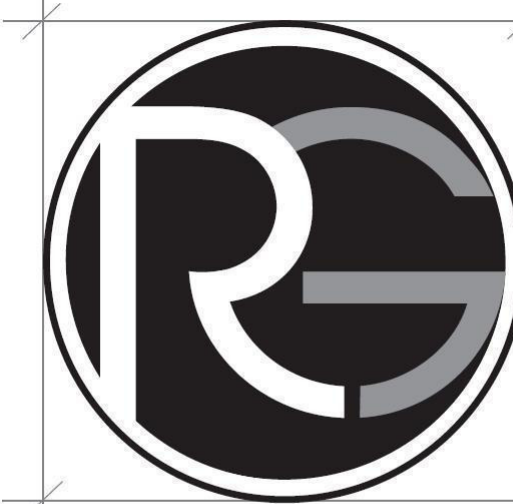


**RAY GOOD**  
CUSTOM HOME DESIGNS

**GENERAL NOTES**

- 1) DO NOT SCALE DRAWINGS
- 2) CONTRACTOR SHOULD VERIFY ALL CONDITIONS & DIMENSIONS AT SITE BEFORE BEGINNING CONSTRUCTION.
- 3) ANY DISCREPANCIES SHOULD BE REPORTED TO RG CUSTOM HOME DESIGNS FOR JUSTIFICATION AND/OR CORRECTIONS BEFORE PROCEEDING WITH WORK.
- 4) CONTRACTOR SHALL ASSUME ALL RESPONSIBILITY FOR ERRORS THAT ARE NOT REPORTED.
- 5) ALL WORK SHOULD BE PERFORMED IN ACCORDANCE WITH ALL APPLICABLE INTERNATIONAL BUILDING CODES.

© RAY GOOD CUSTOM HOME DESIGNS, INC. 2013

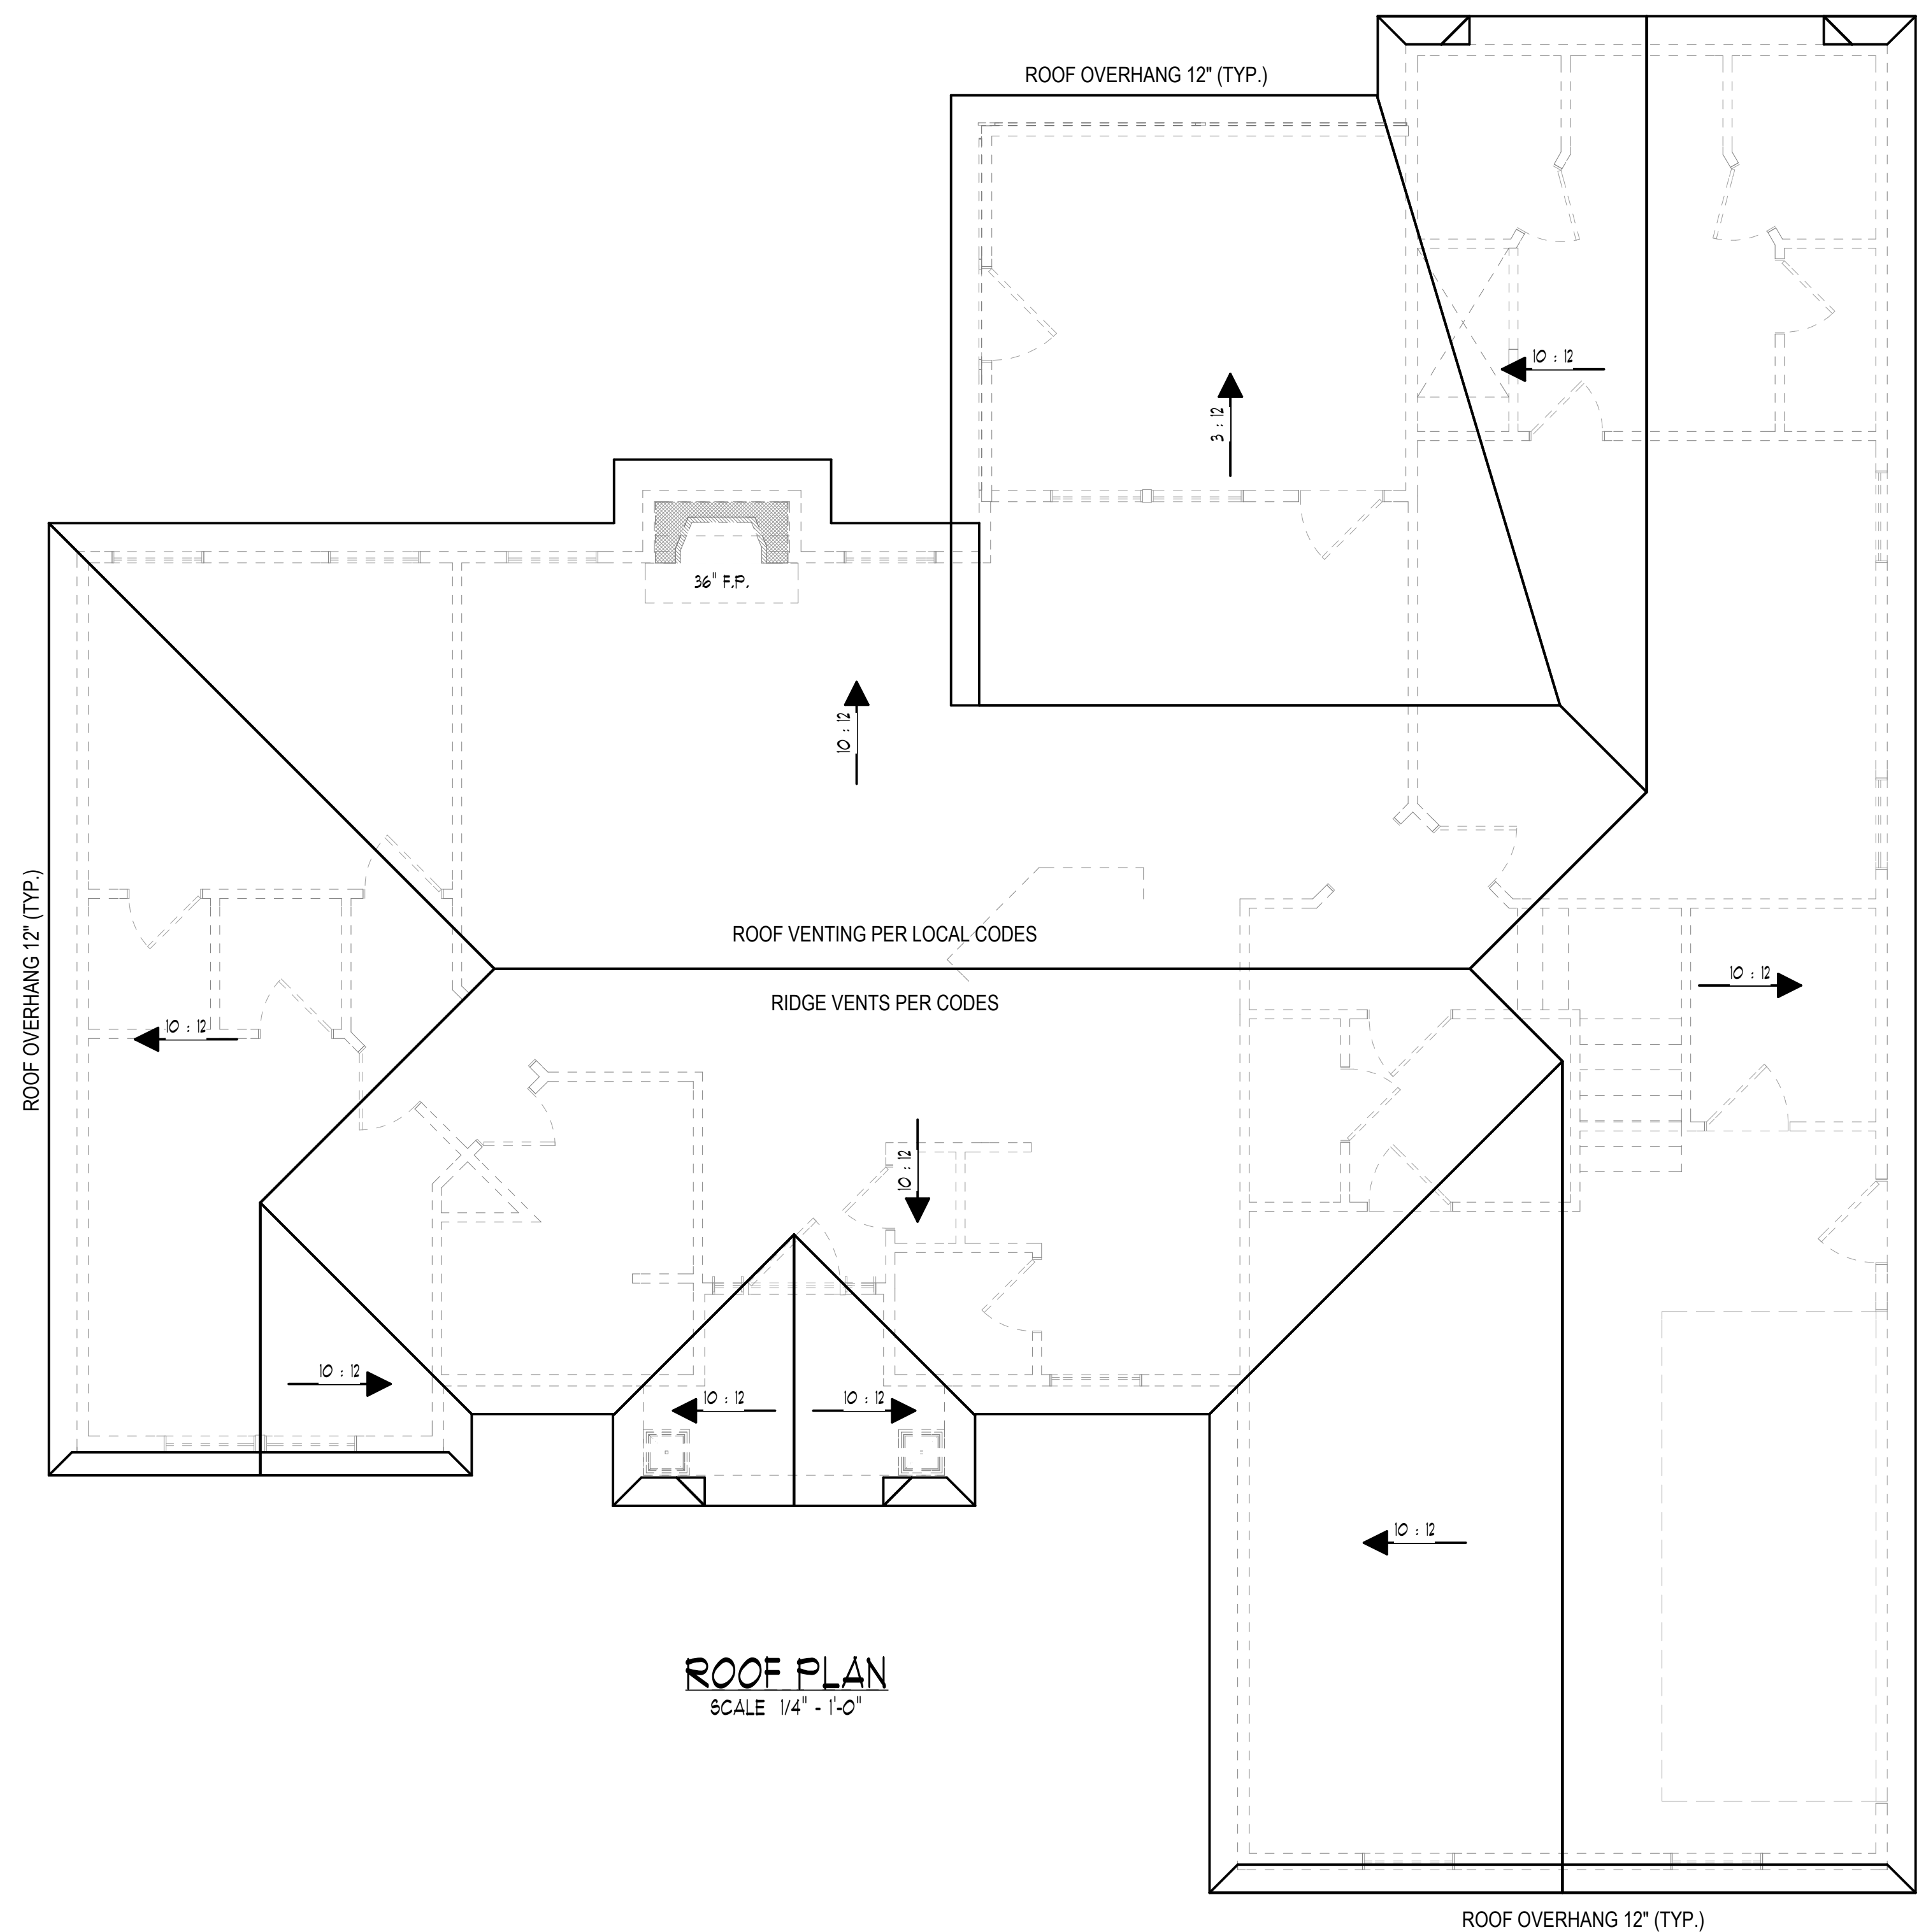

**ROOF PLAN**  
SCALE 1/4" = 1'-0"

**STEVENS RESIDENCE**

CLIENT / COMPANY NAME:

**RAYGOODDESIGNS.COM**

ADDITIONAL INFO:

Revisions: \_\_\_\_\_ Date: \_\_\_\_\_



809-A Oakhurst Dr.  
Evans, G.A. 30809  
Office: 706-364-8554  
Fax: 706-955-7945

Date Printed: 8/7/2014  
Scale: as noted

Drawn By:  
G.B. R.G. S.S.

Checked By:  
Ray Good

Project Number

**A-8**

Sheet # 8 OF 8